




NOTES:

1. FOR ELECTRICAL SYMBOLS SEE DWGS. E-04 & E-05.
2. FOR ABBREVIATIONS SEE DWG E-06.
3. FOR GENERAL NOTES SEE DWGS. E-02 & E-03.
4. FOR FIRE ALARM RISER DIAGRAM, SEE DWG E-16.
5. FOR CCTV RISER DIAGRAM, SEE DWG E-17.

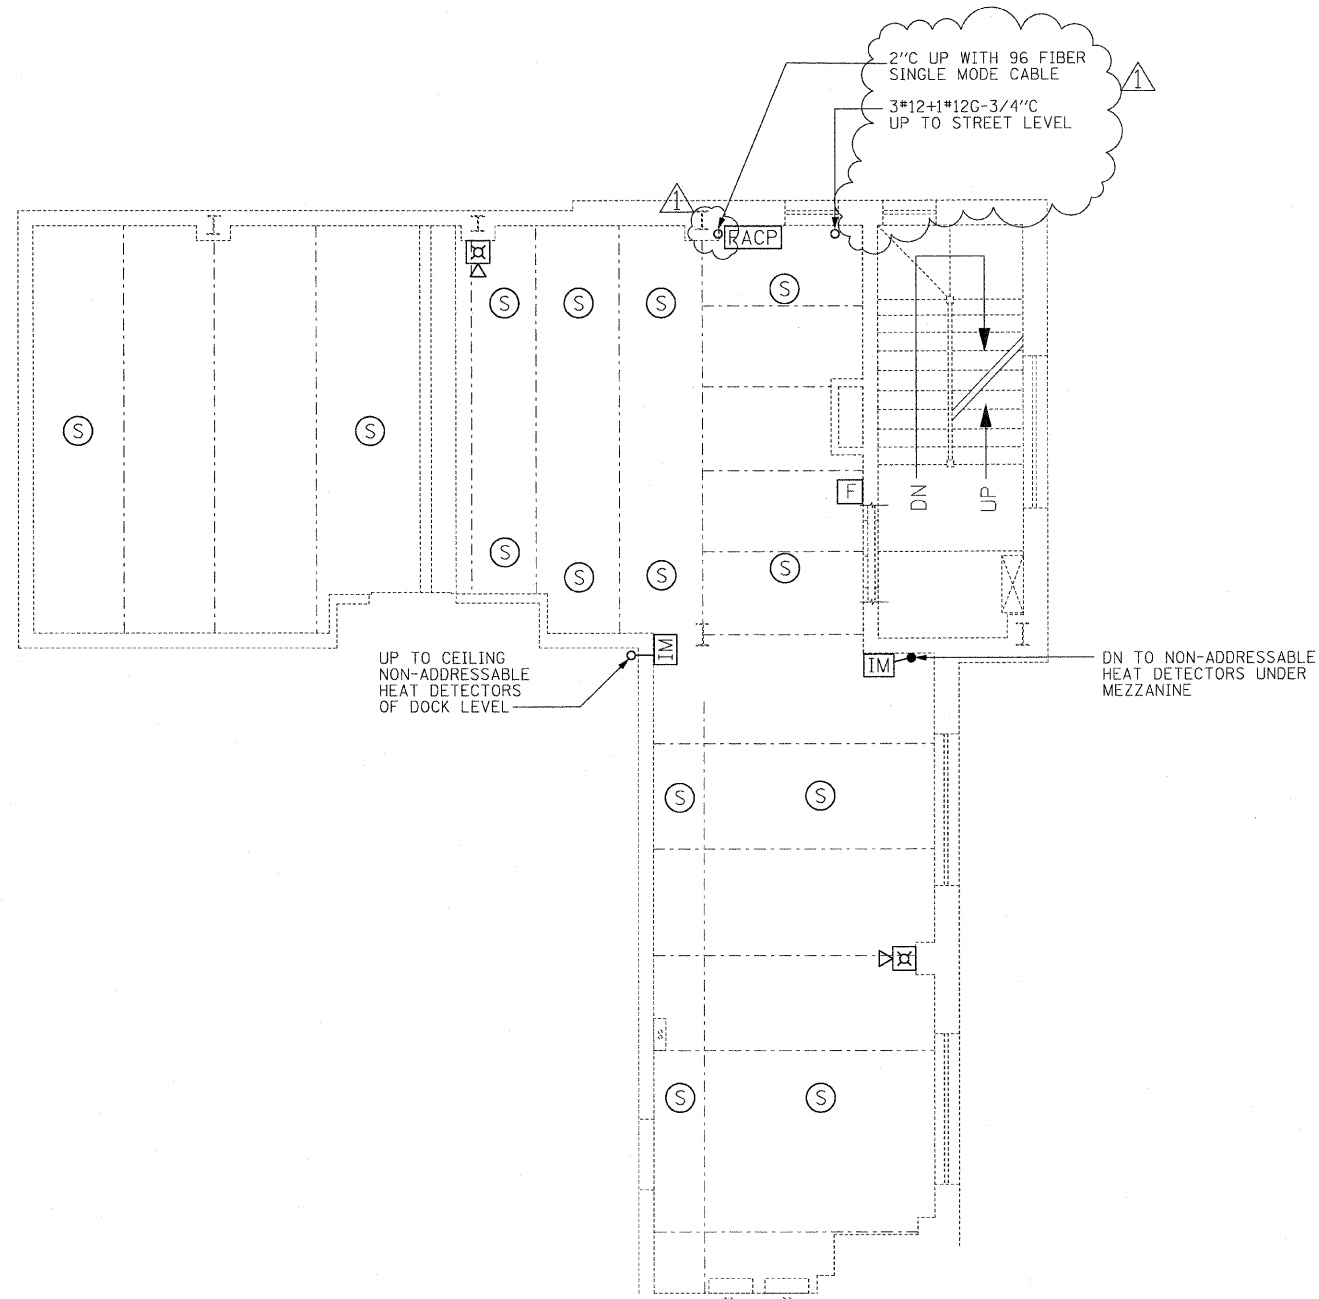

AUXILIARY SYSTEMS PLAN
1/4" = 1'-0"

▲ ADDENDUM - JULY 14, 2009

PB Americas, Inc. 230 WEST MONROE STREET, SUITE 900 CHICAGO, IL. 60606	USER NAME = sharma	DESIGNED - R. GODULIAS	REVISED -	STATE OF ILLINOIS DEPARTMENT OF TRANSPORTATION	AUXILIARY SYSTEMS PLAN EAST SIDE MEZZANINE LEVEL	F.A.P. RTE.	SECTION	COUNTY	TOTAL SHEETS	SHEET NO.
	FILE NAME = D160d61-shr-elic-48.dgn	DRAWN - S. SHARMA	REVISED -			389	2424-2B-R	COOK	398	319
	PLOT SCALE = NONE	CHECKED - M. INTATANO	REVISED -			CONTRACT NO. 60D61				
	PLOT DATE = 5/7/2009	DATE - MAY 8, 2009	REVISED -			FED. ROAD DIST. NO. 1 ILLINOIS FED. AID PROJECT				
				SCALE: AS SHOWN	SHEET NO. E-48 OF E-125 SHEETS	STA. 379+06.09 TO STA. 382+45.28				