




- NOTES:**
1. FOR ELECTRICAL SYMBOLS SEE DWG. E-04 & E-05.
 2. FOR ABBREVIATIONS SEE DWG. E-06.
 3. FOR GENERAL NOTES SEE DWGS. E-02.& E-03.
 4. FOR FIRE ALARM RISER DIAGRAM, SEE DWG E-16.
 5. FOR CCTV RISER DIAGRAM, SEE DWG E-17.
 6. FOR CCTV SUBMARINE CABINET ELEVATION SEE DWG E-50.
 7. CONDUIT AND FIBER OPTIC CABLE ROUTING IS SCHEMATIC. CONTRACTOR TO PROVIDE AND INSTALL 16" x 6" x 6" BOXES LIMITING CONDUIT BENDS TO 270°.

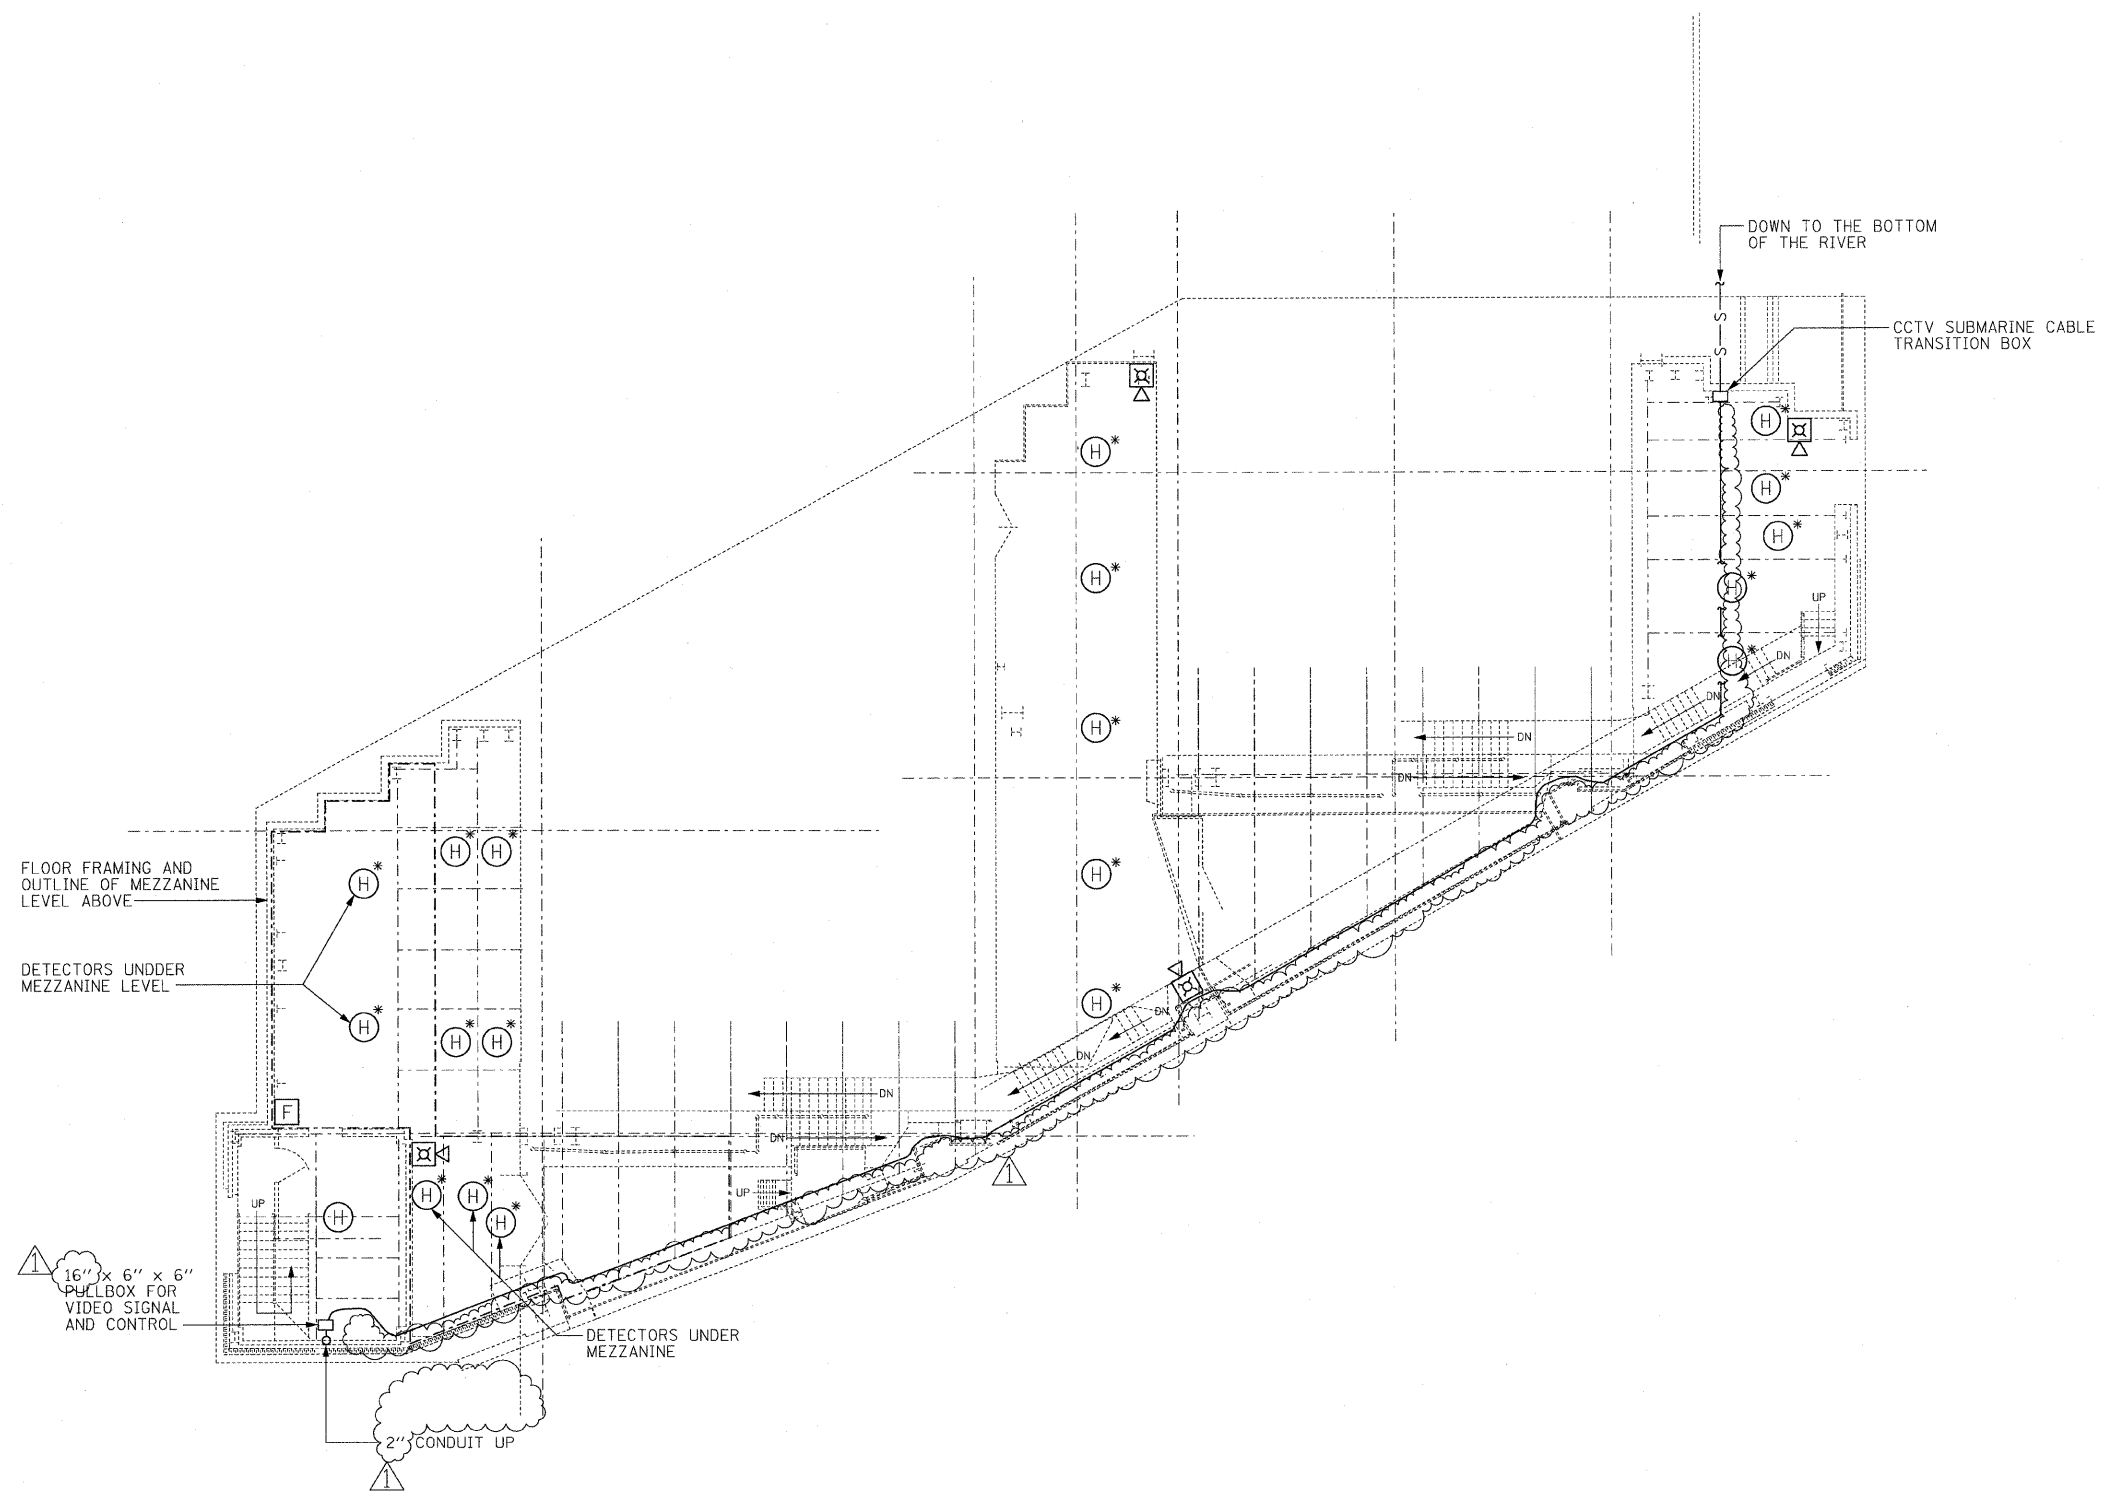

AUXILIARY SYSTEMS PLAN
1/8" = 1'-0"

ADDENDUM - JULY 14, 2009

PB Americas, Inc.
230 WEST MONROE STREET,
SUITE 900
CHICAGO, IL. 60606

USER NAME = sharma	DESIGNED - R. GODULIAS	REVISED -
FILE NAME = D:\60d61-sht-elic-51.dgn	DRAWN - S. SHARMA	REVISED -
PLOT SCALE = NONE	CHECKED - M. INTATANO	REVISED -
PLOT DATE = 5/7/2009	DATE - MAY 8, 2009	REVISED -

STATE OF ILLINOIS
DEPARTMENT OF TRANSPORTATION

AUXILIARY SYSTEMS PLAN
WEST SIDE DOCK LEVEL

SCALE: AS SHOWN SHEET NO. E-51 OF E-125 SHEETS STA. 379+06.09 TO STA. 382+45.28

F.A.P. RTE.	SECTION	COUNTY	TOTAL SHEETS	SHEET NO.
389	2424-2B-R	COOK	398	322
FED. ROAD DIST. NO. 1 ILLINOIS FED. AID PROJECT			CONTRACT NO. 60D61	