
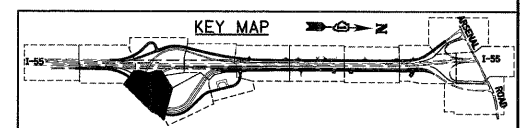
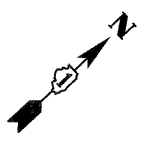


**EXISTING LEGEND**

	PAVEMENT REMOVAL
	PAVED SHOULDER REMOVAL
	DRIVEWAY PAVEMENT REMOVAL
	HOT MIX ASPHALT SURFACE REMOVAL
	TREE REMOVAL WITH UNIT DIAMETER TRUNK
	LINEAL REMOVAL ITEM
	CONTROL POINT NUMBER

- NOTES:**
- SEE ELECTRICAL PLANS FOR LIGHTING REMOVALS.
  - SEE DRAINAGE PLANS FOR DRAINAGE REMOVALS.

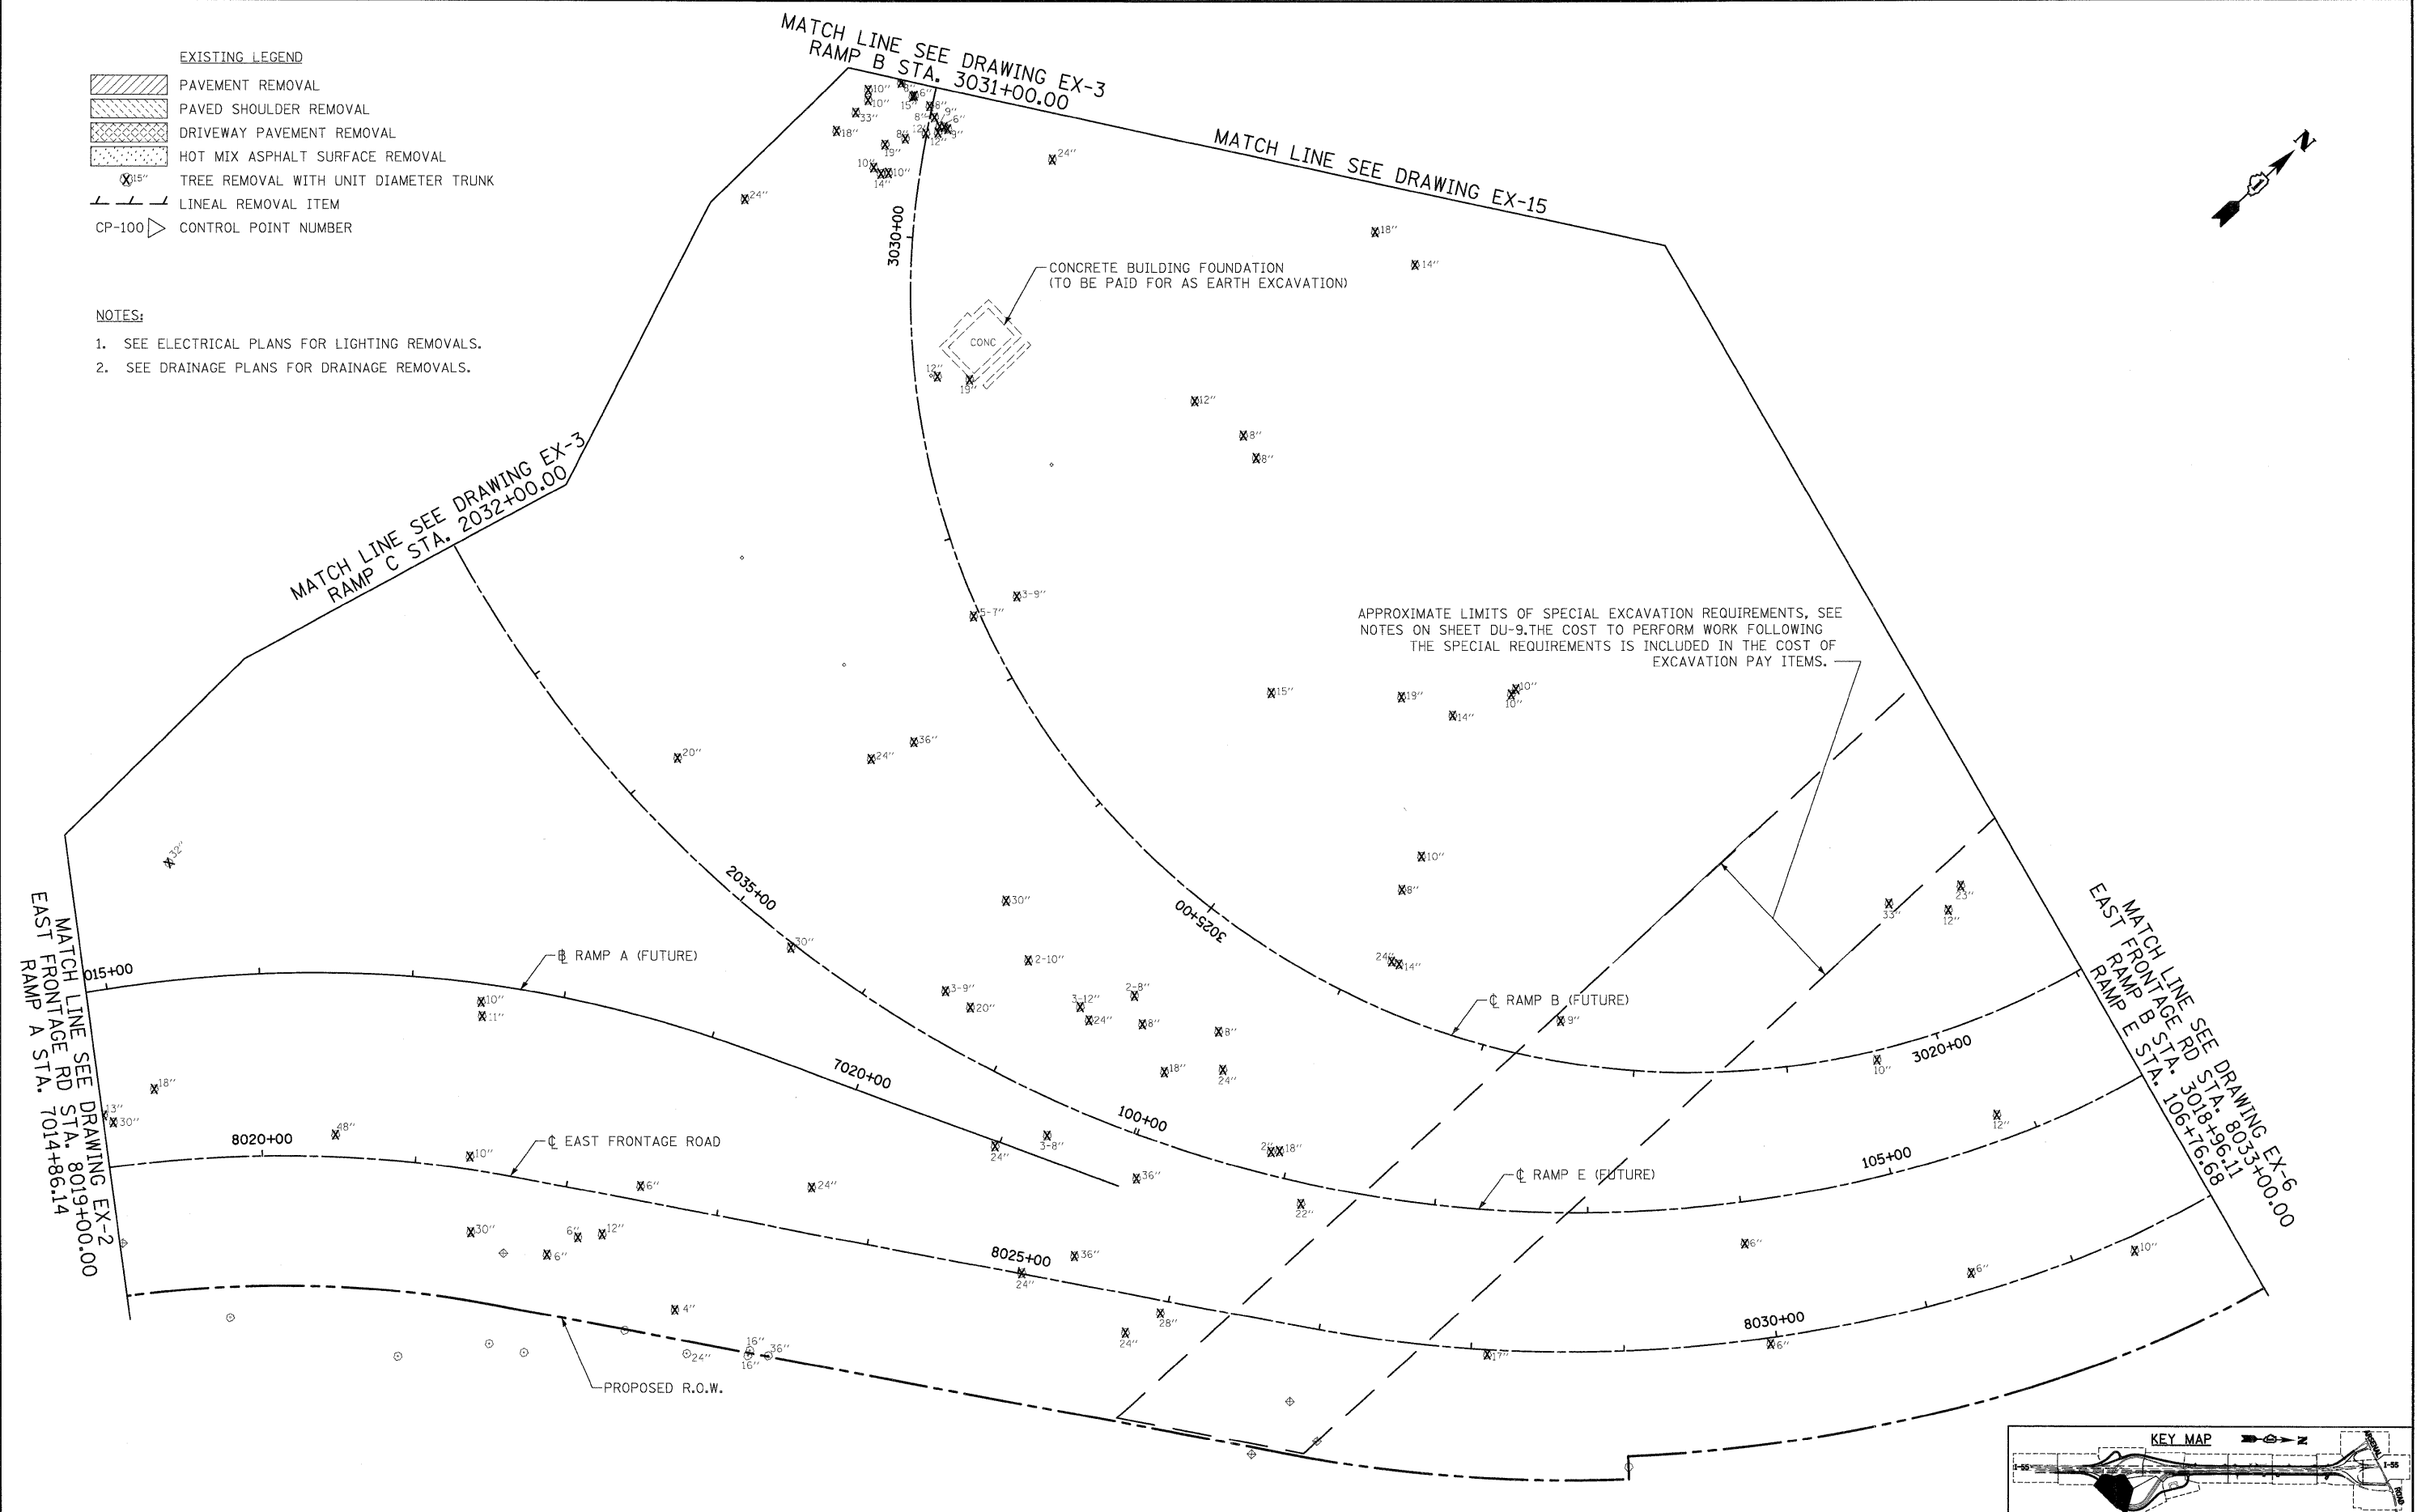

**McDonough Associates Inc.**  
 Engineers / Architects  
 130 East Randolph Street Chicago, Illinois 60601

FILE NAME = D162C31-SHT-REM04.dgn	USER NAME = TKLuaga	DESIGNED - JTF	REVISED -
PLOT SCALE = 1:50	CHECKED - DLT	DRAWN - JTF	REVISED -
PLOT DATE = 12/11/2009	DATE = 12/18/09	CHECKED - DLT	REVISED -

**STATE OF ILLINOIS  
DEPARTMENT OF TRANSPORTATION**

**EXISTING PLAN AND REMOVALS**

SCALE: 1"=50' SHEET NO. 4 OF 15 SHEETS STA. TO STA.

F.A.I. RTE.	SECTION	COUNTY	TOTAL SHEETS	SHEET NO.
55	(99-1&2)AC-3	WILL	524	41
CONTRACT NO. 60C31			FED. ROAD DIST. NO. 1 ILLINOIS FED. AID PROJECT	

**FINAL**