




MATCH LINE SEE DRAWING EX-9  
WEST FRONTAGE CONNECTOR  
STA. 6050+00.00

MATCH LINE SEE DRAWING EX-9  
ARSENAL RD STA. 932+50.00


MATCH LINE SEE DRAWING EX-11  
WEST FRONTAGE CONNECTOR  
STA. 6064+50.00

MATCH LINE SEE DRAWING EX-11  
ARSENAL RD STA. 947+00.00

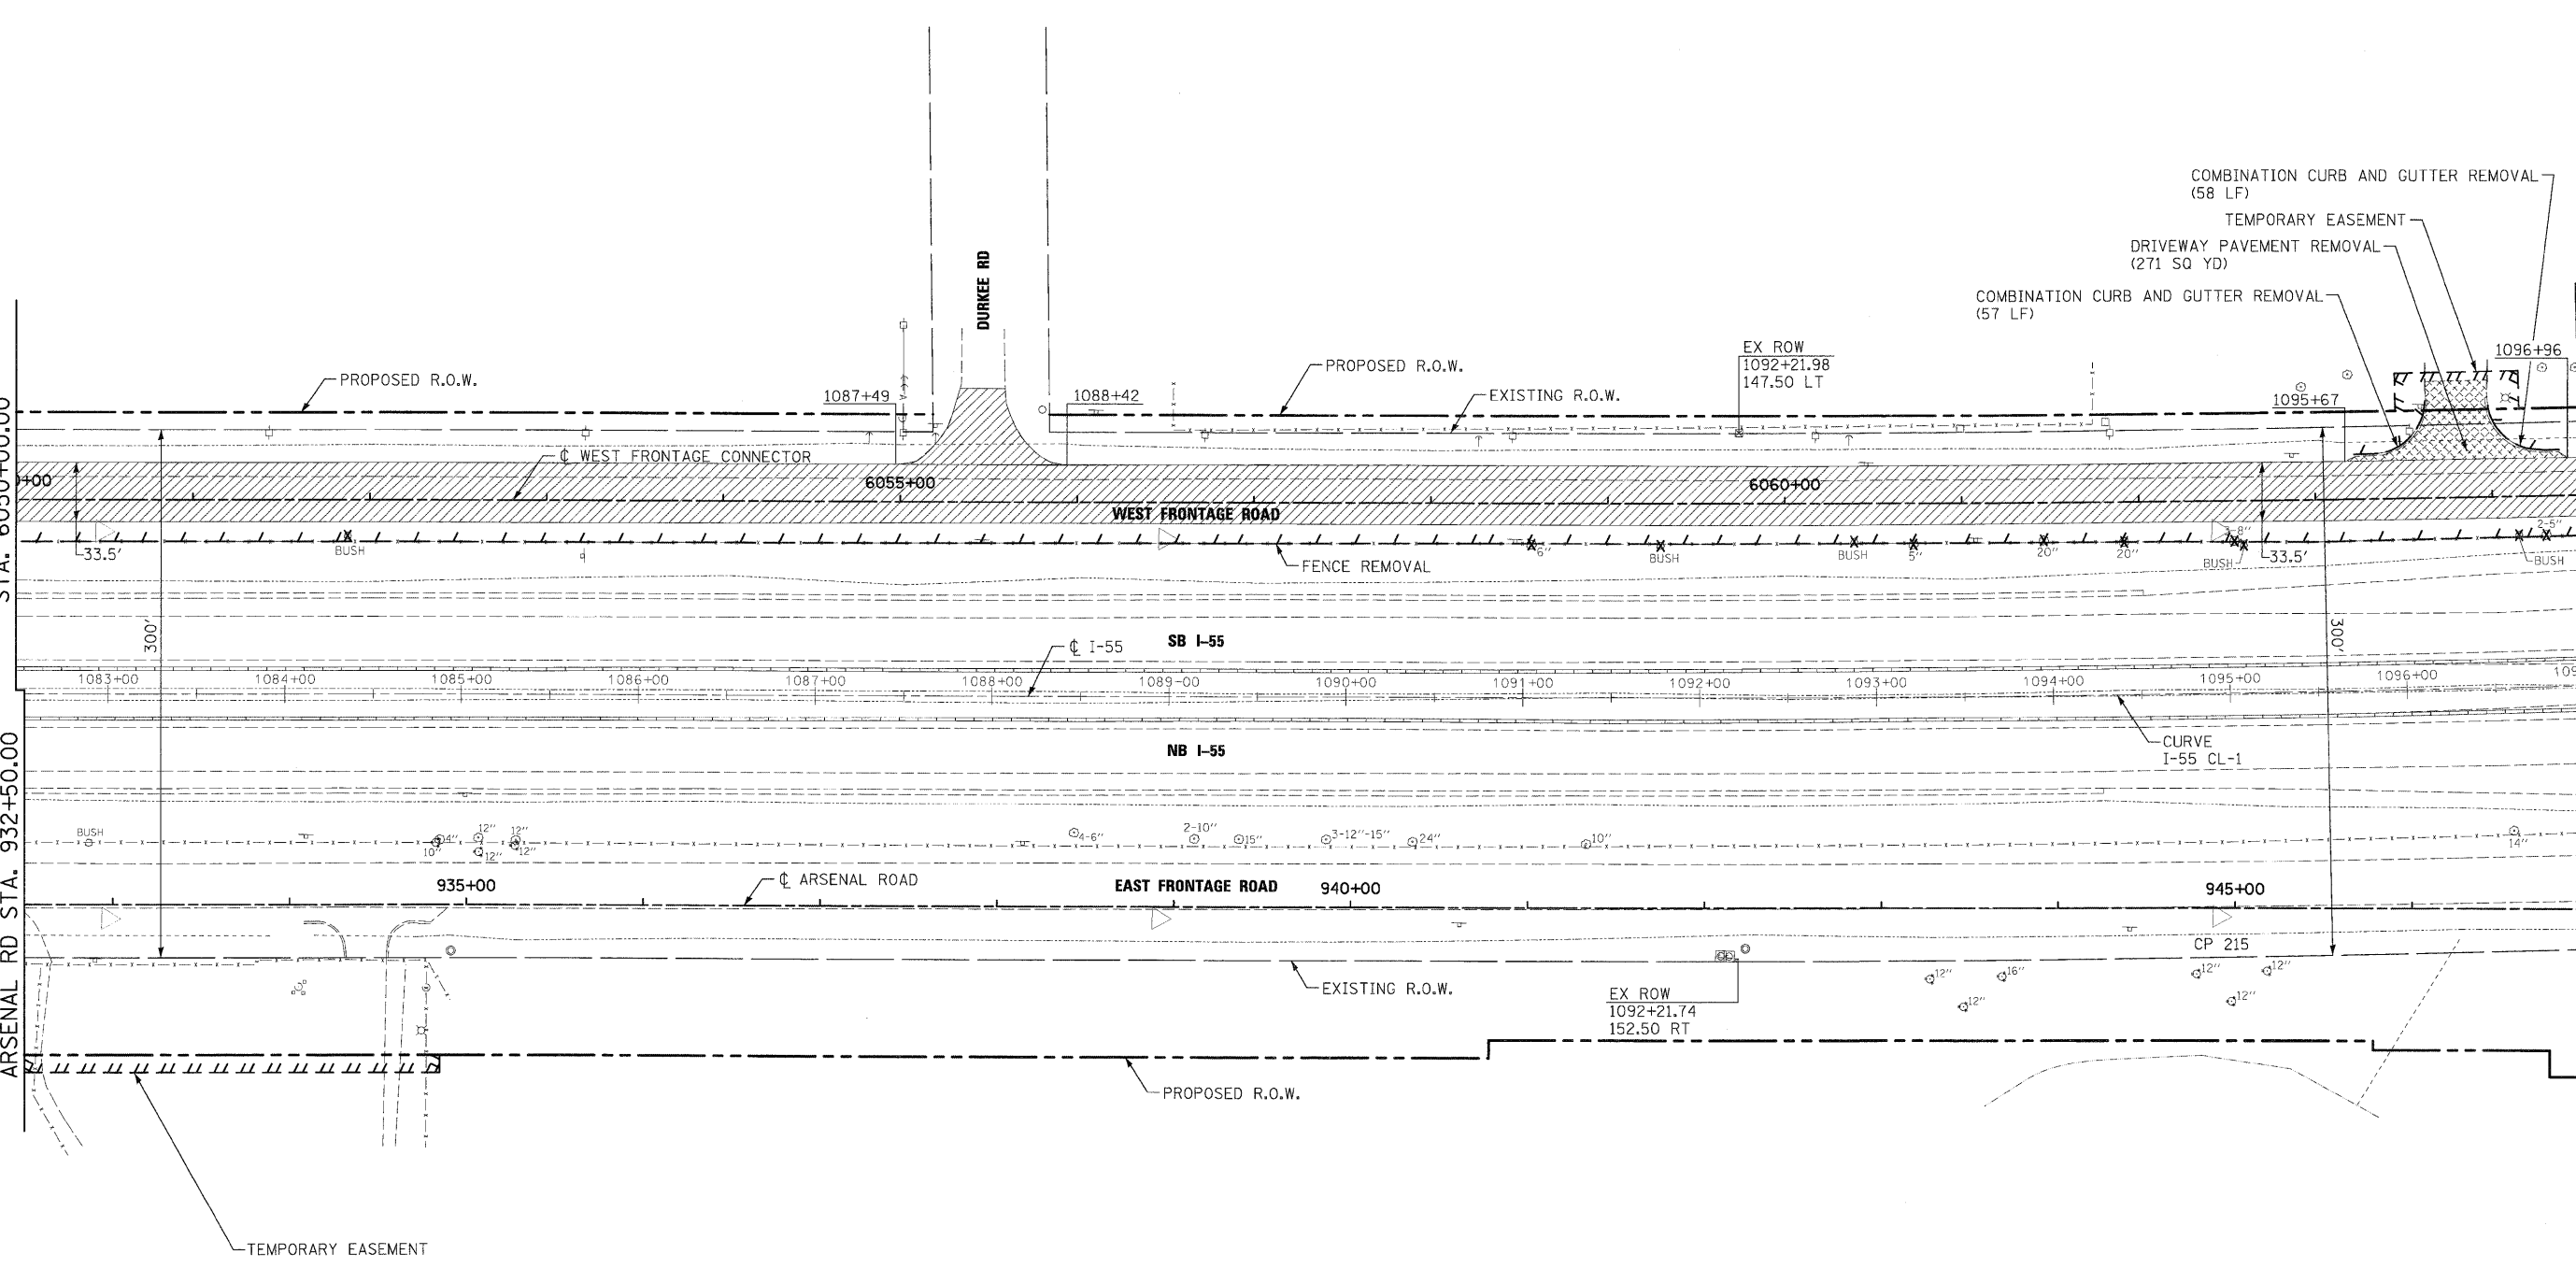

- EXISTING LEGEND**
- PAVEMENT REMOVAL
  - PAVED SHOULDER REMOVAL
  - DRIVEWAY PAVEMENT REMOVAL
  - HOT MIX ASPHALT SURFACE REMOVAL
  - TREE REMOVAL WITH UNIT DIAMETER TRUNK
  - LINEAL REMOVAL ITEM
  - CONTROL POINT NUMBER

- NOTES:**
- SEE ELECTRICAL PLANS FOR LIGHTING REMOVALS.
  - SEE DRAINAGE PLANS FOR DRAINAGE REMOVALS.

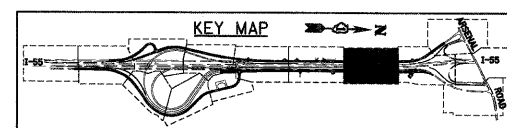

**McDonough Associates Inc.**  
 Engineers / Architects  
 130 East Randolph Street, Chicago, Illinois 60601

FILE NAME = D168031-SHT-REM1.dgn	USER NAME = TK1uege1	DESIGNED - JTF	REVISED -
		DRAWN - JTF	REVISED -
		CHECKED - DLT	REVISED -
		DATE - 12/18/09	REVISED -

**STATE OF ILLINOIS  
DEPARTMENT OF TRANSPORTATION**

**EXISTING PLAN AND REMOVALS**

SCALE: 1"=50'    SHEET NO. 10 OF 15 SHEETS    STA.    TO STA.

F.A.I. RTE.	SECTION	COUNTY	TOTAL SHEETS	SHEET NO.
55	(99-1&2)AC-3	WILL	524	47
CONTRACT NO. 60C31				
FED. ROAD DIST. NO. 1 ILLINOIS FED. AID PROJECT				

**FINAL**