



MATCH LINE SEE SHEET DU-12  
WEST FRONTAGE CONNECTOR  
STA. 6086+50.00

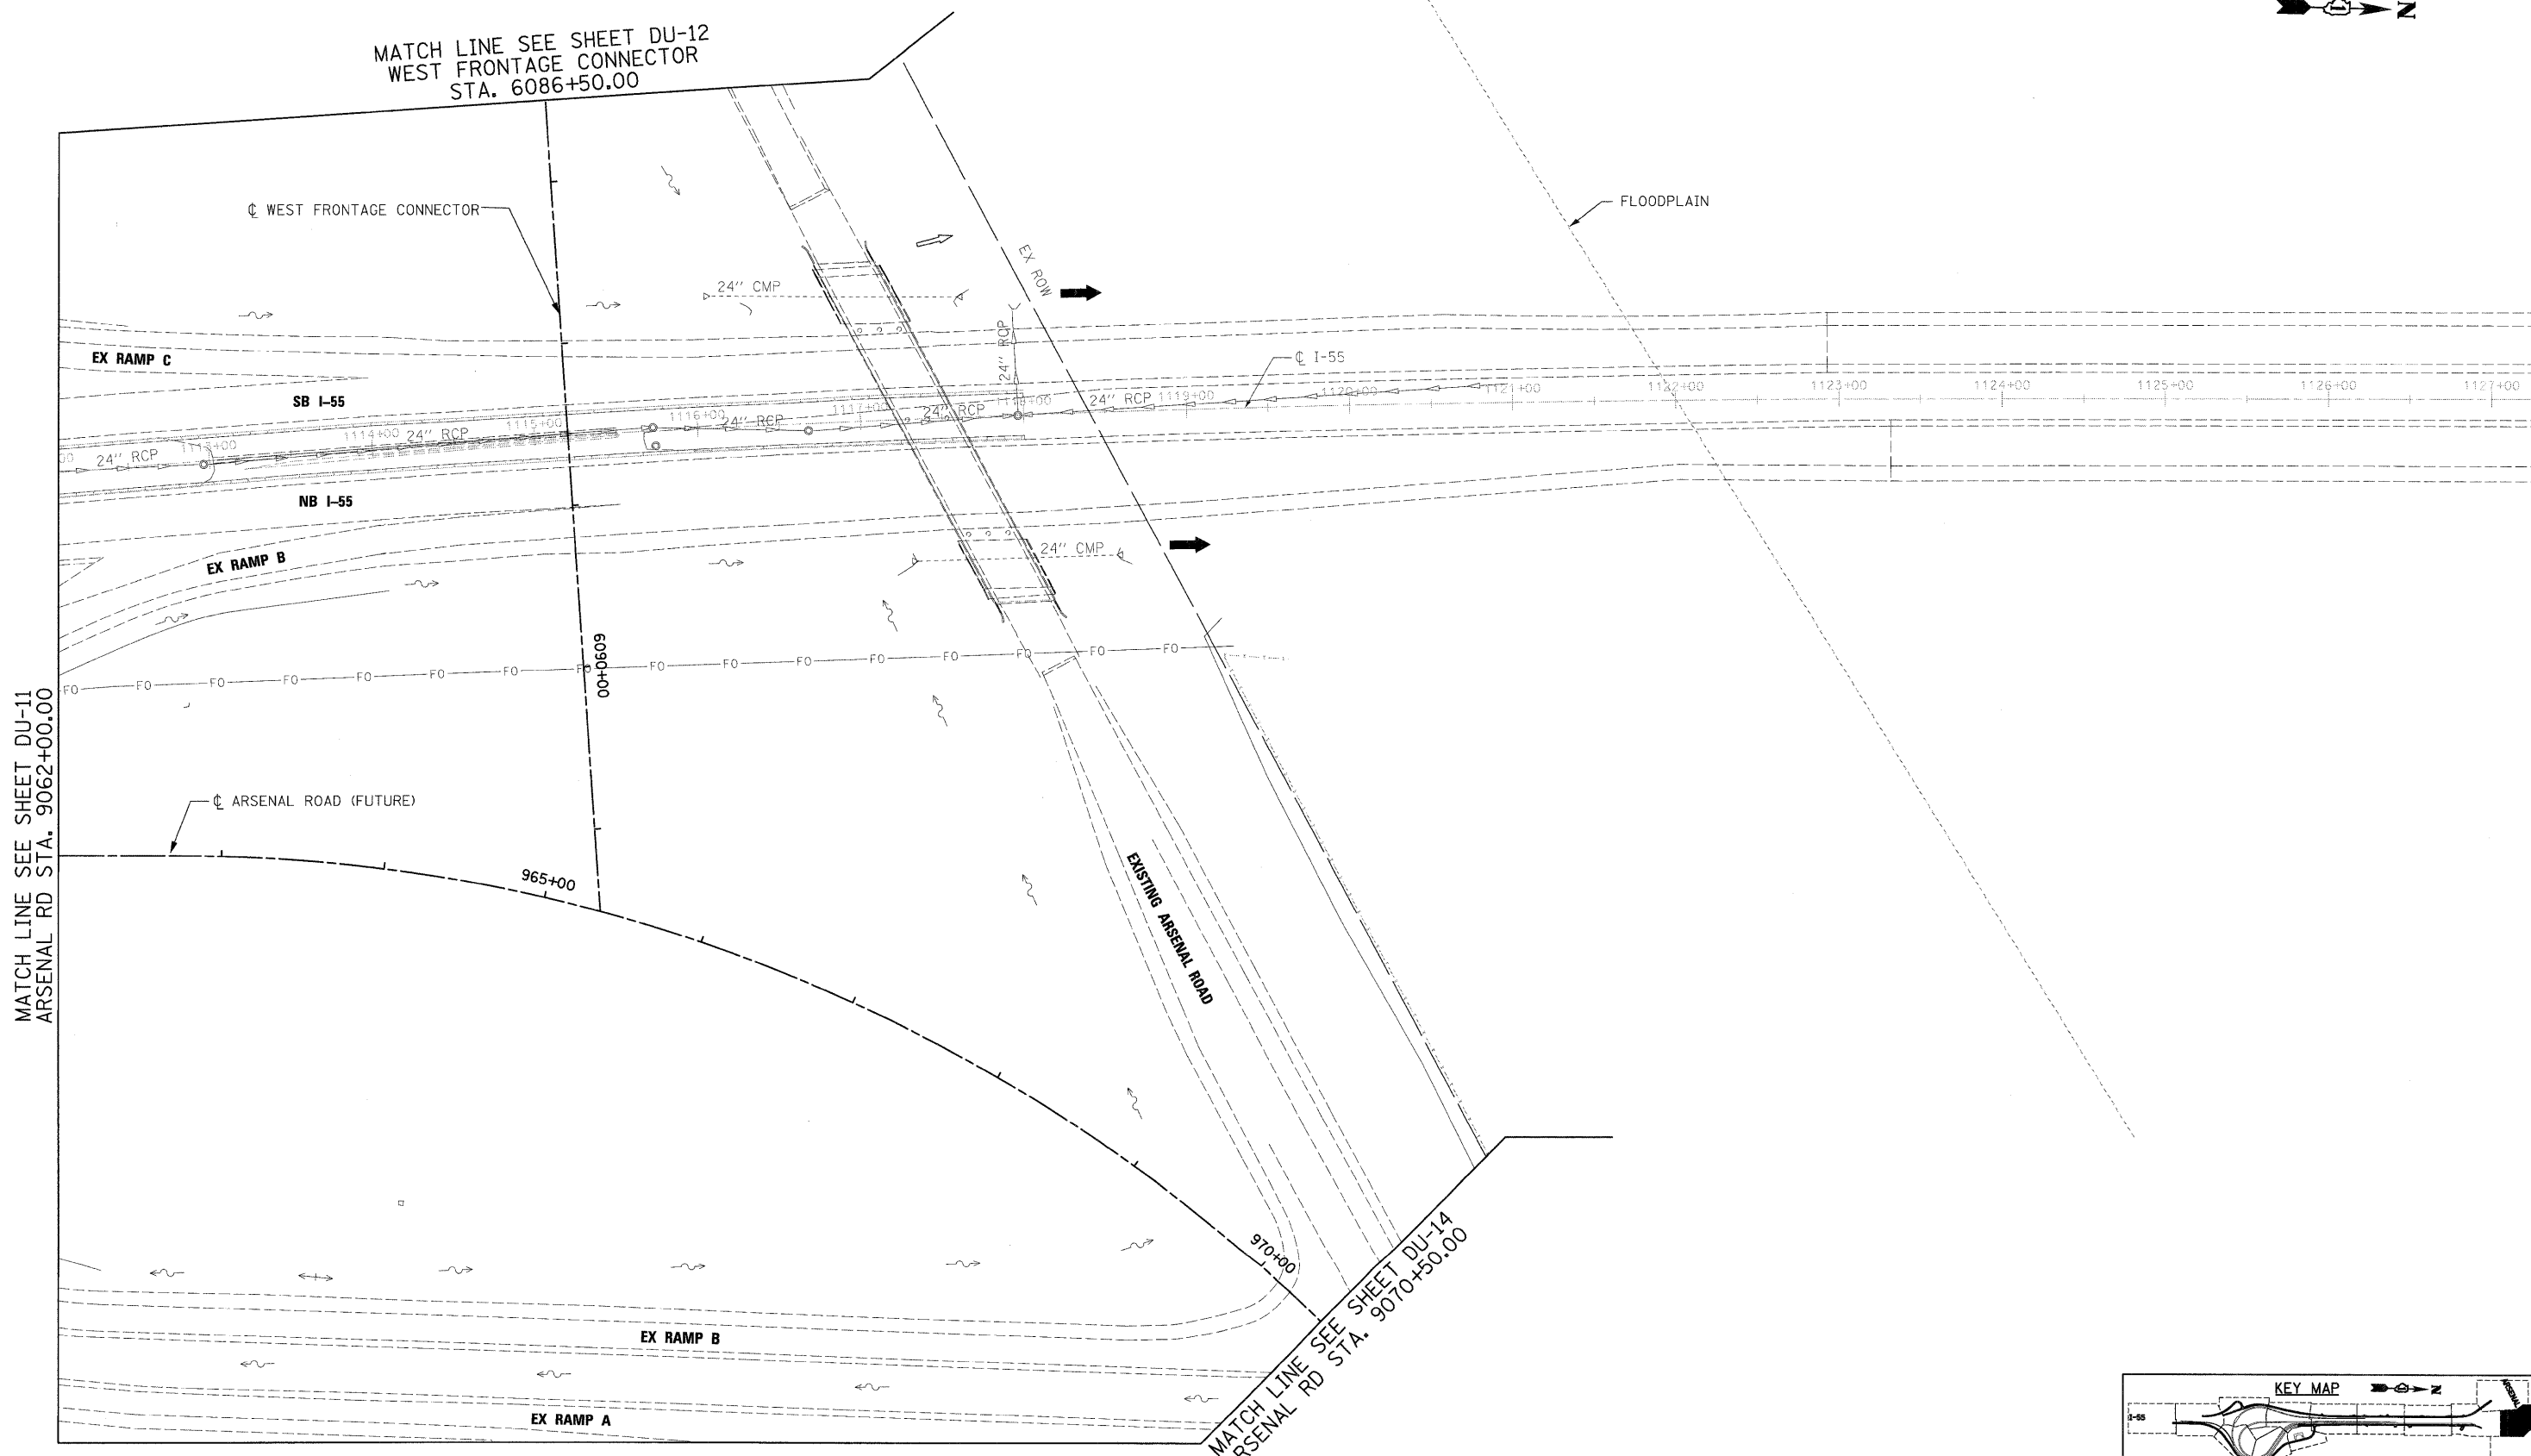

MATCH LINE SEE SHEET DU-11  
ARSENAL RD STA. 9062+00.00

MATCH LINE SEE SHEET DU-14  
ARSENAL RD STA. 9070+50.00

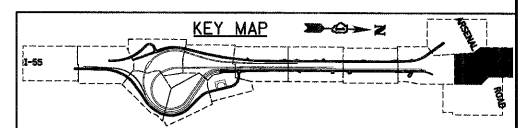

**SINGH**  
SINGH & ASSOCIATES, INC.  
CONSULTING ENGINEERS

300 W. ADAMS ST.  
CHICAGO, IL 60606  
TEL: (312) 629-0240  
FAX: (312) 629-8449

FILE NAME = D160C31-SHT-DRAIN13.dgn	USER NAME = TK\leg1	DESIGNED - VP/PTK	REVISED -
		DRAWN - VP/PTK	REVISED -
		CHECKED - CL	REVISED -
		DATE - 12/18/09	REVISED -

**STATE OF ILLINOIS  
DEPARTMENT OF TRANSPORTATION**

**DRAINAGE AND UTILITY PLAN**

SCALE: 1"=50' SHEET NO. 13 OF 22 SHEETS STA. TO STA.

F.A.I. RTE.	SECTION	COUNTY	TOTAL SHEETS	SHEET NO.
55	(99-1&2)AC-3	WILL	524	156
CONTRACT NO. 60C31			FED. ROAD DIST. NO. 1 ILLINOIS FED. AID PROJECT	

**FINAL**