


STATE OF ILLINOIS
DEPARTMENT OF TRANSPORTATION

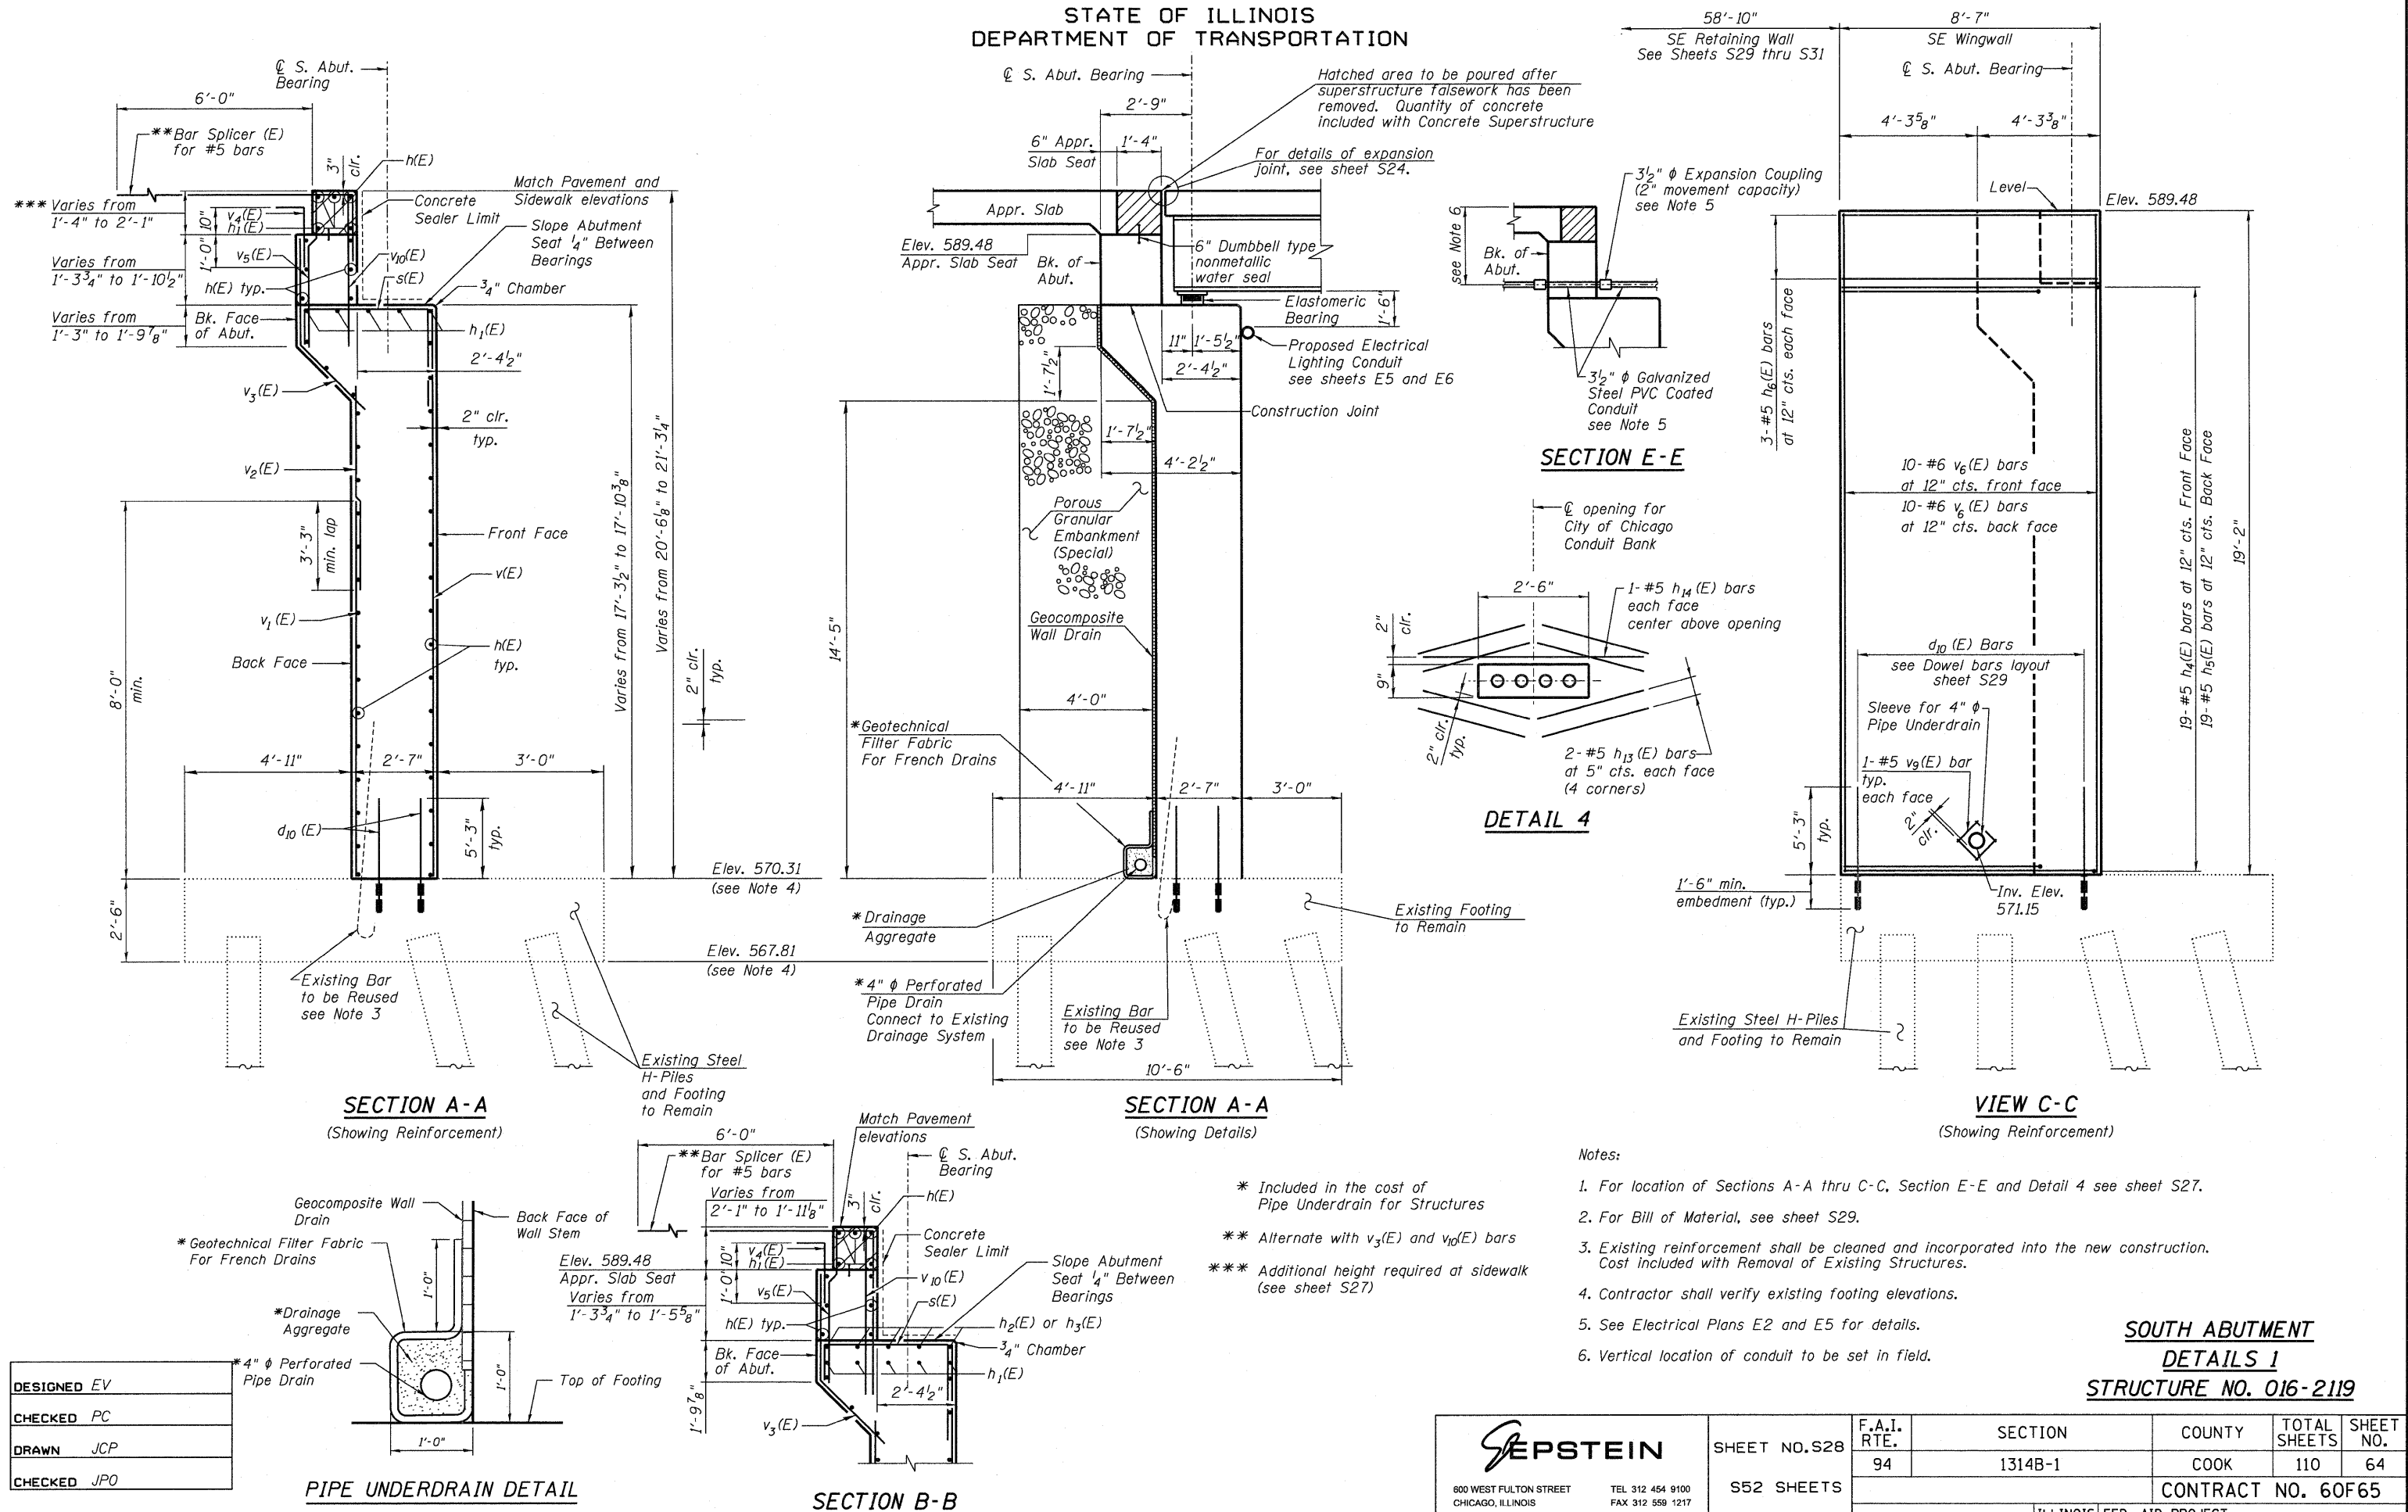

Notes:

1. For location of Sections A-A thru C-C, Section E-E and Detail 4 see sheet S27.
2. For Bill of Material, see sheet S29.
3. Existing reinforcement shall be cleaned and incorporated into the new construction. Cost included with Removal of Existing Structures.
4. Contractor shall verify existing footing elevations.
5. See Electrical Plans E2 and E5 for details.
6. Vertical location of conduit to be set in field.

**SOUTH ABUTMENT
DETAILS 1
STRUCTURE NO. 016-2119**

DESIGNED	EV
CHECKED	PC
DRAWN	JCP
CHECKED	JPO

SEPSTEIN

600 WEST FULTON STREET
CHICAGO, ILLINOIS
60661-1259

TEL 312 454 9100
FAX 312 558 1217
WEB www.epsteinglobal.com

SHEET NO. S28
S52 SHEETS

F.A.I. RTE.	SECTION	COUNTY	TOTAL SHEETS	SHEET NO.
94	1314B-1	COOK	110	64
CONTRACT NO. 60F65				
ILLINOIS FED. AID PROJECT				

8/9/2010 7:53:02 PM P:\Projects\0600029225 - IDOT\PTB\152CAD\CAD\DD Sheets\Bridge Phase 2\0161243-028-SouthAbut.Dwg