
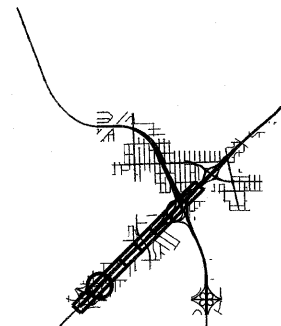
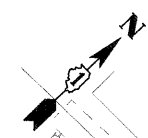


MATCHLINE STA. 1174+50.00

MATCHLINE STA. 1189+00.00

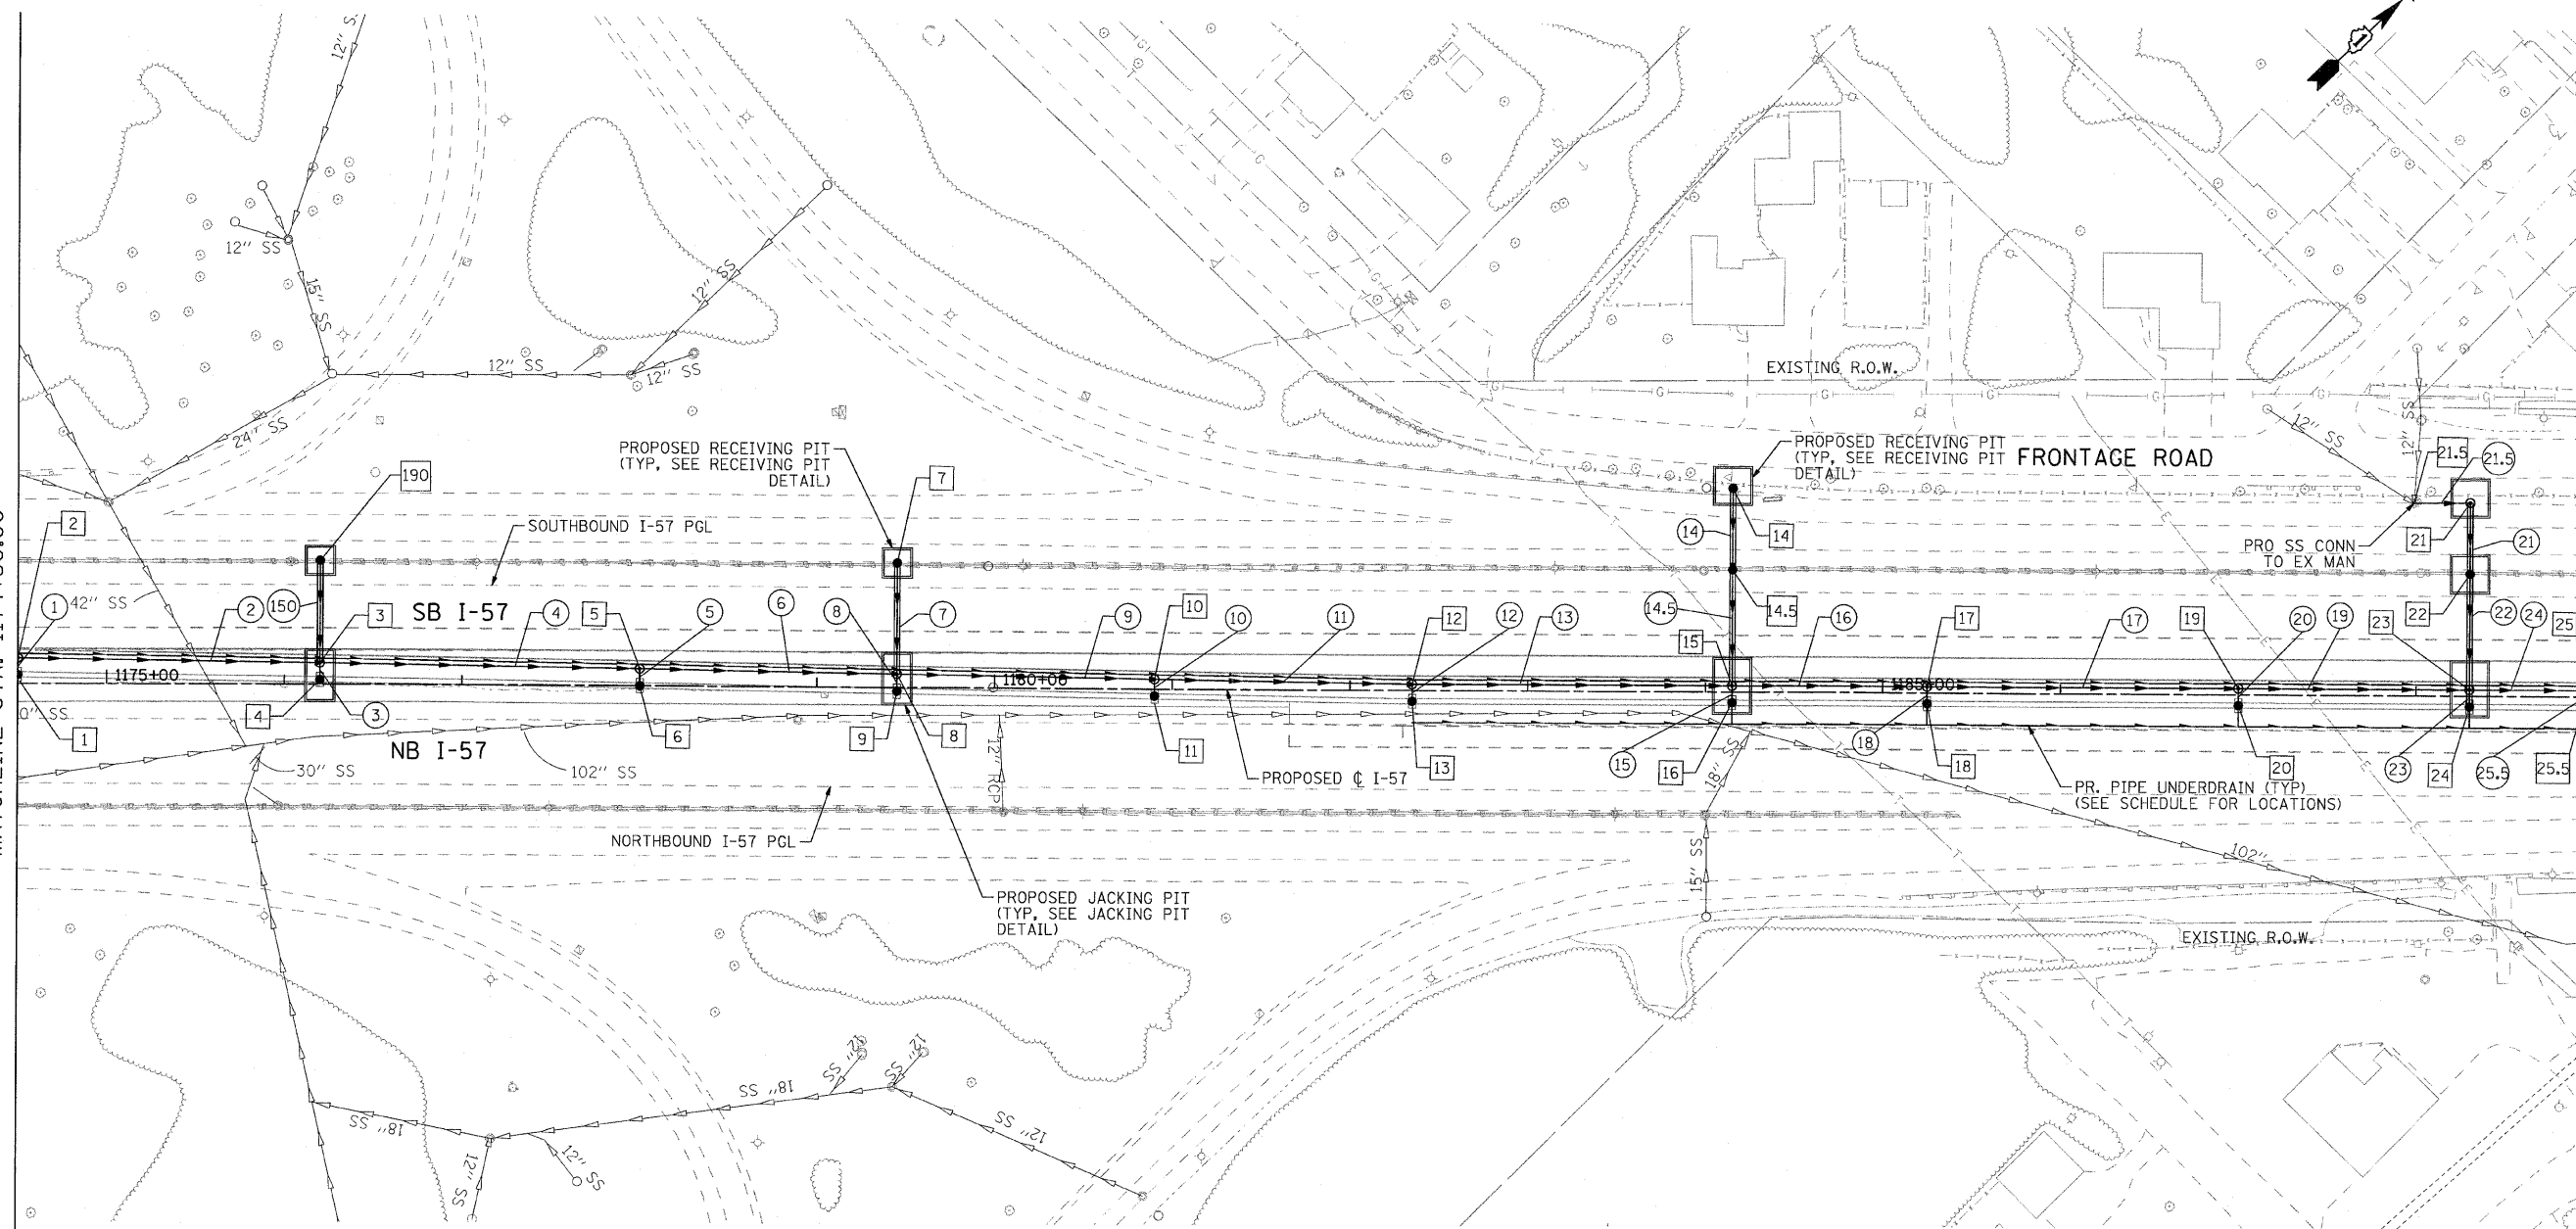

SCALE: 1" = 50'-0"

COMPANY NAME: SEC GROUP, INC.  
 PROJECT CONTACT: T. HAMILTON  
 CLIENT: ILLINOIS DEPARTMENT OF TRANSPORTATION  
 DATE PLOTTED: 4/23/2010 10:26:21 AM  
 FILE NAME: PLPP\_SHT02.dgn  
 PLOT SCALE: 1"=50'  
 PEN TABLE: standard-trans.tbl

**SEC Group, Inc.**  
 An IFS Group Company  
 401 N. First Street  
 Moline, IL 60250-2138  
 T 815.308.1778 F 815.308.1781  
 www.secgroup.com  
 \*Moline, IL \*Rockford, IL \*New London, IL \*Chicago, IL

USER NAME = JAttane	DESIGNED - A. JAIN	REVISED - 4/29/2010
FILE NAME = PLPP_SHT02.dgn	DRAWN - J. ATTANASEO	REVISED -
PLOT SCALE = 1:50	CHECKED - T. HAMILTON	REVISED -
PLOT DATE = 4/23/2010	DATE - 4/23/10	REVISED -

**STATE OF ILLINOIS  
 DEPARTMENT OF TRANSPORTATION**

**I-294 AT I-57 INTERCHANGE PROJECT  
 PROPOSED DRAINAGE PLAN - I-57**

SCALE: 1"=50' SHEET NO. 2 OF 9 SHEETS STA. 1174+50.00 TO STA. 1189+00.00

F.A.I. RTE.	SECTION	COUNTY	TOTAL SHEETS	SHEET NO.
57	1414.2B	COOK	516	138
CONTRACT NO. 60J27				
FED. ROAD DIST. NO. [ILLINOIS] FED. AID PROJECT				