 



MATCHLINE STA. 1232+50.00

MATCHLINE STA. 1247+00.00

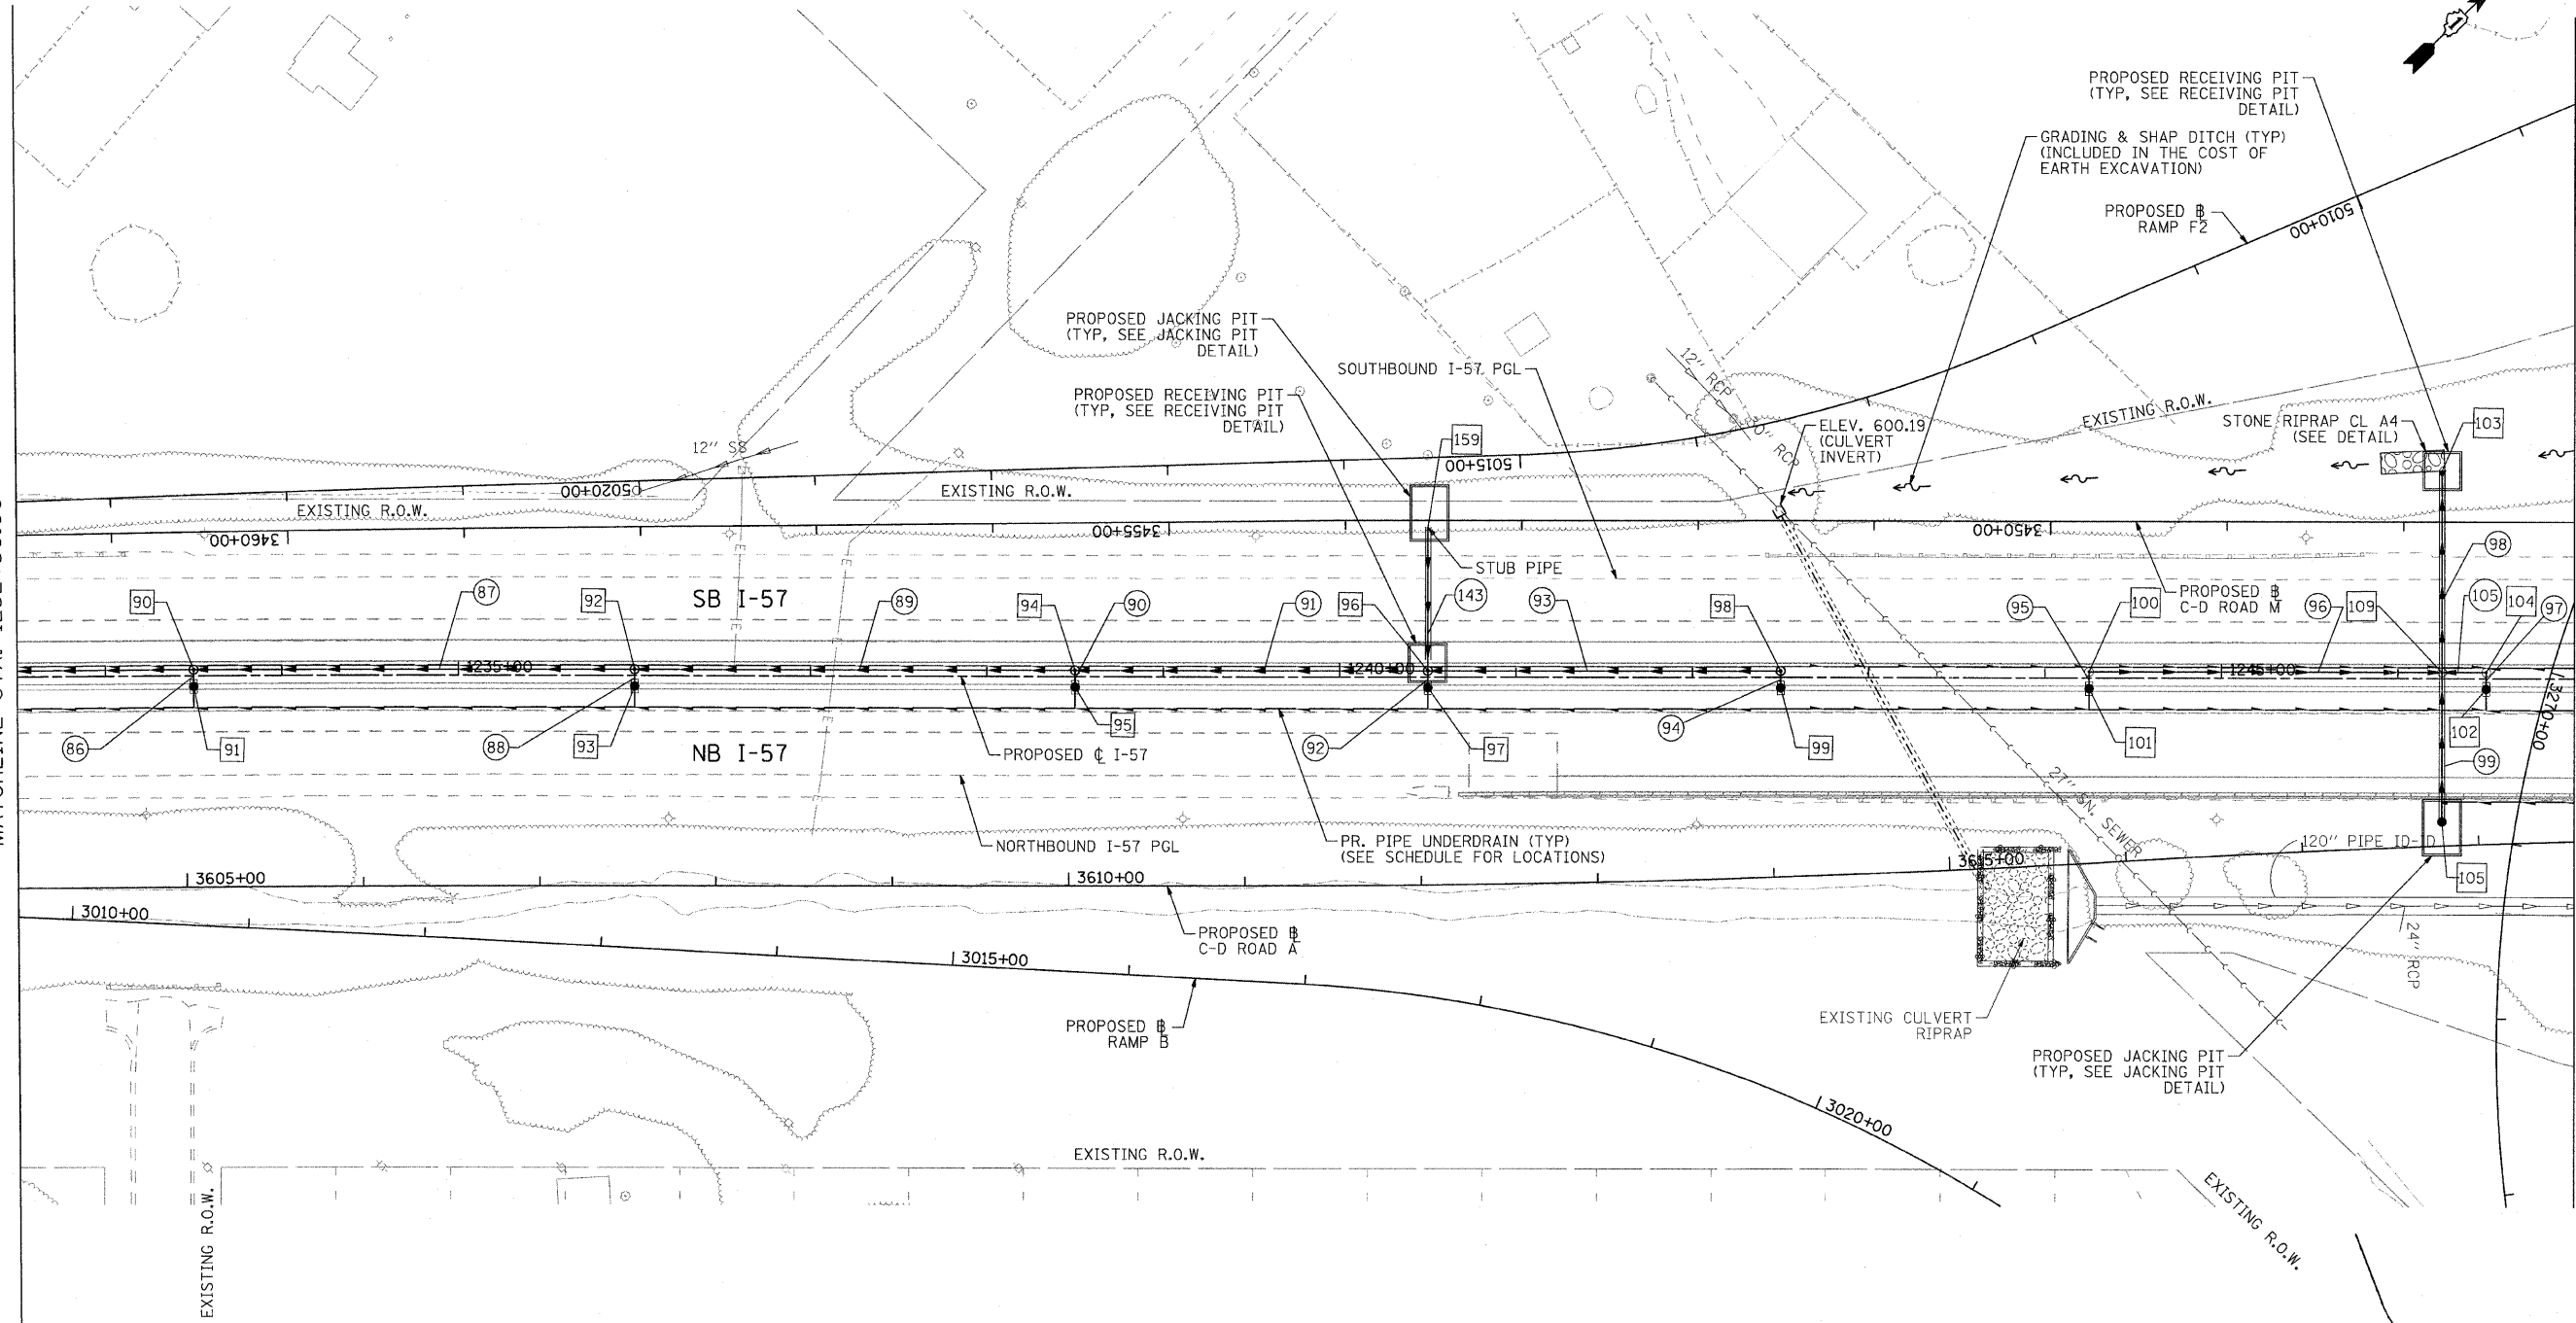

SEC GROUP, INC.
 PROJECT CONTACT: ILLINOIS DEPARTMENT OF TRANSPORTATION
 CLIENT: ILLINOIS DEPARTMENT OF TRANSPORTATION
 DATE PLOTTED: 4/23/2010 10:59:30 AM
 FILE NAME: PLPP_SHT06.dgn
 PLOT DRIVER: pdfplot
 PEN TABLE: standard-trans.tbl

SEC Group, Inc.
 An IBM Group Company
 400 N. First Street
 McKinstry, IL 60059-2138
 1.815.385.1778 | 1.815.385.1984
 www.secgroup.com

USER NAME = JAttanasio
FILE NAME = PL_PP_SHT06.dgn
PLOT SCALE = 1:50
PLOT DATE = 4/23/2010

DESIGNED - A. JAIN
DRAWN - J. ATTANASEO
CHECKED - T. HAMILTON
DATE - 4/23/10

REVISED - 4/29/2010
REVISED -
REVISED -
REVISED -

**STATE OF ILLINOIS
 DEPARTMENT OF TRANSPORTATION**

I-294 AT I-57 INTERCHANGE PROJECT PROPOSED DRAINAGE PLAN - I-57			
SCALE: 1"=50'	SHEET NO. 6 OF 9 SHEETS	STA. 1232+50.00 TO STA. 1247+00.00	

F.A.I. RTE.	SECTION	COUNTY	TOTAL SHEETS	SHEET NO.
57	1414.2B	COOK	516	142
CONTRACT NO. 60J27				
FED. ROAD DIST. NO. ILLINOIS FED. AID PROJECT				