

 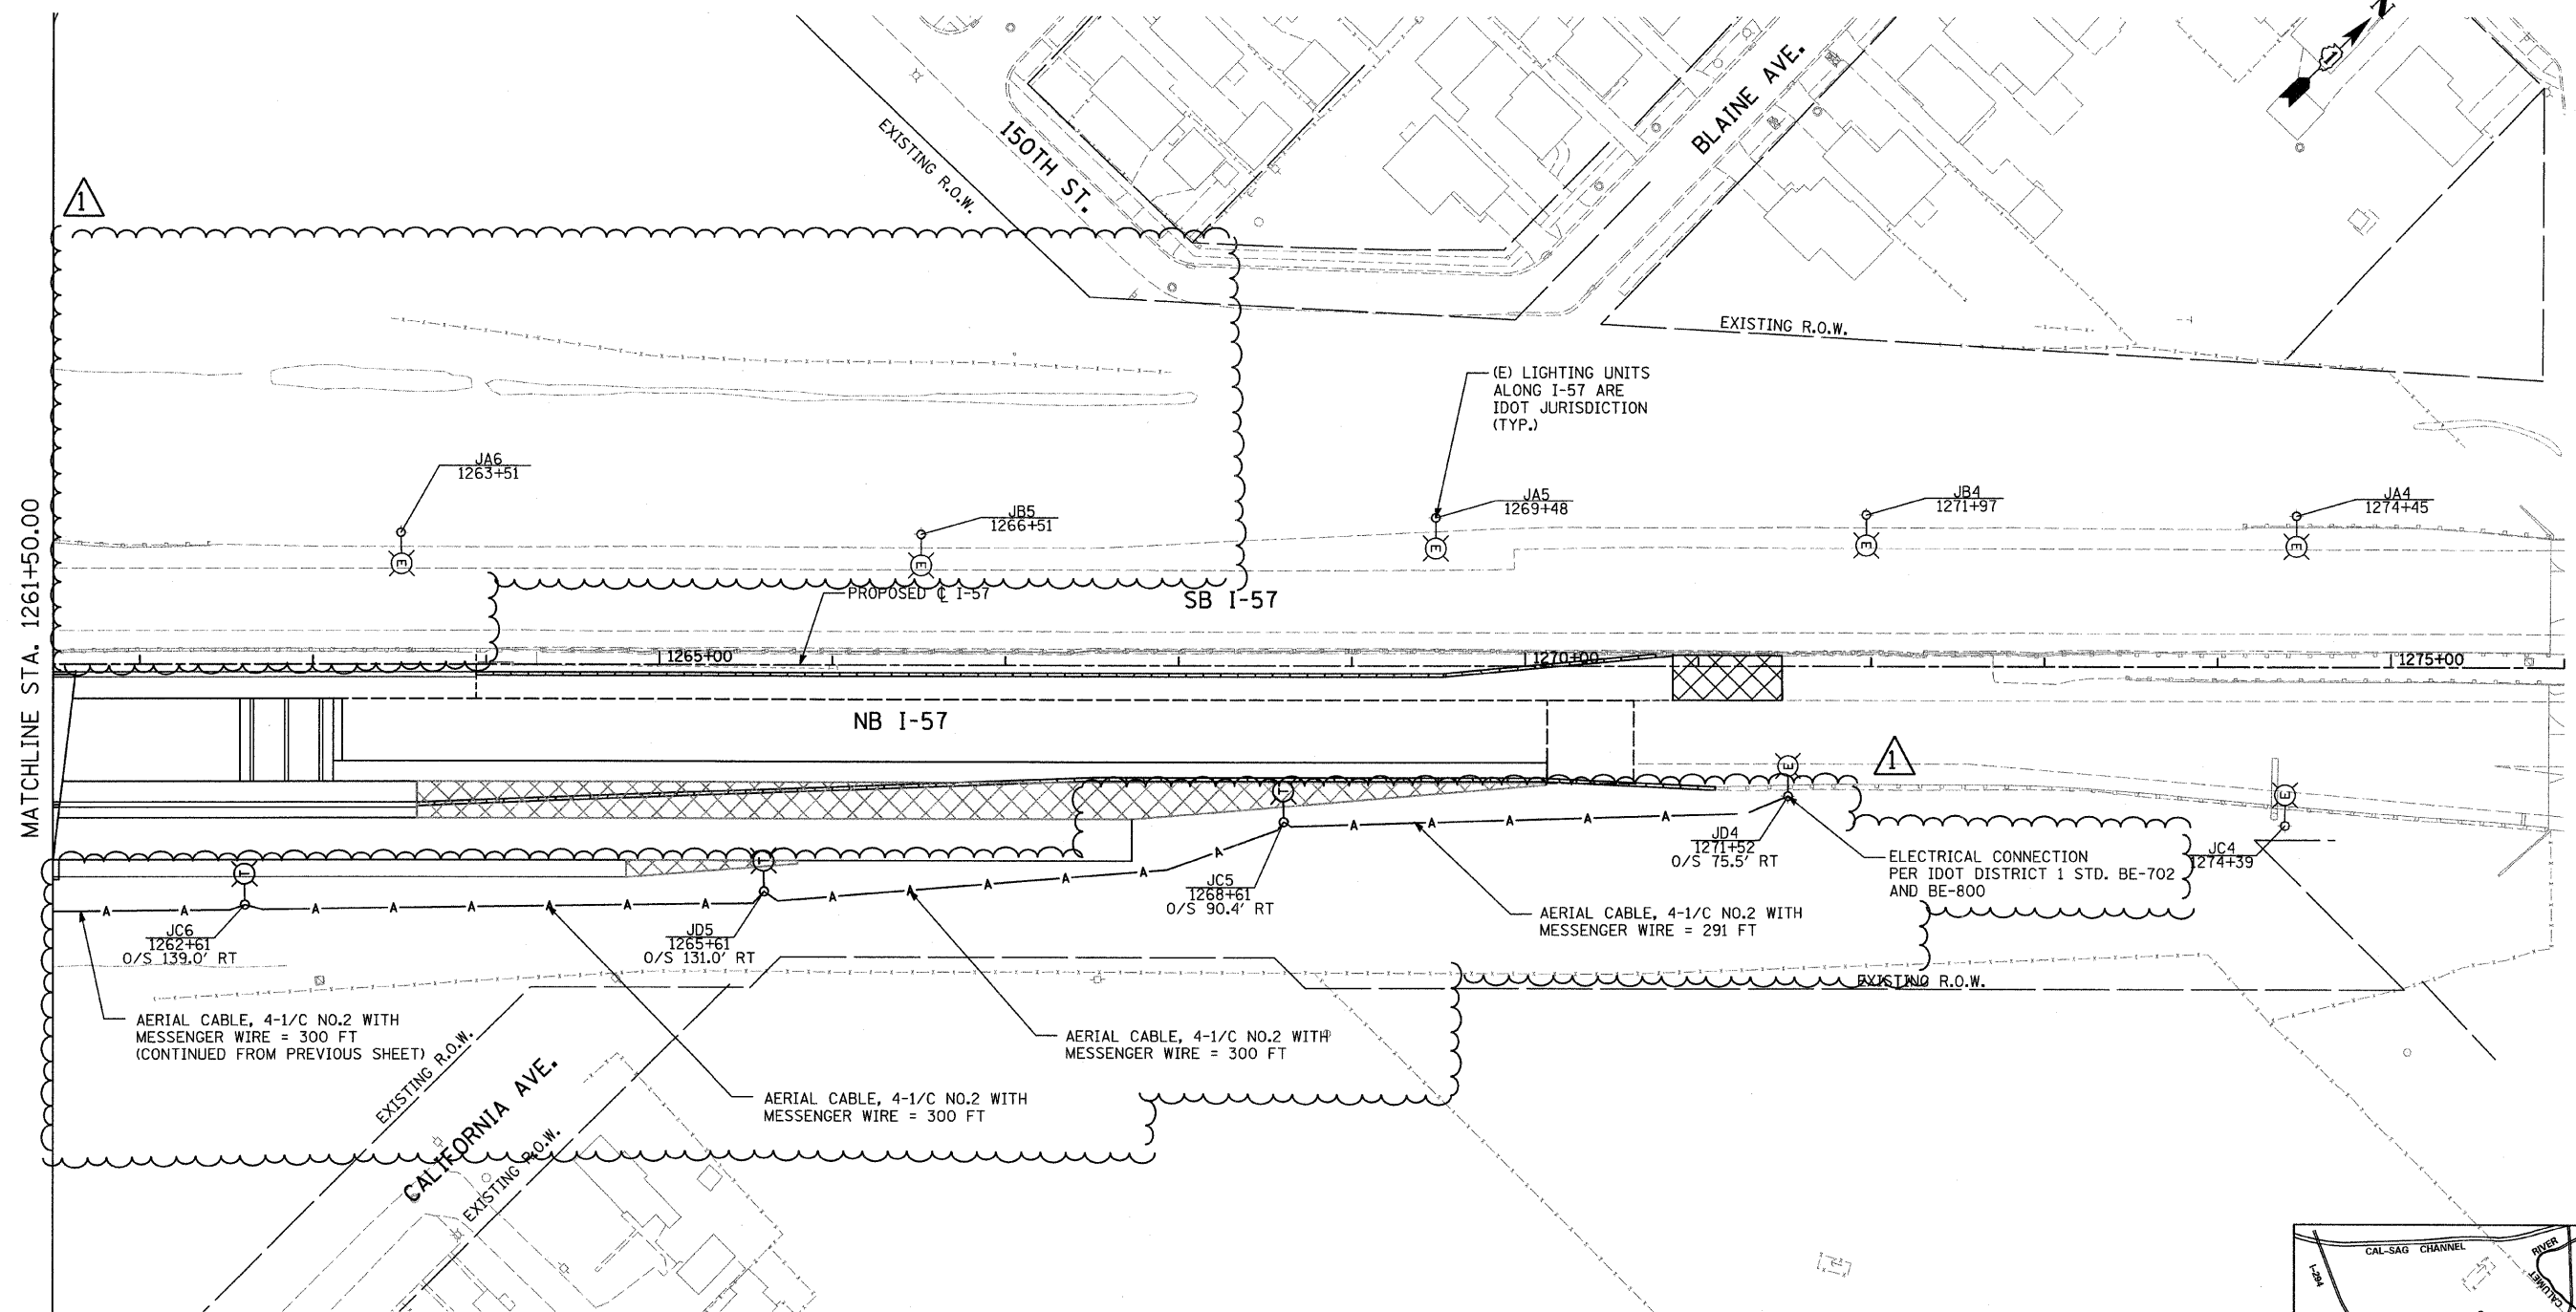
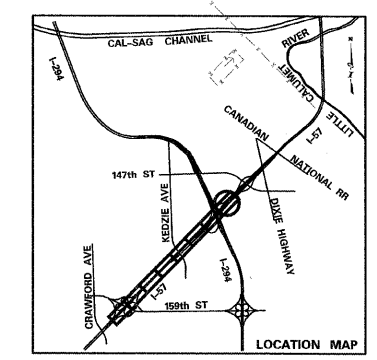


I:\602540(57-294)\road\elec\PI_PR_LGT_SHT08.dwg
 5/24/2010 9:41:38 AM



NOTES:

1. IDOT LIGHTING CONTROLLER "K" IS LOCATED AT I-57 STA. 1238+45 ALONG SB I-57.
2. IDOT LIGHTING CONTROLLER "J" IS LOCATED AT I-57 STA. 1286+79 ALONG NB I-57 ON 147TH STREET.

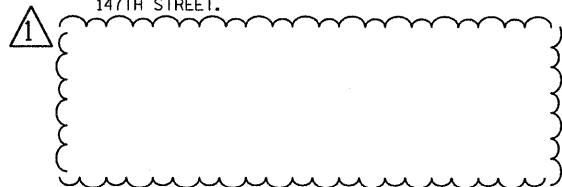

SHEET E8

TYLIN INTERNATIONAL	USER NAME =	DESIGNED - JDF	REVISED Δ - ADDENDUM 1 05/24/10
	PLOT SCALE =	DRAWN - JDF	REVISED -
	PLOT DATE =	CHECKED - DAJ	REVISED -
		DATE - 3/18/2010	REVISED -

STATE OF ILLINOIS
DEPARTMENT OF TRANSPORTATION

I-57 AT I-294 INTERCHANGE PROJECT
PROPOSED STAGE 2 TEMPORARY LIGHTING PLANS - I-57

SCALE: SHEET NO. 3 OF 4 SHEETS STA. 1261+50 TO STA. 1276+00

F.A.I. RTE. 57	SECTION 1414.2B	COUNTY COOK	TOTAL SHEETS 516	SHEET NO. 208
FED. ROAD DIST. NO.		ILLINOIS FED. AID PROJECT		
		CONTRACT NO. 60J27		