



**TYPICAL SPLICE DETAIL**

N.T.S.

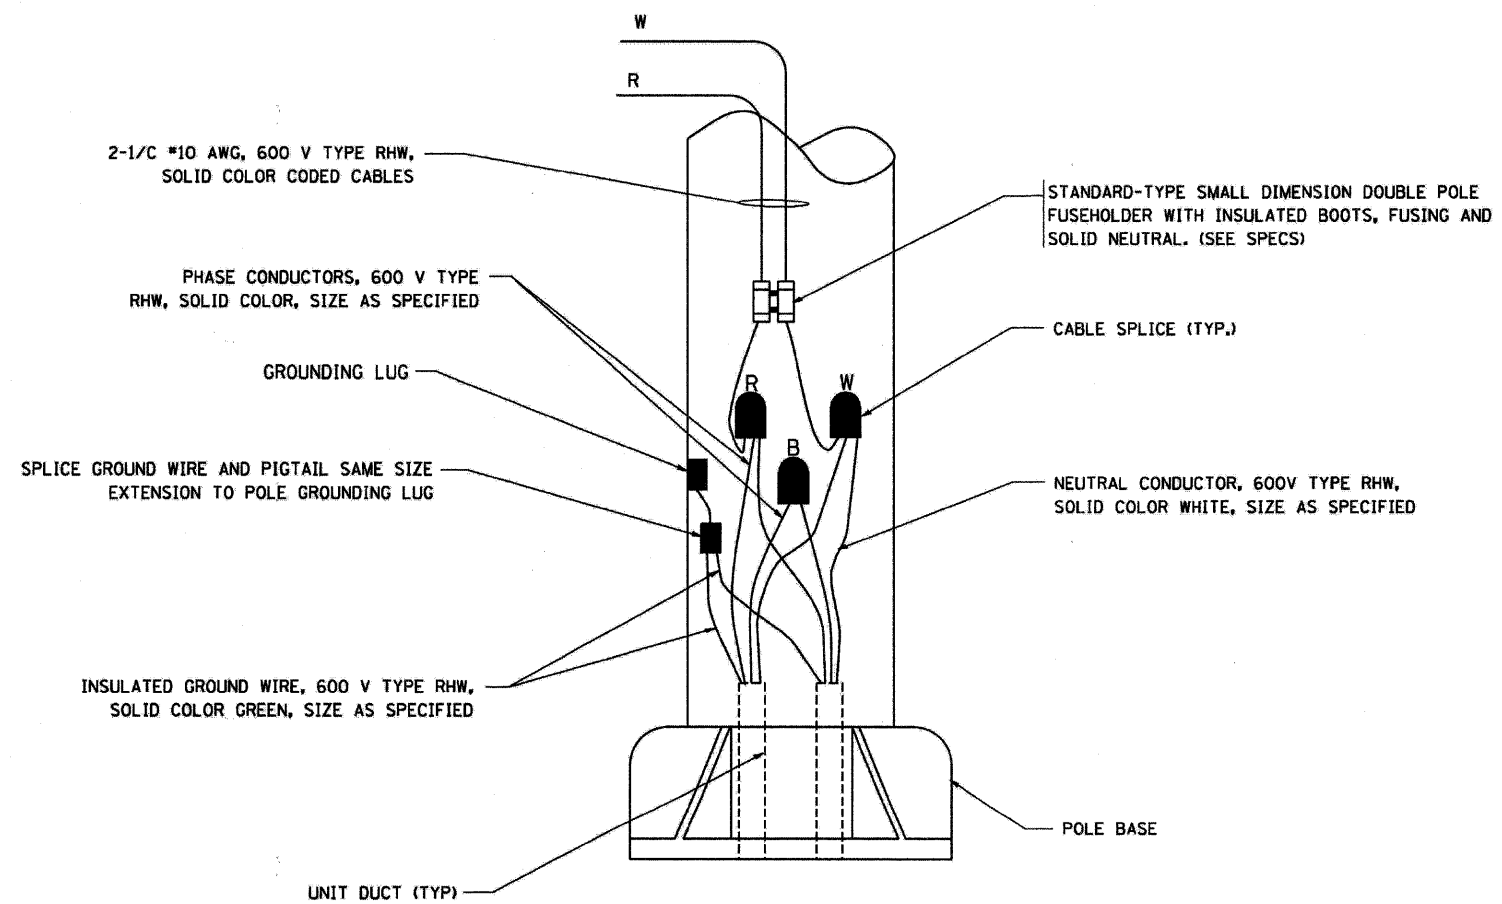

**POLE WIRING DETAIL**

N.T.S.

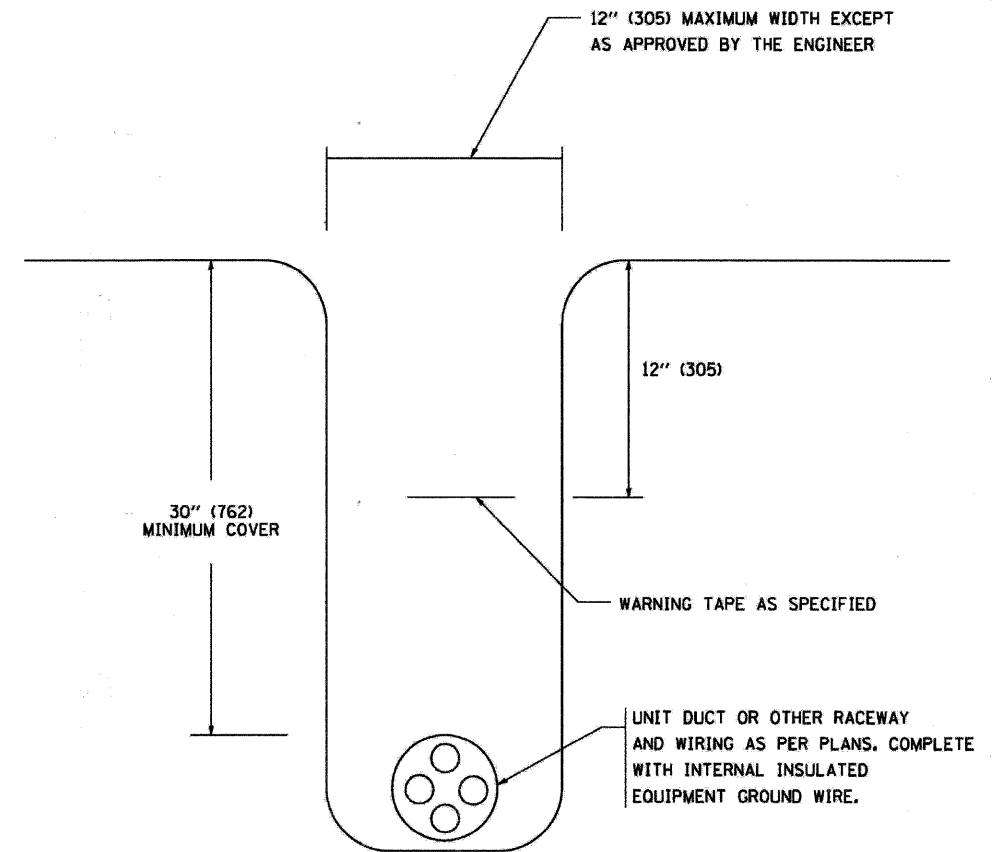

**TYPICAL WIRING IN TRENCH DETAIL**

N.T.S.

FILE NAME = W:\distatd\22x34\be782.dgn	USER NAME = gaglienobt	DESIGNED -	REVISED - 08-08-03	<b>STATE OF ILLINOIS DEPARTMENT OF TRANSPORTATION</b>	<b>MISC. ELECTRICAL DETAILS SHEET A</b>			F.A. U. RTE.	SECTION	COUNTY	TOTAL SHEETS	SHEET NO.
	PLOT SCALE = 50.000' / IN.	CHECKED -	REVISED -					2652	00-00070-00-PV	DuPAGE	160	85
	PLOT DATE = 1/4/2008	DATE -	REVISED -		SCALE: NONE SHEET NO. 1 OF 1 SHEETS STA. 63+19.78 TO STA. 116+71.35			BE-702		CONTRACT NO. 63379		
								FED. ROAD DIST. NO. 1 ILLINOIS FED. AID PROJECT				