 



NOTE:
1. SEE TRAFFIC SIGNAL PLANS FOR EXACT LOCATION OF COMBINATION POLE.

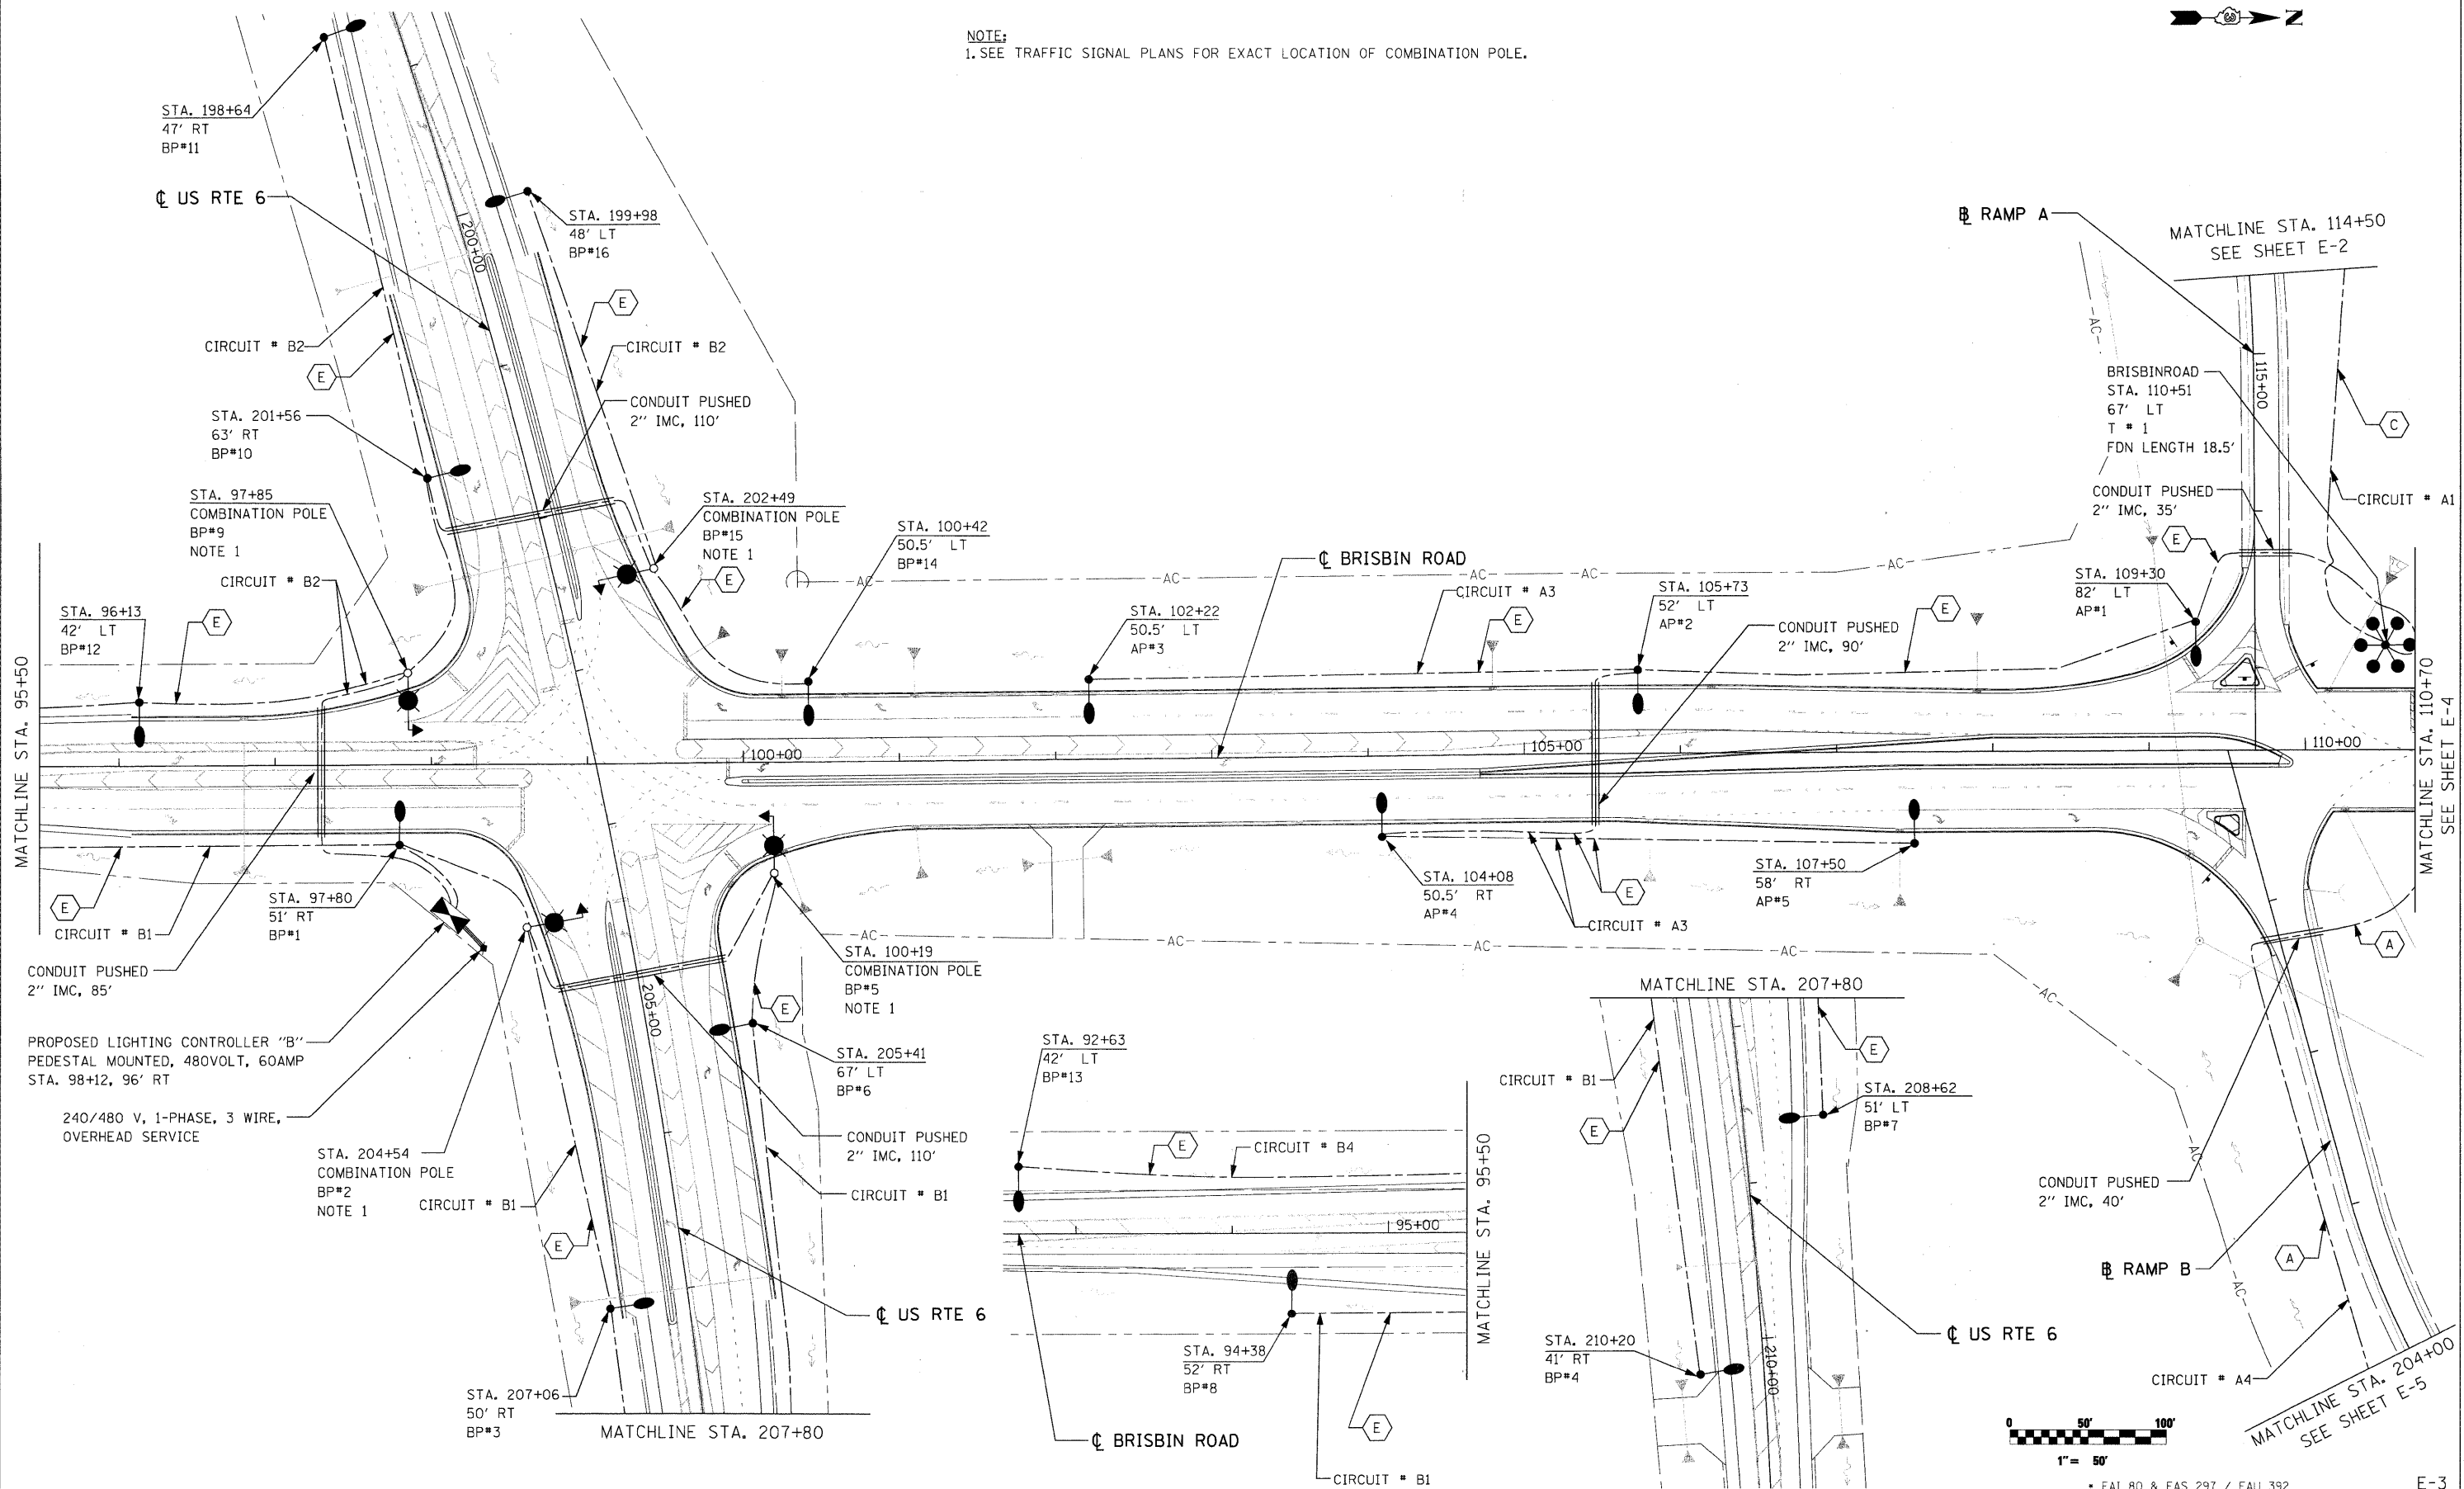

* FAI 80 & FAS 297 / FAU 392

E-3

FILE NAME ...D366408-shr-Ltght2.dgn	USER NAME =	DESIGNED - RDP/JH	REVISED -
		DRAWN - RDP	REVISED -
		CHECKED - JH/JDM	REVISED -
		DATE - 04/30/2010	REVISED -

**STATE OF ILLINOIS
DEPARTMENT OF TRANSPORTATION**

ROADWAY LIGHTING PLAN	
PROJECT 91-034-07/91-153-80	JOB NO. D-93-011-04
SCALE: 1"=50'	SHEET NO. 3 OF 15 SHEETS STA. 95+50 TO STA. 110+70

F.A.U. RTE.	SECTION	COUNTY	TOTAL SHEETS	SHEET NO.
*	(32,47-4) HBK-4 & (GN)	GRUNDY	351	169
CONTRACT NO. 66408				
FED. ROAD DIST. NO.		ILLINOIS FED. AID PROJECT		