
 


- ⑳ STA 43+70.00, 36.69' LT
PROPOSED INLETS, TYPE A
W/ TYPE 3V FRAME AND GRATE
PIPE DRAINS, 15"
METAL END SECTIONS, 15"
GR ELEV 593.26
FL ELEV 590.93
15" OUT 591.10
- ㉑ STA 44+00.00, 48.69' RT
PROPOSED INLETS, TYPE A
W/ TYPE 3V FRAME AND GRATE
PIPE DRAINS, 15"
METAL END SECTIONS, 15"
GR ELEV 593.62
FL ELEV 591.29
15" OUT 591.46
- ㉒ STA 46+25.00, 36.69' LT
PROPOSED INLETS, TYPE A
W/ TYPE 3V FRAME AND GRATE
PIPE DRAINS, 15"
METAL END SECTIONS, 15"
GR ELEV 598.36
FL ELEV 596.03
15" OUT 596.20
- ㉓ STA 46+50.00, 36.69' RT
PROPOSED INLETS, TYPE A
W/ TYPE 3V FRAME AND GRATE
PIPE DRAINS, 15"
METAL END SECTIONS, 15"
GR ELEV 598.86
FL ELEV 596.53
15" OUT 596.70
- ㉔ STA 48+00.00, 36.69' LT
PROPOSED INLETS, TYPE A
W/ TYPE 3V FRAME AND GRATE
PIPE DRAINS, 15"
METAL END SECTIONS, 15"
CONCRETE THRUST BLOCKS
CONCRETE ANCHORS
GR ELEV 601.86
FL ELEV 599.53
15" OUT 599.70
- ㉕ STA 48+00.00, 36.69' RT
PROPOSED INLETS, TYPE A
W/ TYPE 3V FRAME AND GRATE
PIPE DRAINS, 15"
METAL END SECTIONS, 15"
CONCRETE THRUST BLOCKS
CONCRETE ANCHORS
GR ELEV 601.86
FL ELEV 599.53
15" OUT 599.70

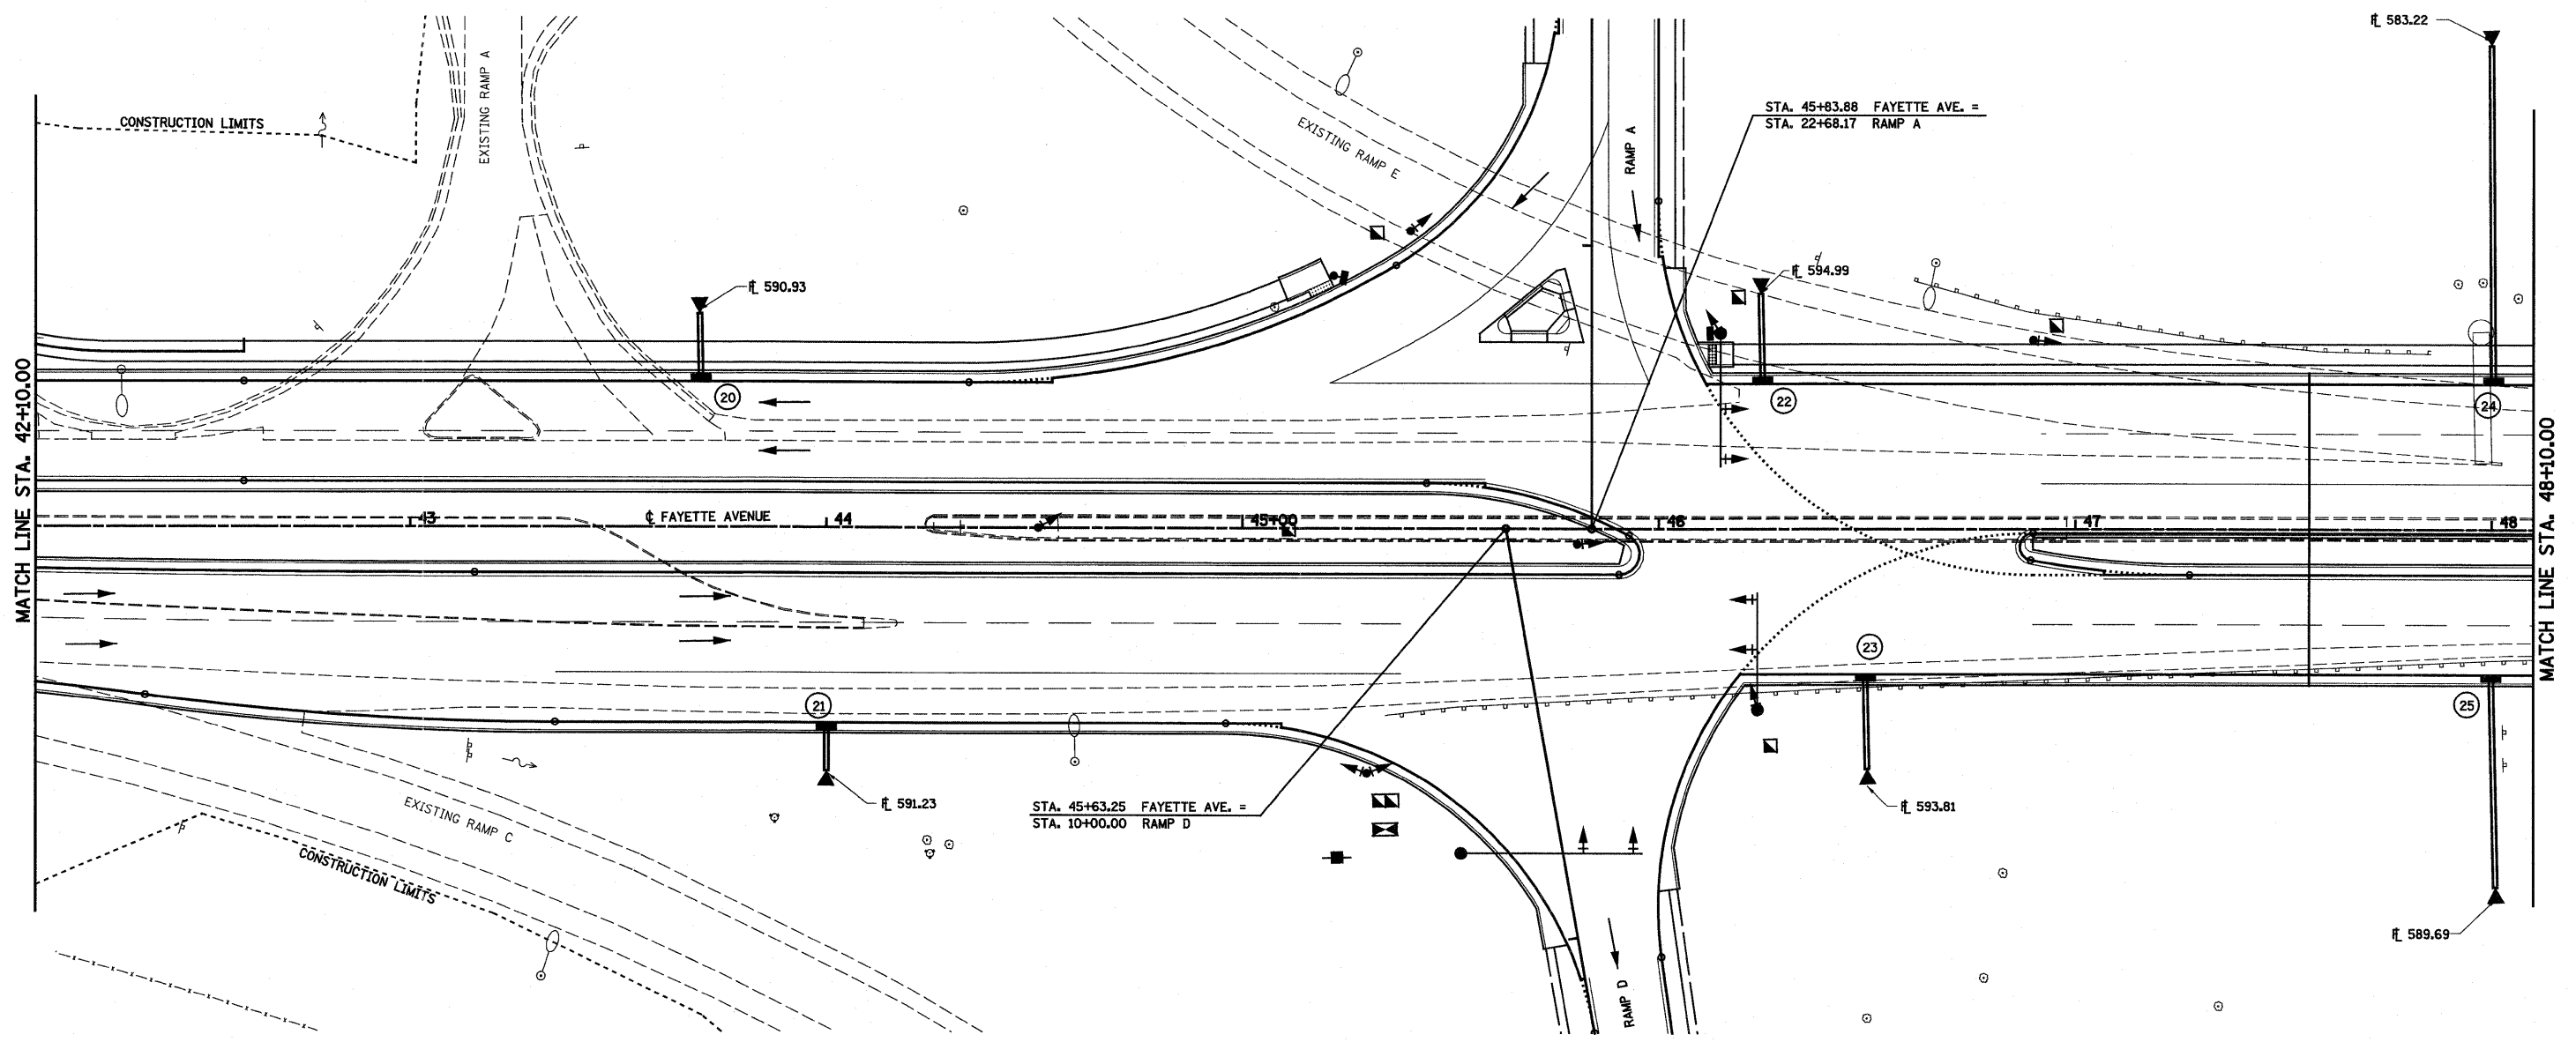

NOTE:
ALL PIPES ENTER AND EXIT STRUCTURE
AT STRUCTURE FLOW LINE ELEVATION
UNLESS OTHERWISE NOTED.



FILE NAME =	USER NAME = paul	DESIGNED - JWS	REVISED -	STATE OF ILLINOIS DEPARTMENT OF TRANSPORTATION	DRAINAGE PLAN, FAYETTE AVENUE	F.A.T RTE.	SECTION	COUNTY	TOTAL SHEETS	SHEET NO.	
S:\Projects\403-00072-57-70\dgn\Fayette\drn_plandgn		DRAWN - PDB	REVISED -			57/70	(25-3)I-6	EFFINGHAM	839	156	
	PLOT SCALE = 40.0000' / IN.	CHECKED - BRM	REVISED -			SCALE: 1"=20'		SHEET NO. 2 OF 8 SHEETS		STA. 42+10.00 TO STA. 48+10.00	
	PLOT DATE = 6/24/2010	DATE - 11-05-07	REVISED -			FED. ROAD DIST. NO.		ILLINOIS FED. AID PROJECT		CONTRACT NO. 74293	