
 




- 30 STA 55+00.00, 48.69' LT PROPOSED INLETS, TYPE A W/ TYPE 3V FRAME AND GRATE PIPE DRAINS, 15" METAL END SECTIONS, 15" GR ELEV 597.11 FL ELEV 594.78 15" OUT 594.95
- 30A STA 56+50.00, 48.69' LT PROPOSED INLETS, TYPE A W/ TYPE 3V FRAME AND GRATE PIPE DRAINS, 15" METAL END SECTIONS, 15" GR ELEV 594.48 FL ELEV 592.15 15" OUT 592.32
- 31 STA 55+00.00, 41.29' RT PROPOSED INLETS, TYPE A W/ TYPE 3V FRAME AND GRATE PIPE DRAINS, 15" METAL END SECTIONS, 15" GR ELEV 597.34 FL ELEV 595.01 15" OUT 595.18
- 32 STA 57+50.00, 47.45' LT PROPOSED INLETS, TYPE A W/ TYPE 3V FRAME AND GRATE PIPE DRAINS, 15" METAL END SECTIONS, 15" GR ELEV 592.76 FL ELEV 590.43 15" OUT 590.60
- 32A STA 59+00.00, 38.45' LT PROPOSED INLETS, TYPE A W/ TYPE 3V FRAME AND GRATE PIPE DRAINS, 15" METAL END SECTIONS, 15" GR ELEV 590.31 FL ELEV 587.98 15" OUT 588.15
- 33 STA 57+50.00, 36.69' RT PROPOSED INLETS, TYPE A W/ TYPE 3V FRAME AND GRATE PIPE DRAINS, 15" METAL END SECTIONS, 15" GR ELEV 592.97 FL ELEV 590.64 15" OUT 590.81
- 34 STA 60+00.00, 35.64' LT PROPOSED INLETS, TYPE A W/ TYPE 3V FRAME AND GRATE PIPE DRAINS, 15" METAL END SECTIONS, 15" GR ELEV 588.84 FL ELEV 586.51 15" OUT 586.68
- 35 STA 60+00.00, 36.69' RT PROPOSED INLETS, TYPE A W/ TYPE 3V FRAME AND GRATE PIPE DRAINS, 15" METAL END SECTIONS, 15" GR ELEV 588.83 FL ELEV 586.50 15" OUT 586.67

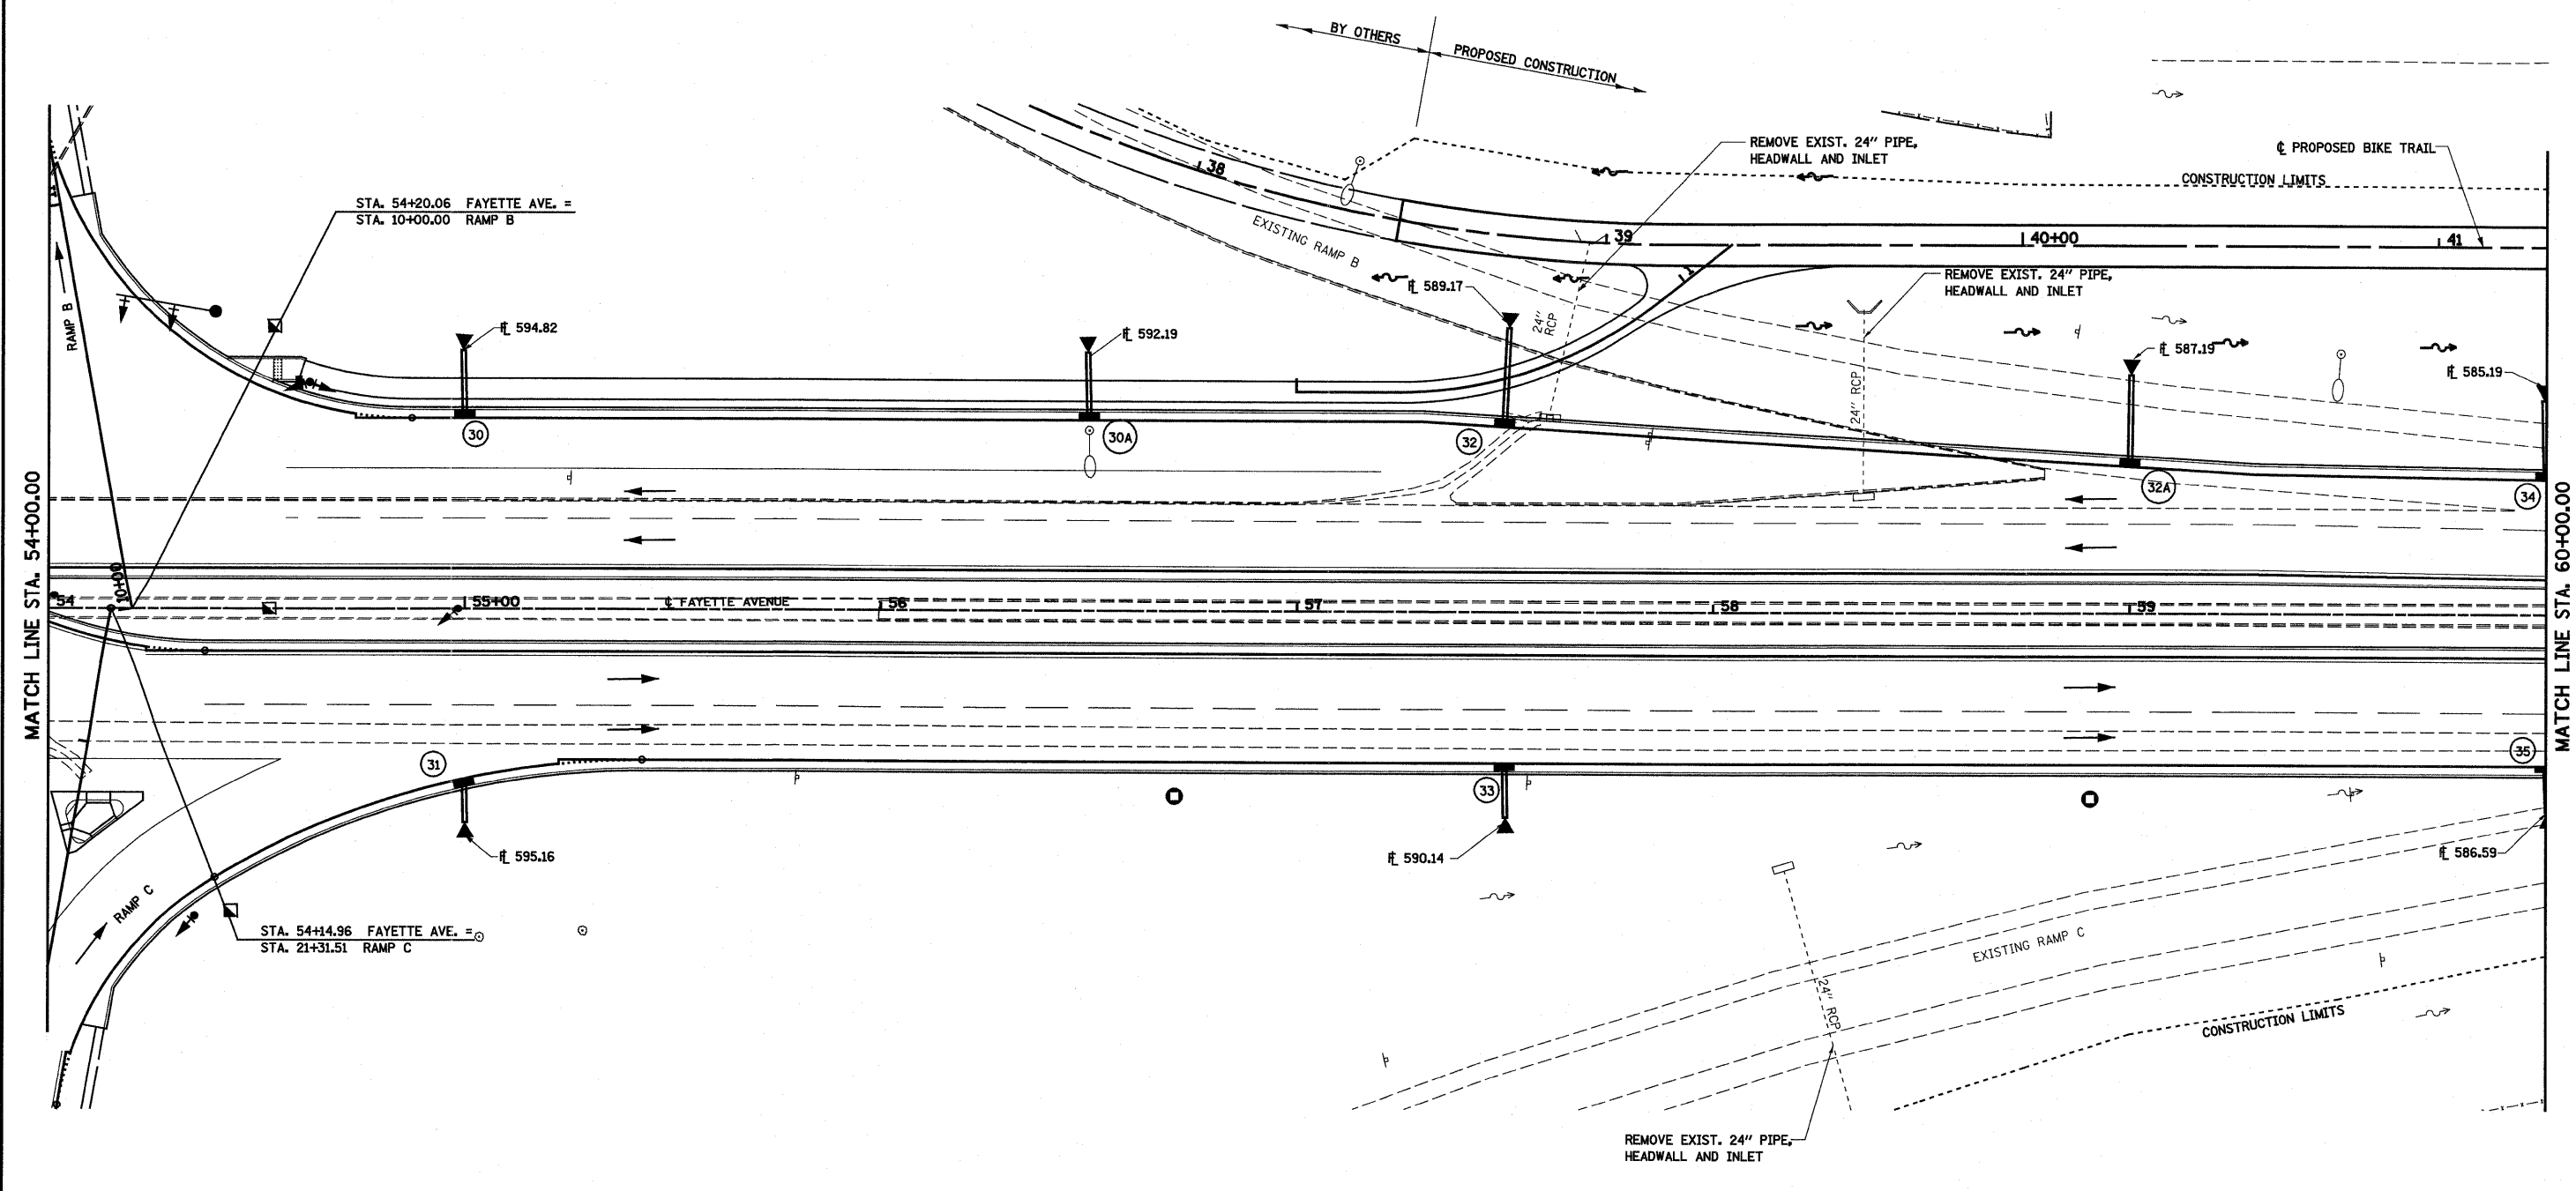

NOTE:  
 ALL PIPES ENTER AND EXIT STRUCTURE  
 AT STRUCTURE FLOW LINE ELEVATION  
 UNLESS OTHERWISE NOTED.



|  |                             |                |           |   |                                      |   |          |           |                 |              |  |
|--|-----------------------------|----------------|-----------|---|--------------------------------------|---|----------|-----------|-----------------|--------------|--|
| FILE NAME =  | USER NAME = paul            | DESIGNED - JWS | REVISED - | <b>STATE OF ILLINOIS<br/>DEPARTMENT OF TRANSPORTATION</b> | <b>DRAINAGE PLAN, FAYETTE AVENUE</b> | F.A.I<br>RTE.                                 | SECTION  | COUNTY    | TOTAL<br>SHEETS | SHEET<br>NO. |  |
| Si\Projects\403-00072-57-70.dgn\Fayette\dm.plandgn | PLOT SCALE = 40,0000' / IN. | DRAWN - PDB    | REVISED - |   |                                      | 57/70   | (25-3)-6 | EFFINGHAM | 839             | 158          |  |
| PLOT DATE = 6/24/2010                              | DATE - 11-05-07             | CHECKED - BRM  | REVISED - |   |                                      | <b>CONTRACT NO. 74293</b>                     |          |           |                 |              |  |
|  |                             |                |           |   |                                      | FED. ROAD DIST. NO. ILLINOIS FED. AID PROJECT |          |           |                 |              |  |

SCALE: 1"=20'    SHEET NO. 4 OF 8 SHEETS    STA. 54+00.00 TO STA. 60+10.00