
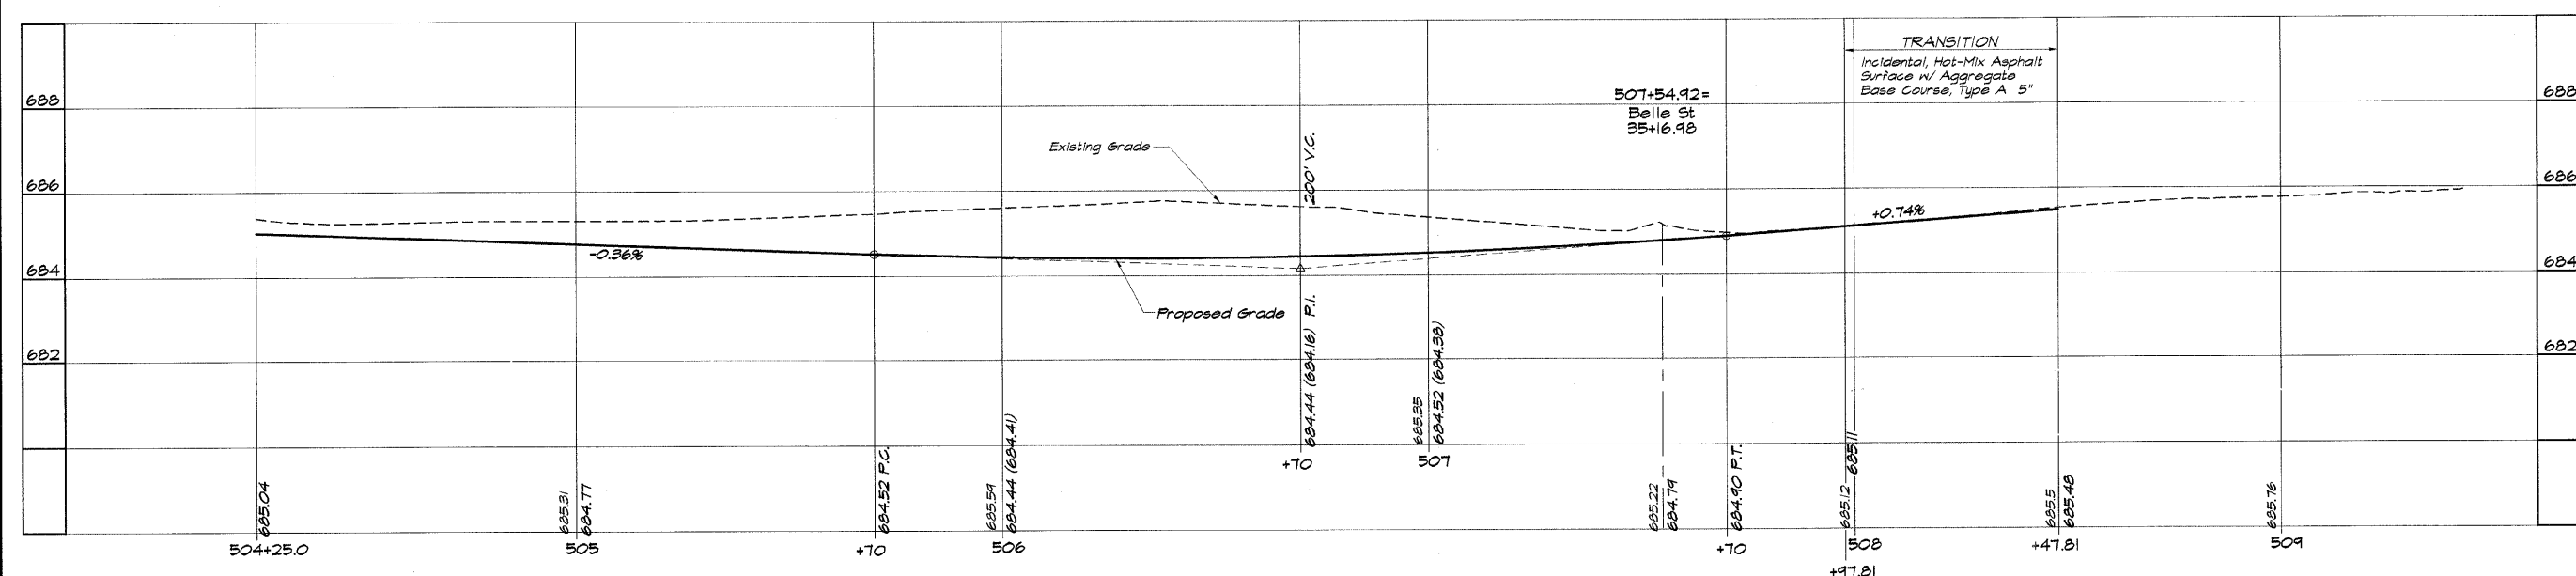


ROUTE NO.	SECTION	CITY	TOTAL SHEETS	SHEET NO.
	05-00001-00-RP	OREANA	46	8
FED. ROAD DIST. NO.	ILLINOIS	PROJECT	RFP-0913 (001)	
CONTRACT NUMBER 95537				

NOTICE
10 ft. Exploration Trench, Special @ Storm Sewer @ Sta. 507+73

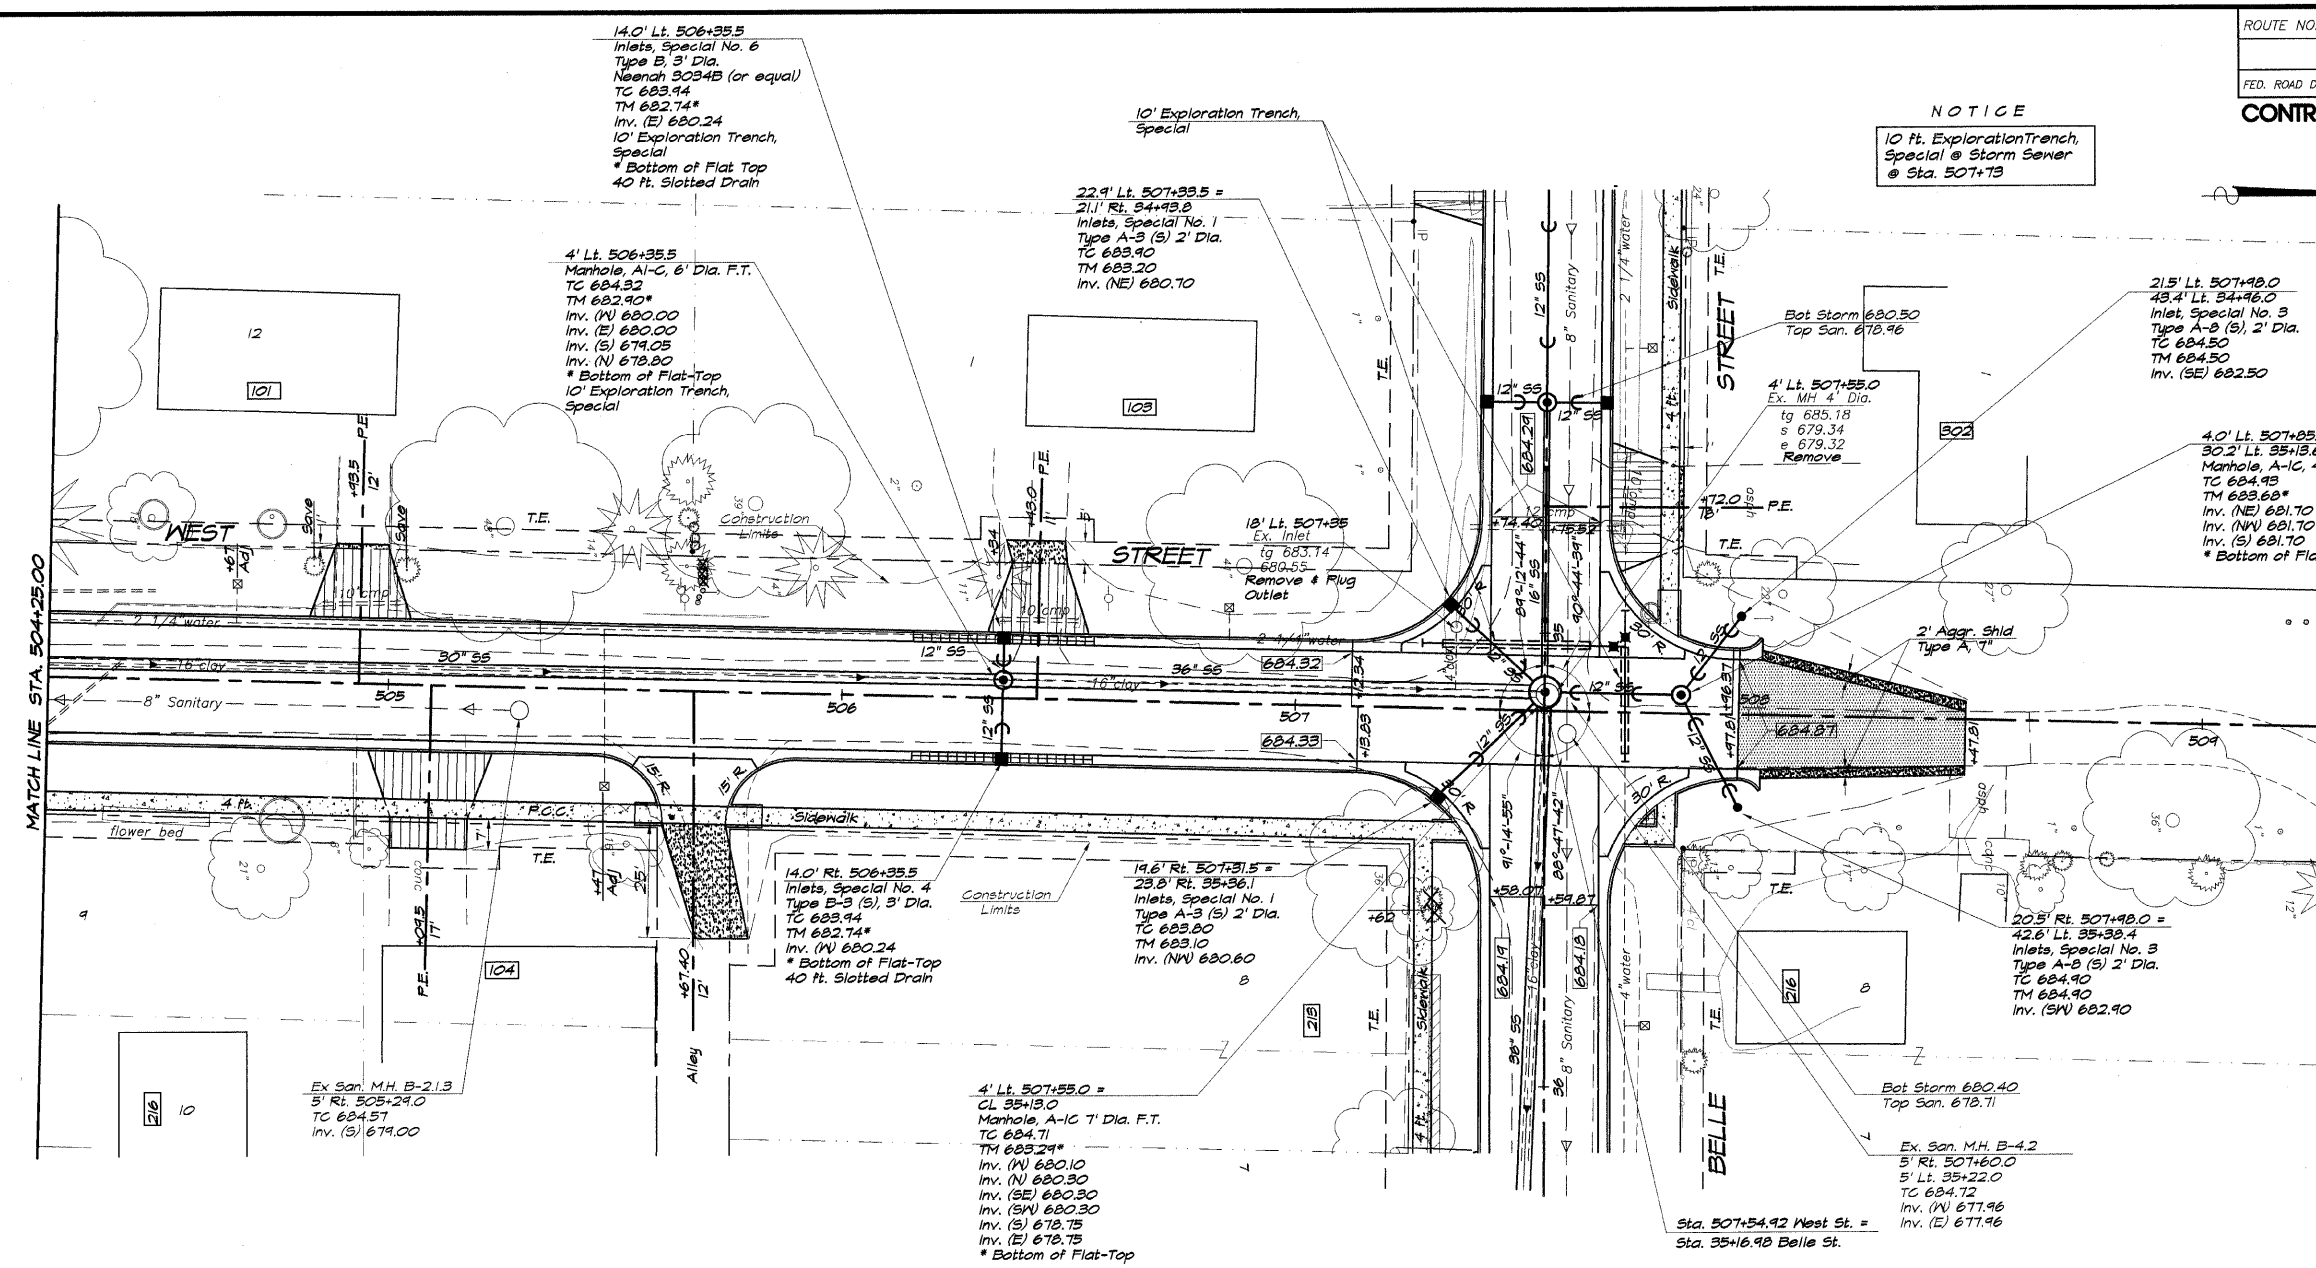

BAINBRIDGE & ASSOCIATES, INC.
Consulting Engineers
1670 SOUTH TAYLORVILLE ROAD
DECATUR ILLINOIS
Illinois License 184-001255

VILLAGE OF OREANA, ILLINOIS
SAFE TRAIL PROJECT
PLAN AND PROFILE
WEST STREET
STATION 504+25.00 TO 509+47.81

DESIGNED: MHP
DRAWN: Les Jenkins
FIELD BOOK: 117B
SCALE: HORIZ. 1" = 20'
VERT. 1" = 2'
DATE: May 2006
JOB NO.: 06-040A

SHEET NO. 8 OF 46