 



F.A. RTE.	SECTION	COUNTY	TOTAL SHEETS	SHEET NO.
1503	08-00260-01-PV	KANE	176	99

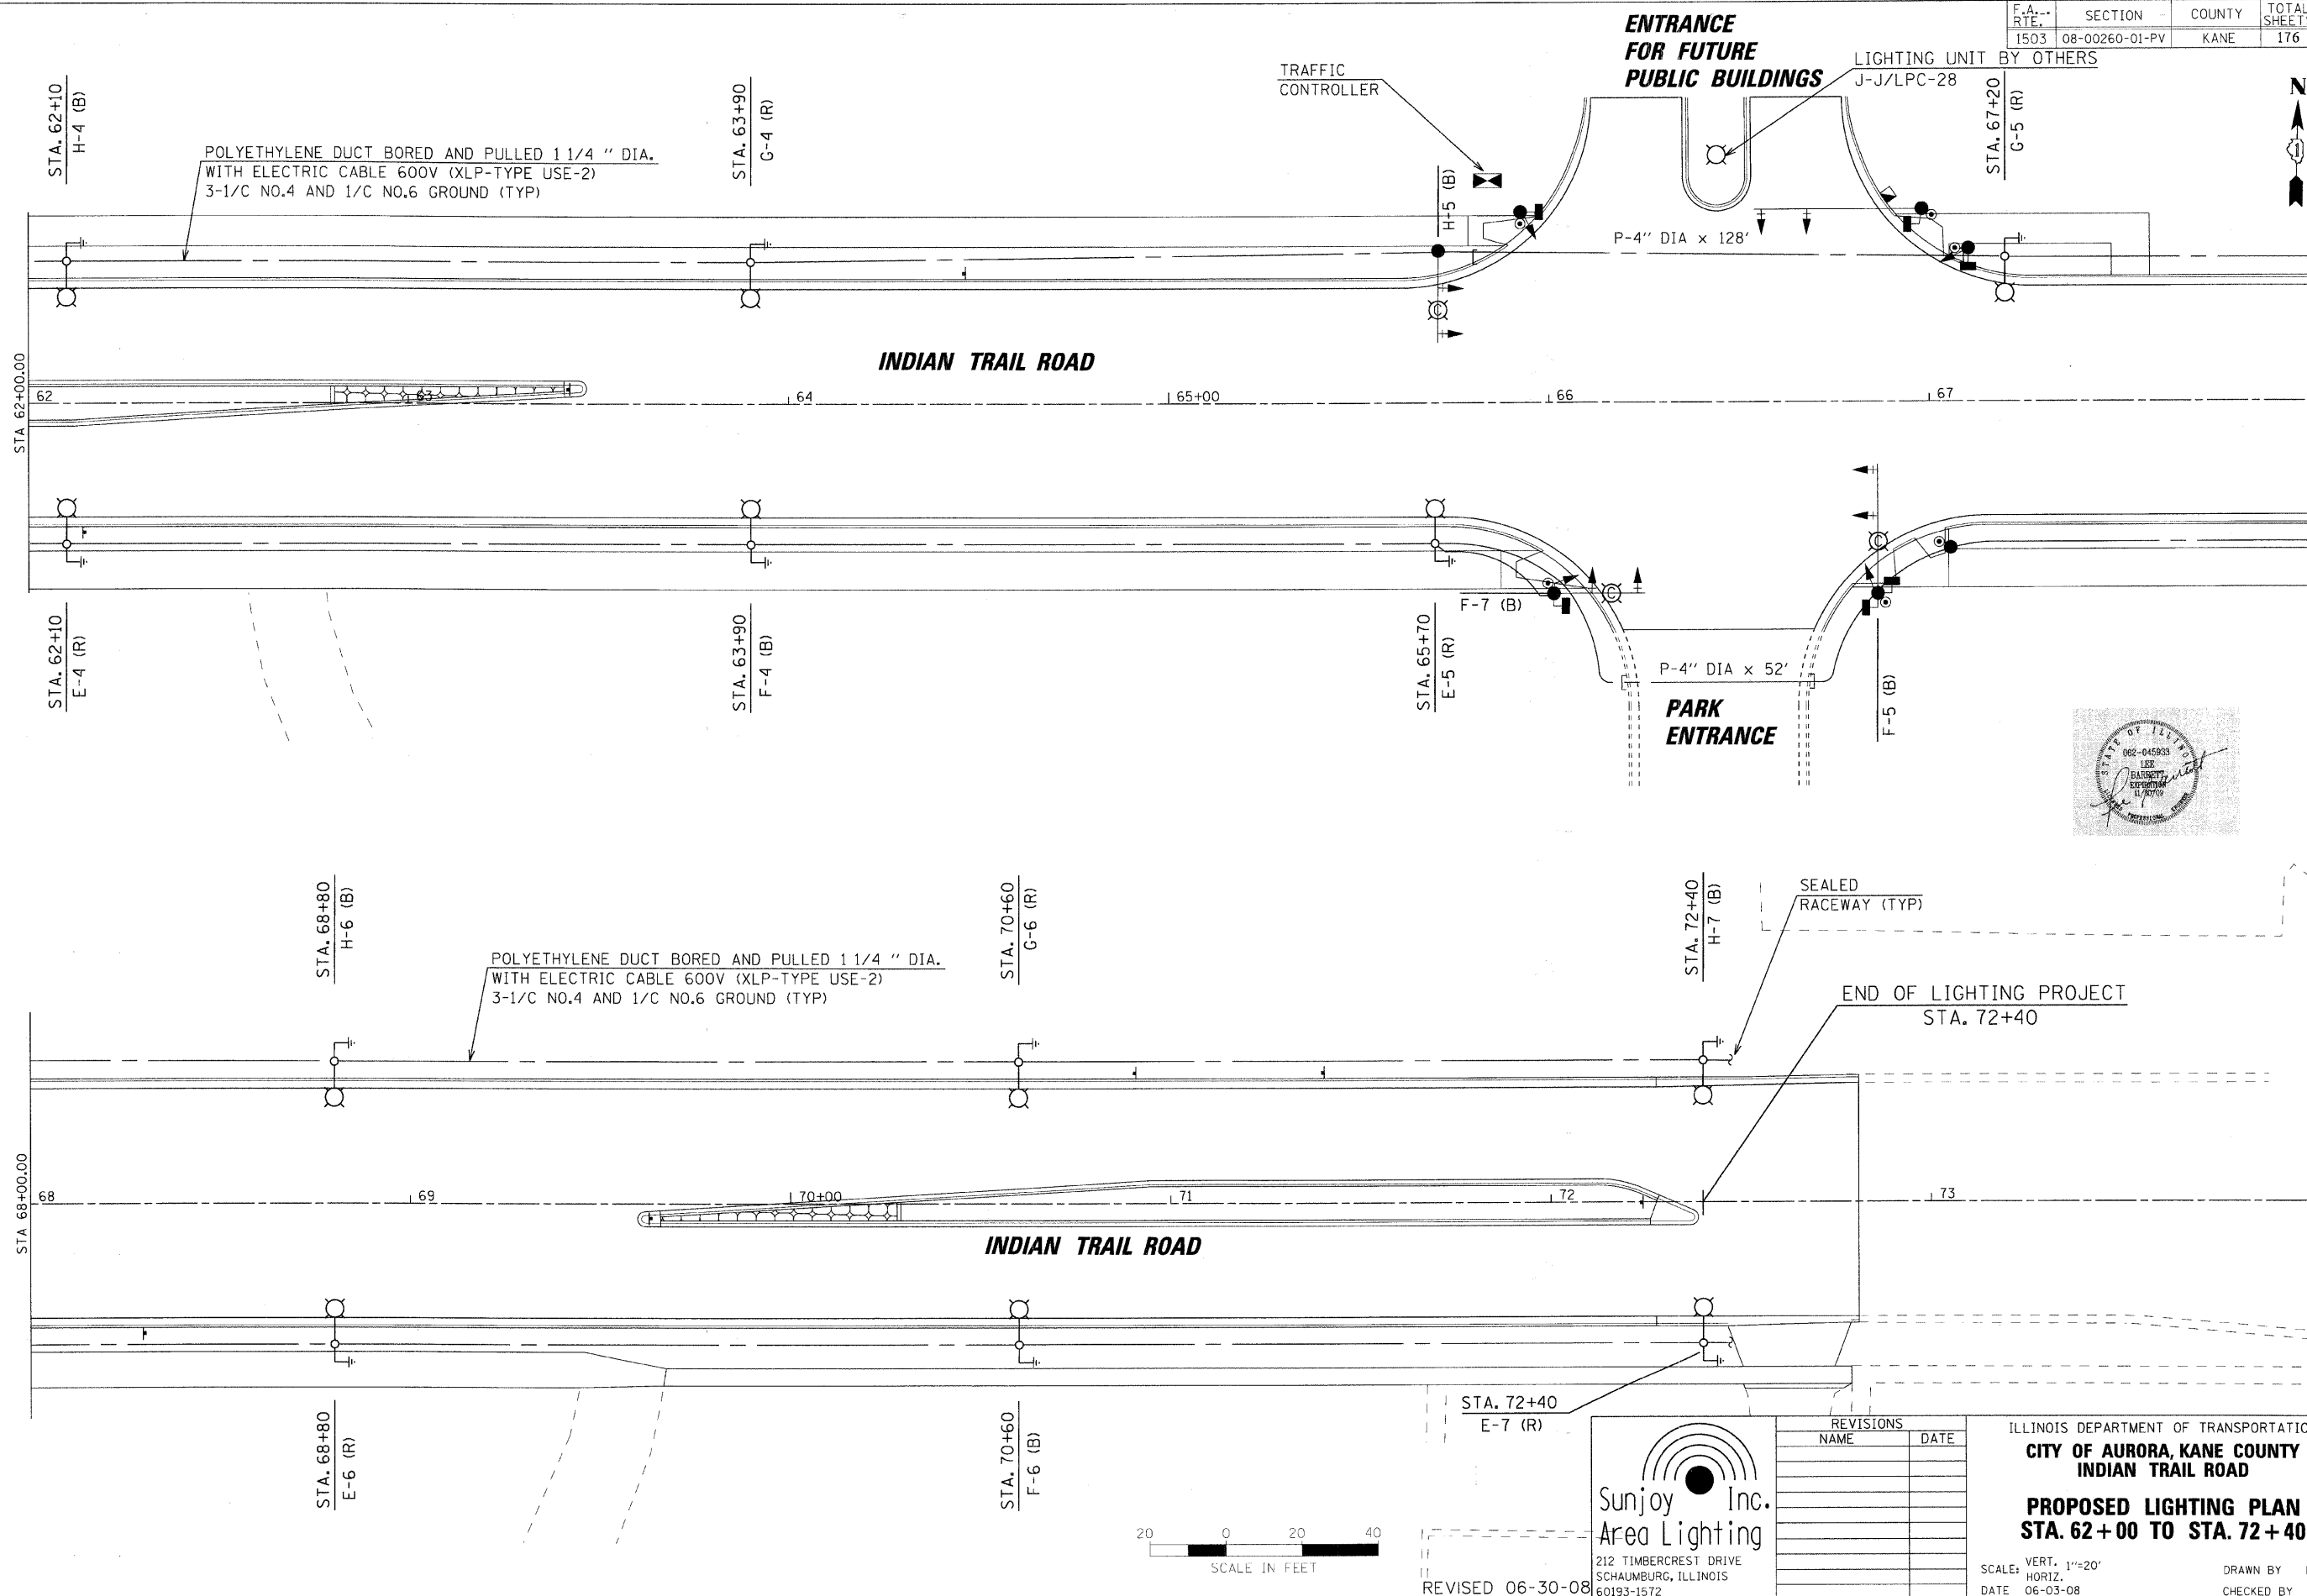

Sunjoy Inc. Area Lighting
 212 TIMBERCREST DRIVE
 SCHAUMBURG, ILLINOIS
 60193-1572

REVISED 06-30-08

REVISIONS	
NAME	DATE

ILLINOIS DEPARTMENT OF TRANSPORTATION
CITY OF AURORA, KANE COUNTY
INDIAN TRAIL ROAD
PROPOSED LIGHTING PLAN
STA. 62+00 TO STA. 72+40

SCALE: VERT. 1"=20'
 HORIZ. 1"=40'
 DATE 06-03-08

DRAWN BY HKD
 CHECKED BY JS