



PLAN	REVISED	BY	DATE
NOTE BOOK	ALIGNED		
NO.	CADD FILE NAME		

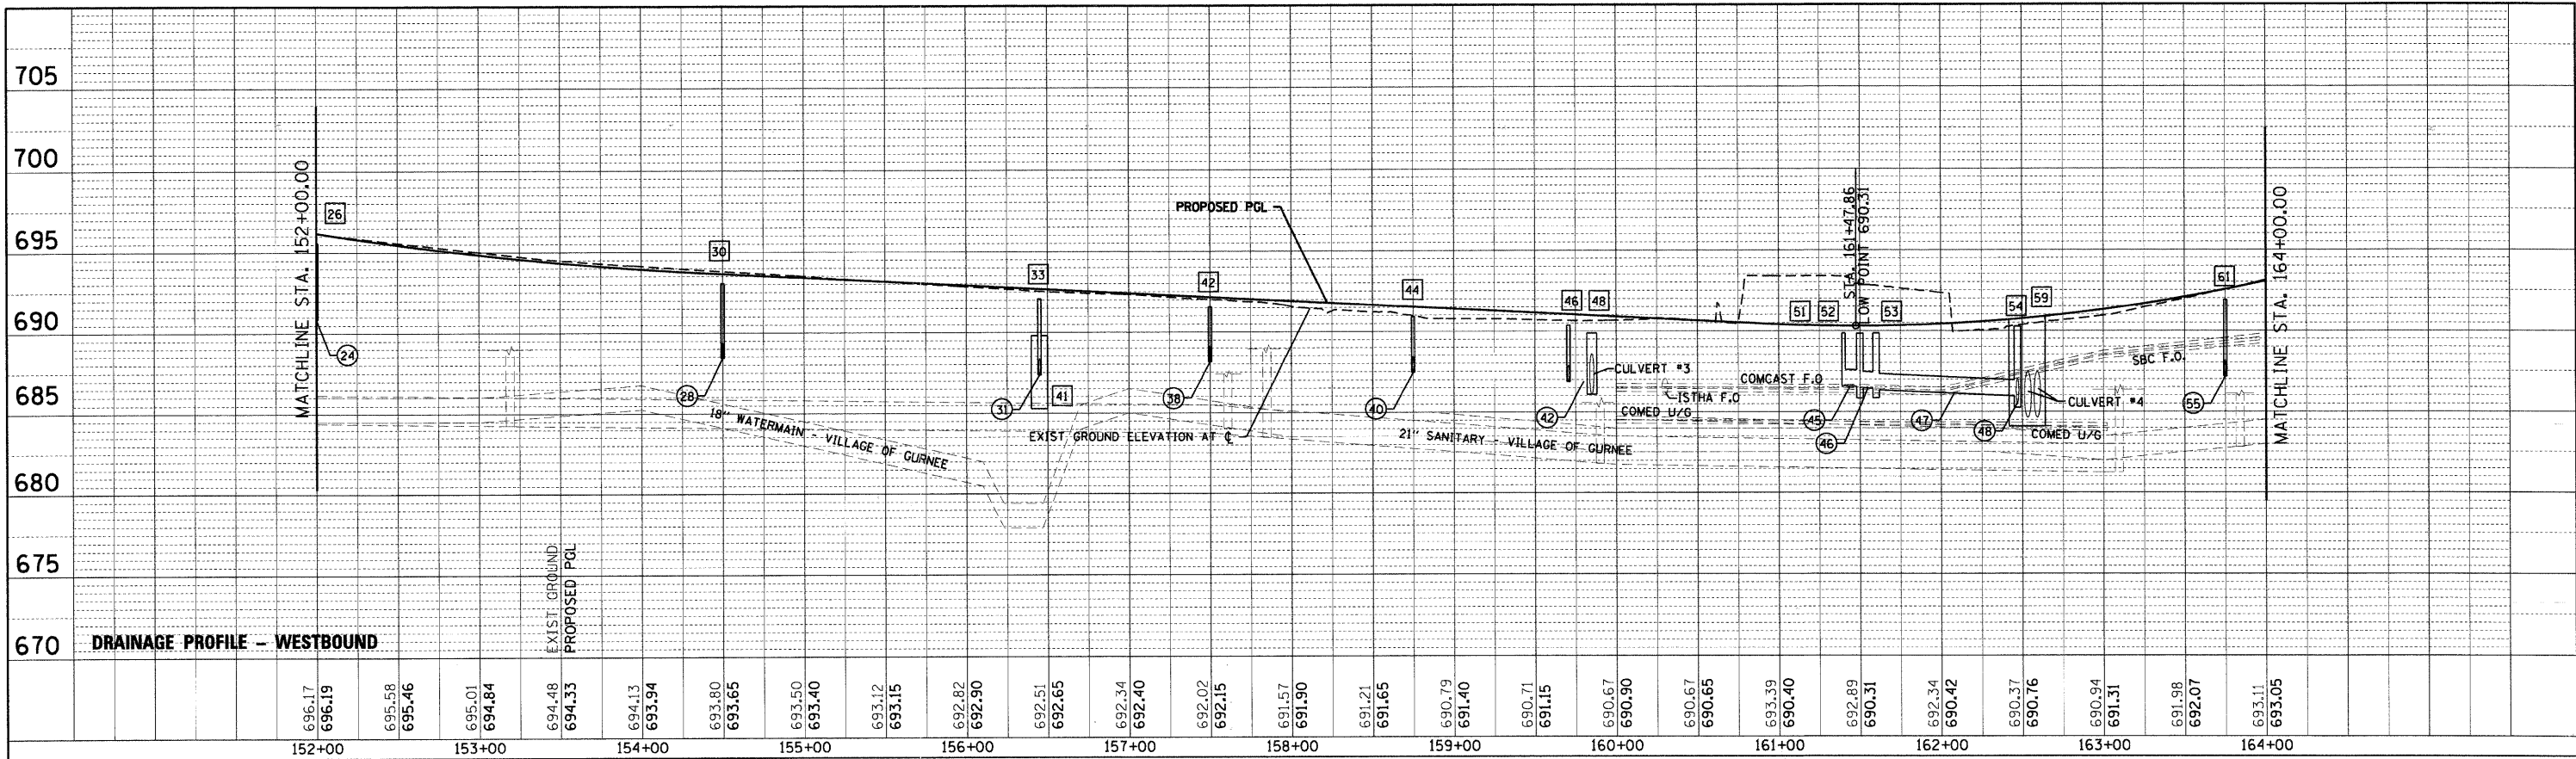

PROFILE	REVISED	BY	DATE
NOTE BOOK	GRADES CHECKED		
NO.	PLANTING NOTES (REVISED)		

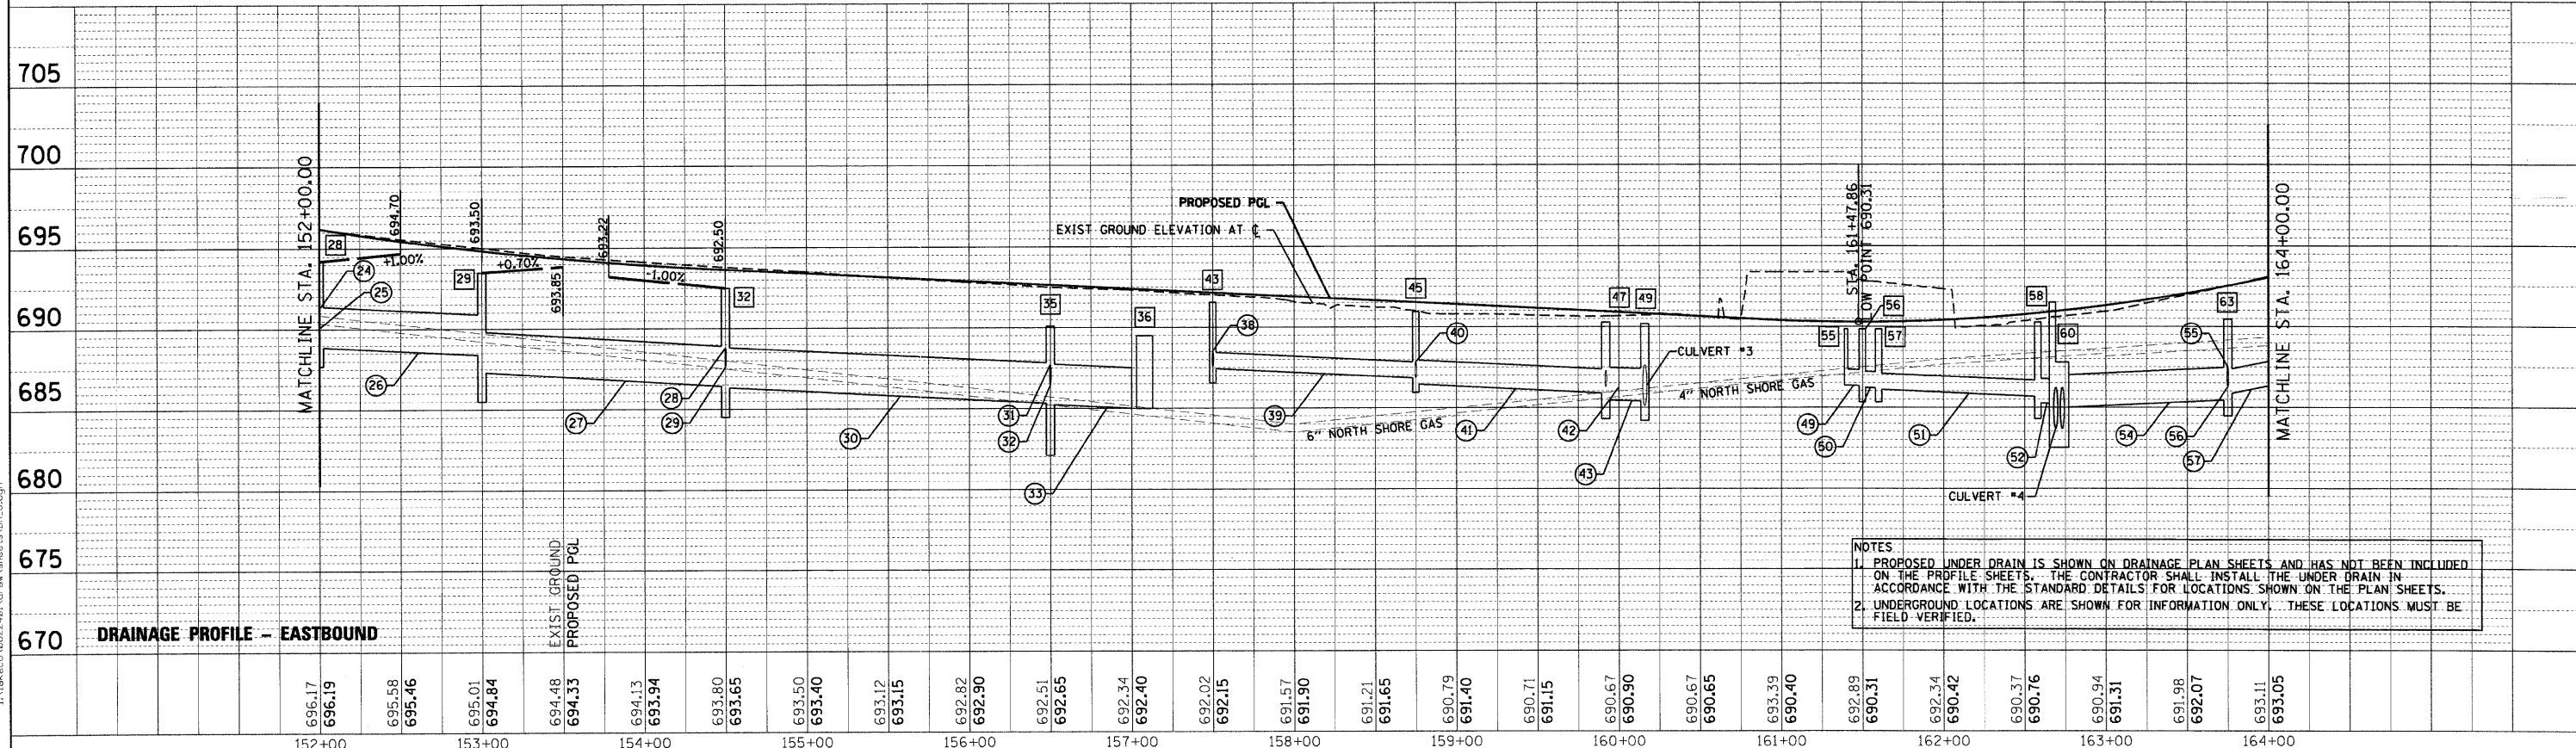

NOTES
 1. PROPOSED UNDER DRAIN IS SHOWN ON DRAINAGE PLAN SHEETS AND HAS NOT BEEN INCLUDED ON THE PROFILE SHEETS. THE CONTRACTOR SHALL INSTALL THE UNDER DRAIN IN ACCORDANCE WITH THE STANDARD DETAILS FOR LOCATIONS SHOWN ON THE PLAN SHEETS.
 2. UNDERGROUND LOCATIONS ARE SHOWN FOR INFORMATION ONLY. THESE LOCATIONS MUST BE FIELD VERIFIED.

FILE NAME = J:\Lakeco\0822401\drain\AutoCAD\DR_8.dgn

CMT CRAWFORD, MURPHY & TULLY, INC. CONSULTING ENGINEERS License No. 184-000613	USER NAME = Steve Prange	DESIGNED - SJP	REVISED -	Lake County Division of Transportation	PROPOSED DRAINAGE PROFILE SCALE: 1"=50' SHEET NO. 8 OF 10 SHEETS STA. 152+00 TO STA. 164+00		F.A. RTE. 1016	SECTION 02-00110-12-WR	COUNTY LAKE	TOTAL SHEETS 206	SHEET NO. 76	
	PLOT SCALE = 50.0000' / IN.	CHECKED - KDN	REVISED -				CONTRACT NO. 63209					
	PLOT DATE = 05/29/09	DATE - 05/29/09	REVISED -				FED. ROAD DIST. NO. 1 ILLINOIS FED. AID PROJECT					