



PLAN	REVIEWED	BY	DATE
NO.	PLOTTED		
	ALIGNMENT CHECKED		
	NO.		
	FILE NAME		

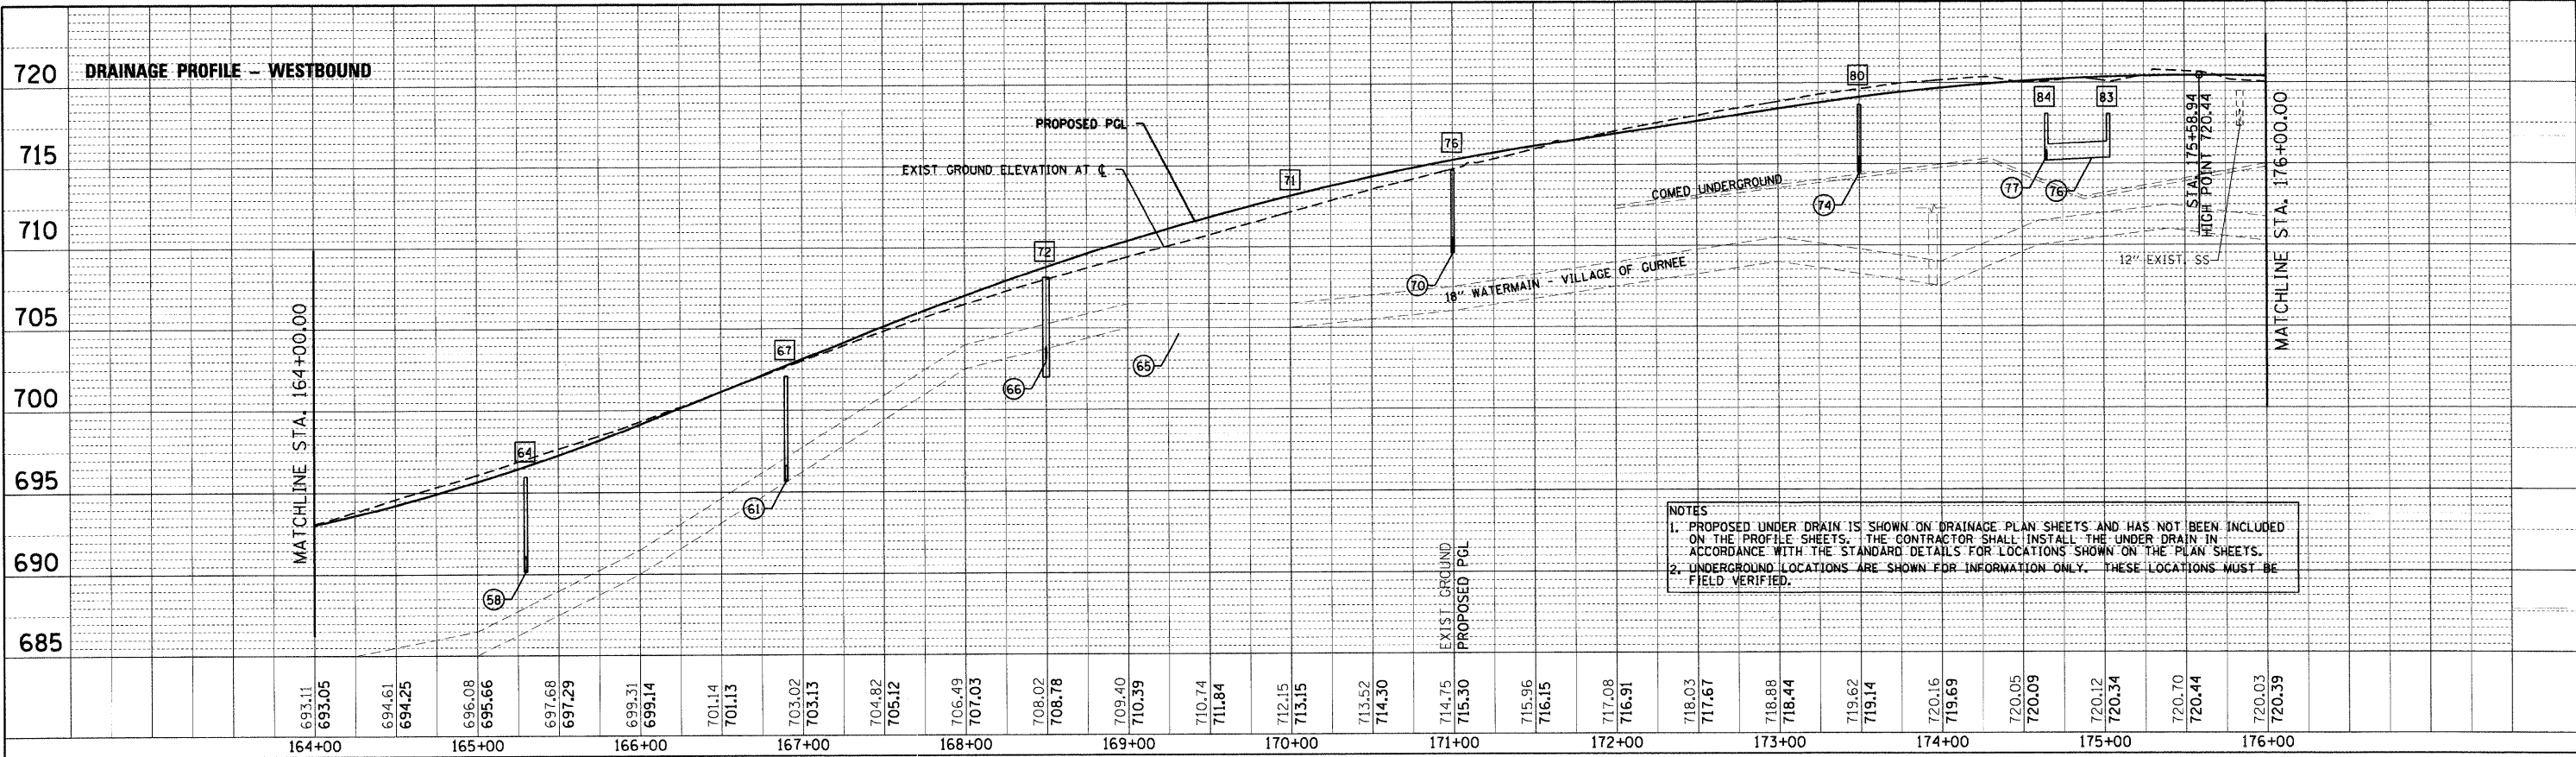

NOTES  
 1. PROPOSED UNDER DRAIN IS SHOWN ON DRAINAGE PLAN SHEETS AND HAS NOT BEEN INCLUDED ON THE PROFILE SHEETS. THE CONTRACTOR SHALL INSTALL THE UNDER DRAIN IN ACCORDANCE WITH THE STANDARD DETAILS FOR LOCATIONS SHOWN ON THE PLAN SHEETS.  
 2. UNDERGROUND LOCATIONS ARE SHOWN FOR INFORMATION ONLY. THESE LOCATIONS MUST BE FIELD VERIFIED.

PROFILE	SURVEYED	BY	DATE
NO.	GRADES CHECKED		
	B.M. NOTED		
	STRUCTURE NOTATIONS CHECKED		

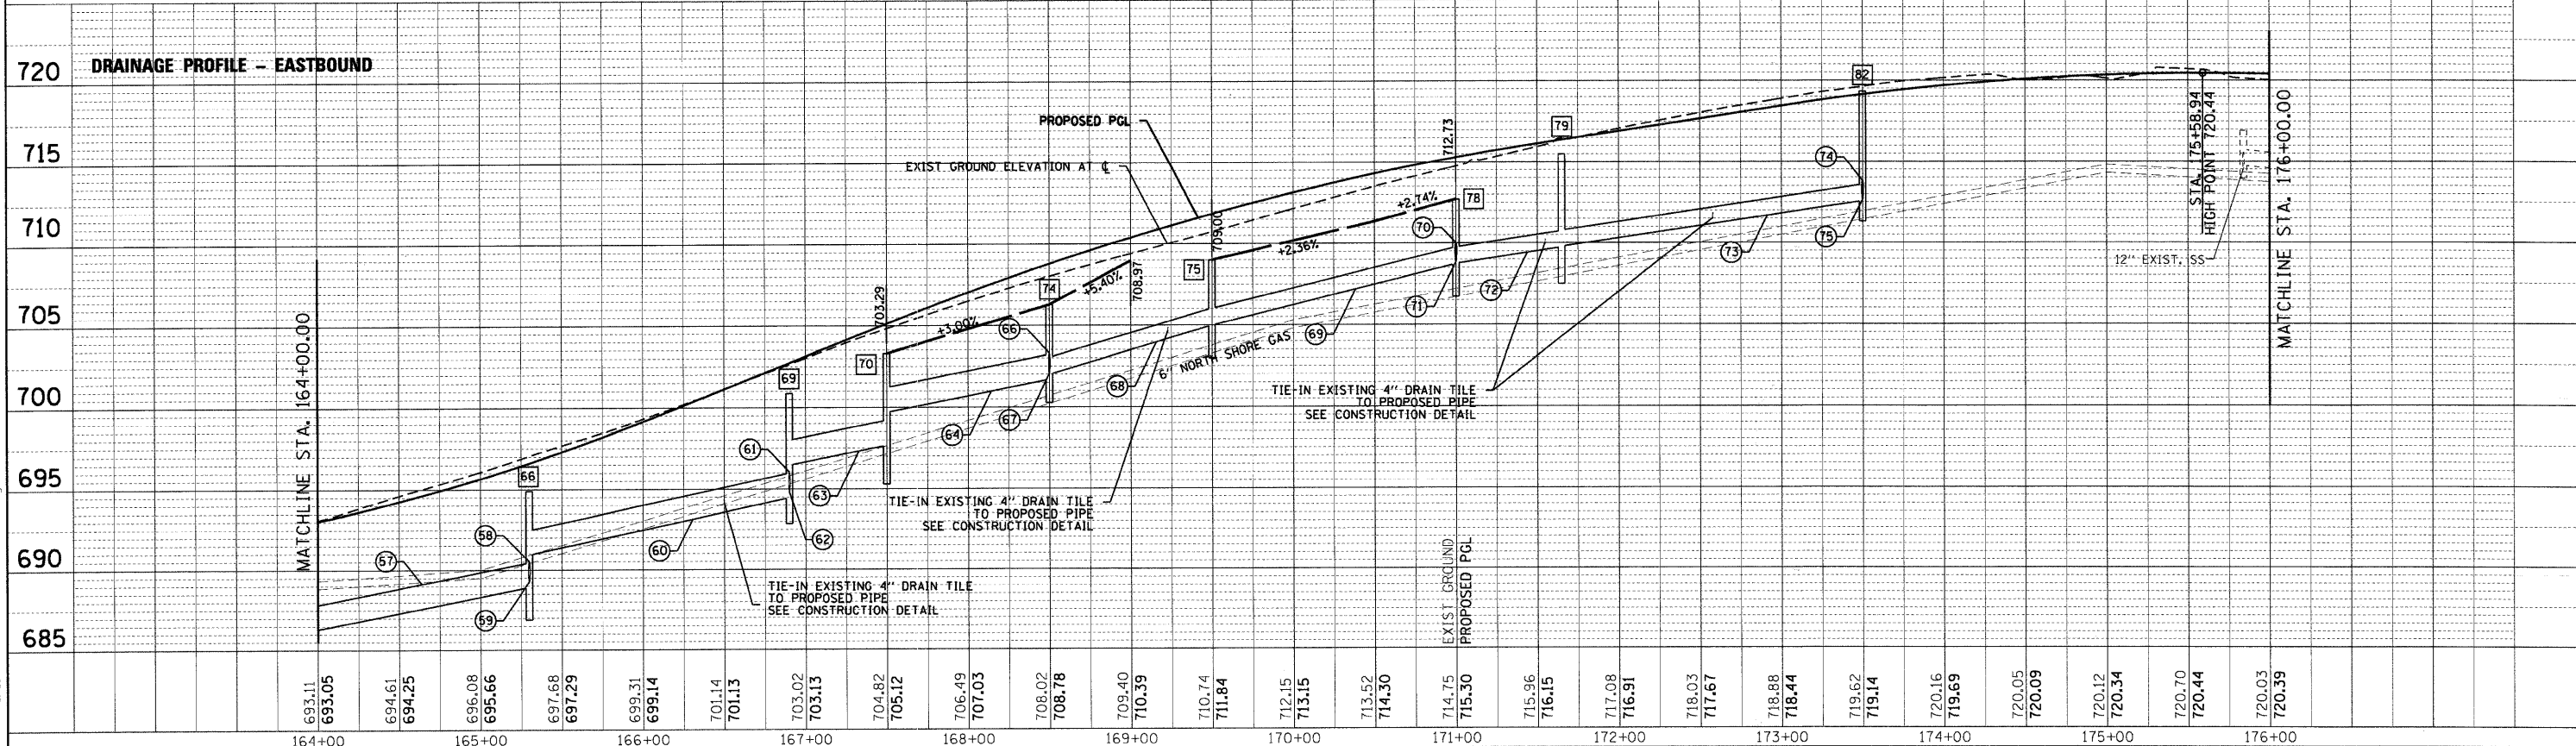

FILE NAME = I:\lakeca\B22481\dr-aa-shreeus\_UR\_9.dgn

<b>CMT</b> CRANFORD, MURPHY & TILLY, INC. CONSULTING ENGINEERS License No. 04-000613	USER NAME = Steve Prange	DESIGNED - SJP	REVISED -	<b>Lake County</b> Division of Transportation	<b>PROPOSED DRAINAGE PROFILE</b> SCALE: 1"=50'    SHEET NO. 9 OF 10 SHEETS    STA. 164+00 TO STA. 176+00		F.A. RTE. 1016	SECTION 02-00110-12-WR	COUNTY LAKE	TOTAL SHEETS 206	SHEET NO. 77	
	PLOT SCALE = 50.0000' / IN.	CHECKED - KDN	REVISED -				CONTRACT NO. 63209					
	PLOT DATE = 05/29/09	DATE - 05/29/09	REVISED -				FED. ROAD DIST. NO. 1 ILLINOIS FED. AID PROJECT					