
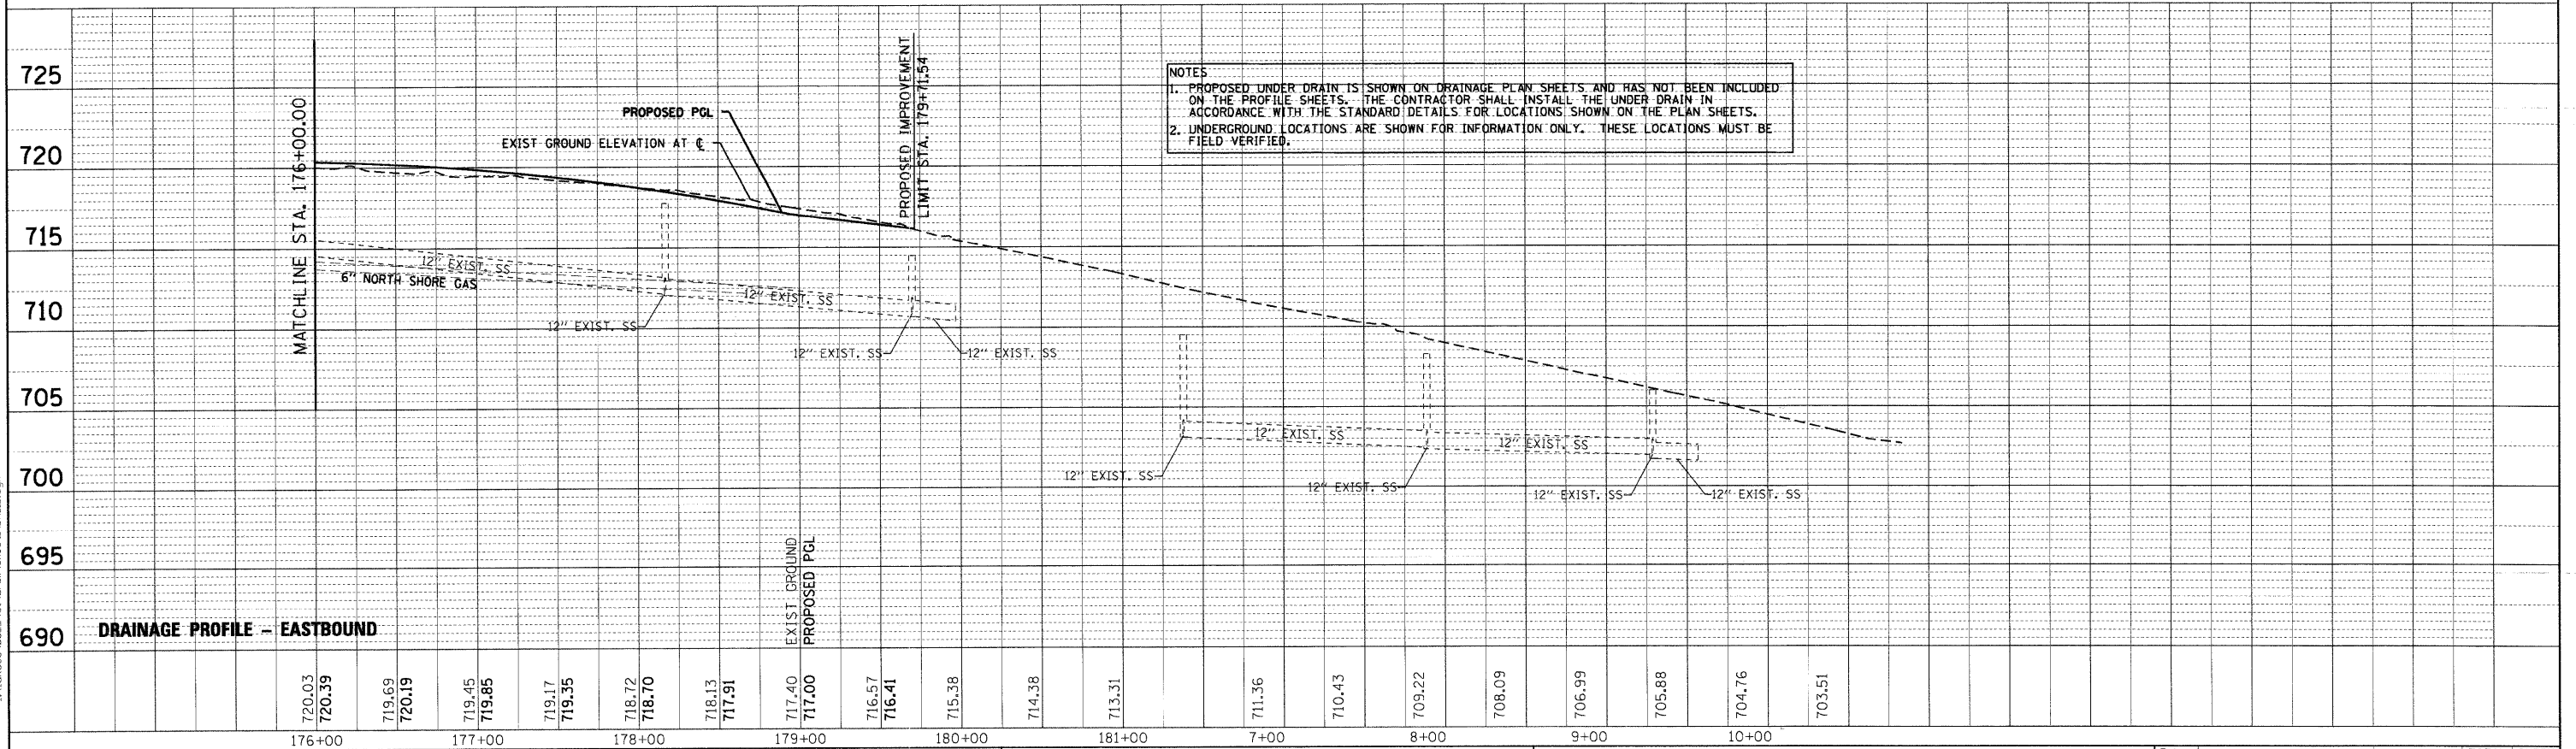


PLAN	DATE
BY	
REVISION	
ALIGNED	
CHECKED	
NO. 1	
NO. 2	
NO. 3	
NO. 4	
NO. 5	
NO. 6	
NO. 7	
NO. 8	
NO. 9	
NO. 10	

PROFILE	DATE
BY	
REVISION	
GRADES CHECKED	
B.M. NOTED	
STRUCTURE NOTATION OK'D	
NO. 1	
NO. 2	
NO. 3	
NO. 4	
NO. 5	
NO. 6	
NO. 7	
NO. 8	
NO. 9	
NO. 10	

FILE NAME = I:\Lakeco\0822481\dr-04\Sheets\DR_10.dgn

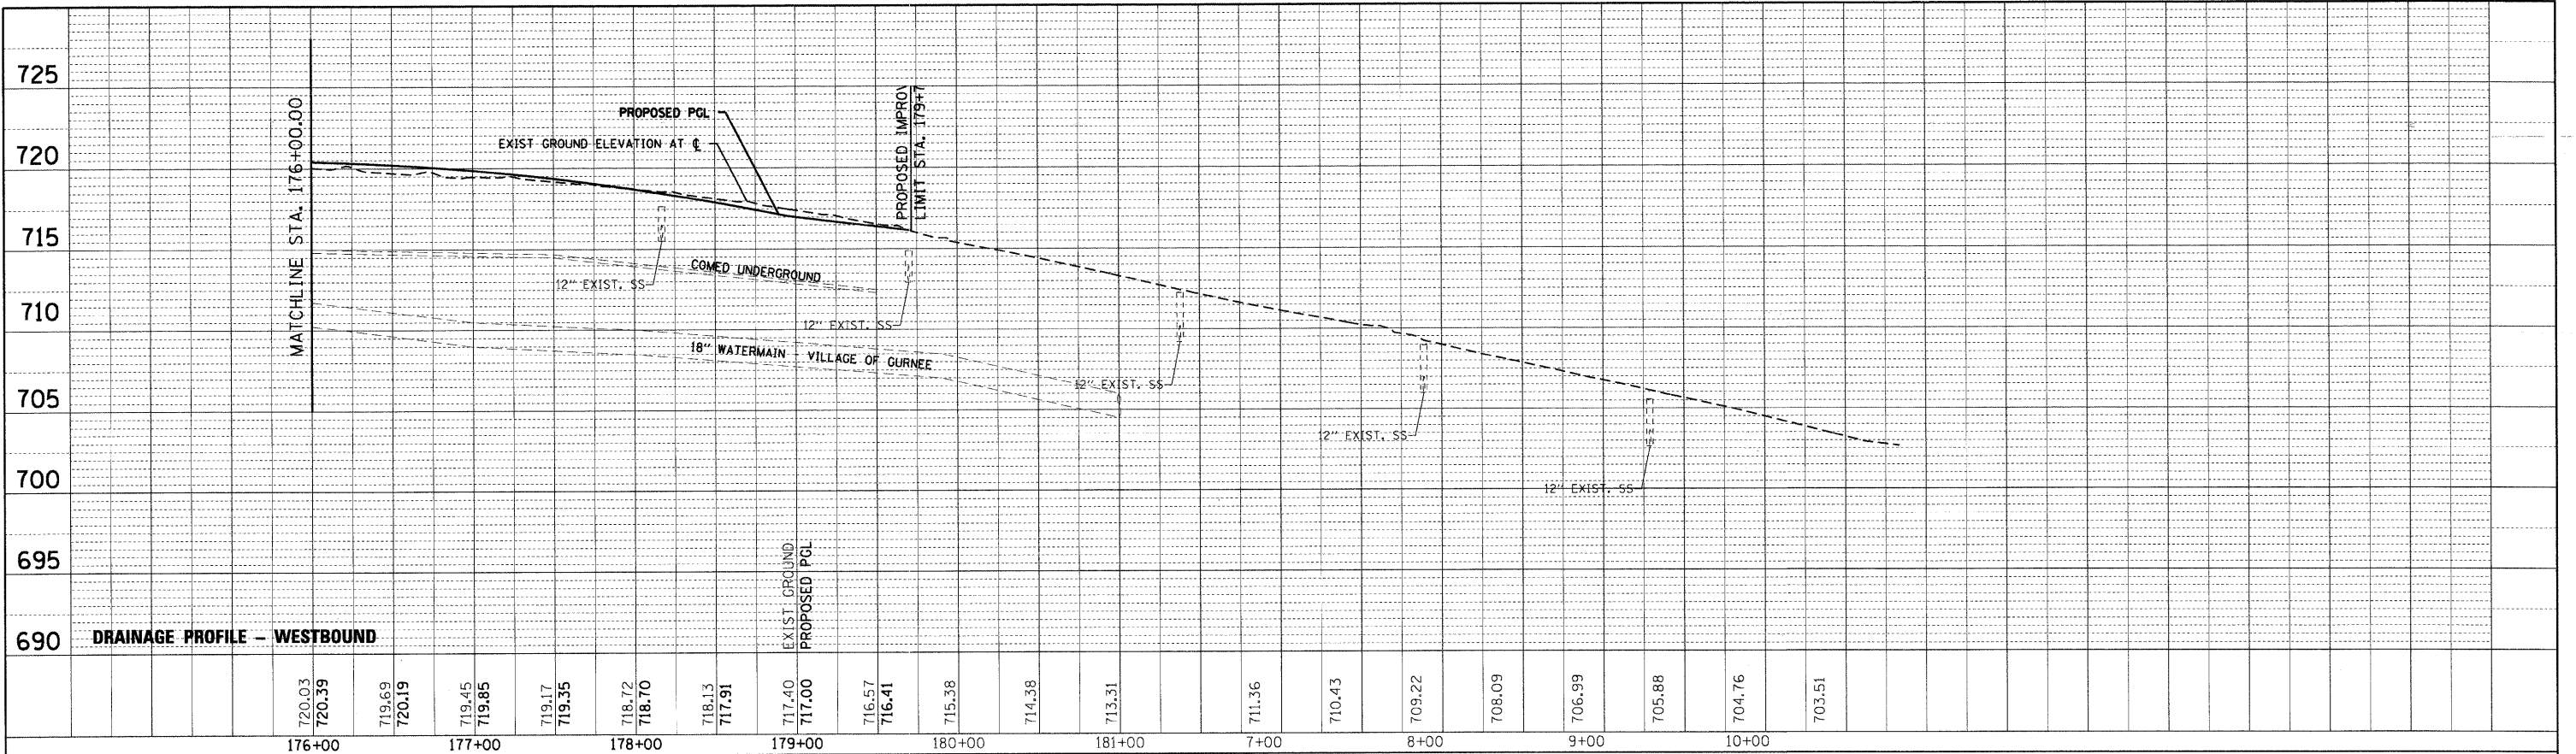

NOTES
 1. PROPOSED UNDER DRAIN IS SHOWN ON DRAINAGE PLAN SHEETS AND HAS NOT BEEN INCLUDED ON THE PROFILE SHEETS. THE CONTRACTOR SHALL INSTALL THE UNDER DRAIN IN ACCORDANCE WITH THE STANDARD DETAILS FOR LOCATIONS SHOWN ON THE PLAN SHEETS.
 2. UNDERGROUND LOCATIONS ARE SHOWN FOR INFORMATION ONLY. THESE LOCATIONS MUST BE FIELD VERIFIED.

CMT
 CRAWFORD, MURPHY & TILLY, INC.
 CONSULTING ENGINEERS
 License No. 184-000613

USER NAME = Steve Prange	DESIGNED - SJP	REVISED -
PLOT SCALE = 50.0000' / IN.	DRAWN - SJP	REVISED -
PLOT DATE = 05/29/09	CHECKED - KDN	REVISED -
	DATE - 05/29/09	REVISED -



PROPOSED DRAINAGE PROFILE	
SCALE: 1"=50'	SHEET NO. 10 OF 10 SHEETS
STA. 176+00	TO STA. 10+00

F.A. RTE.	SECTION	COUNTY	TOTAL SHEETS	SHEET NO.
1016	02-00110-12-WR	LAKE	206	78
CONTRACT NO. 63209				
FED. ROAD DIST. NO. 1 ILLINOIS FED. AID PROJECT				