


CONTRACT NO: 83827				
F.A.D. RTE.	SECTION	COUNTY	TOTAL SHEETS	SHEET NO.
3570	00-00116-00-BR	DUPAGE	106	21
STA.	TO STA.			
FED. ROAD DIST. NO.	ILLINOIS	FED. AID PROJECT		

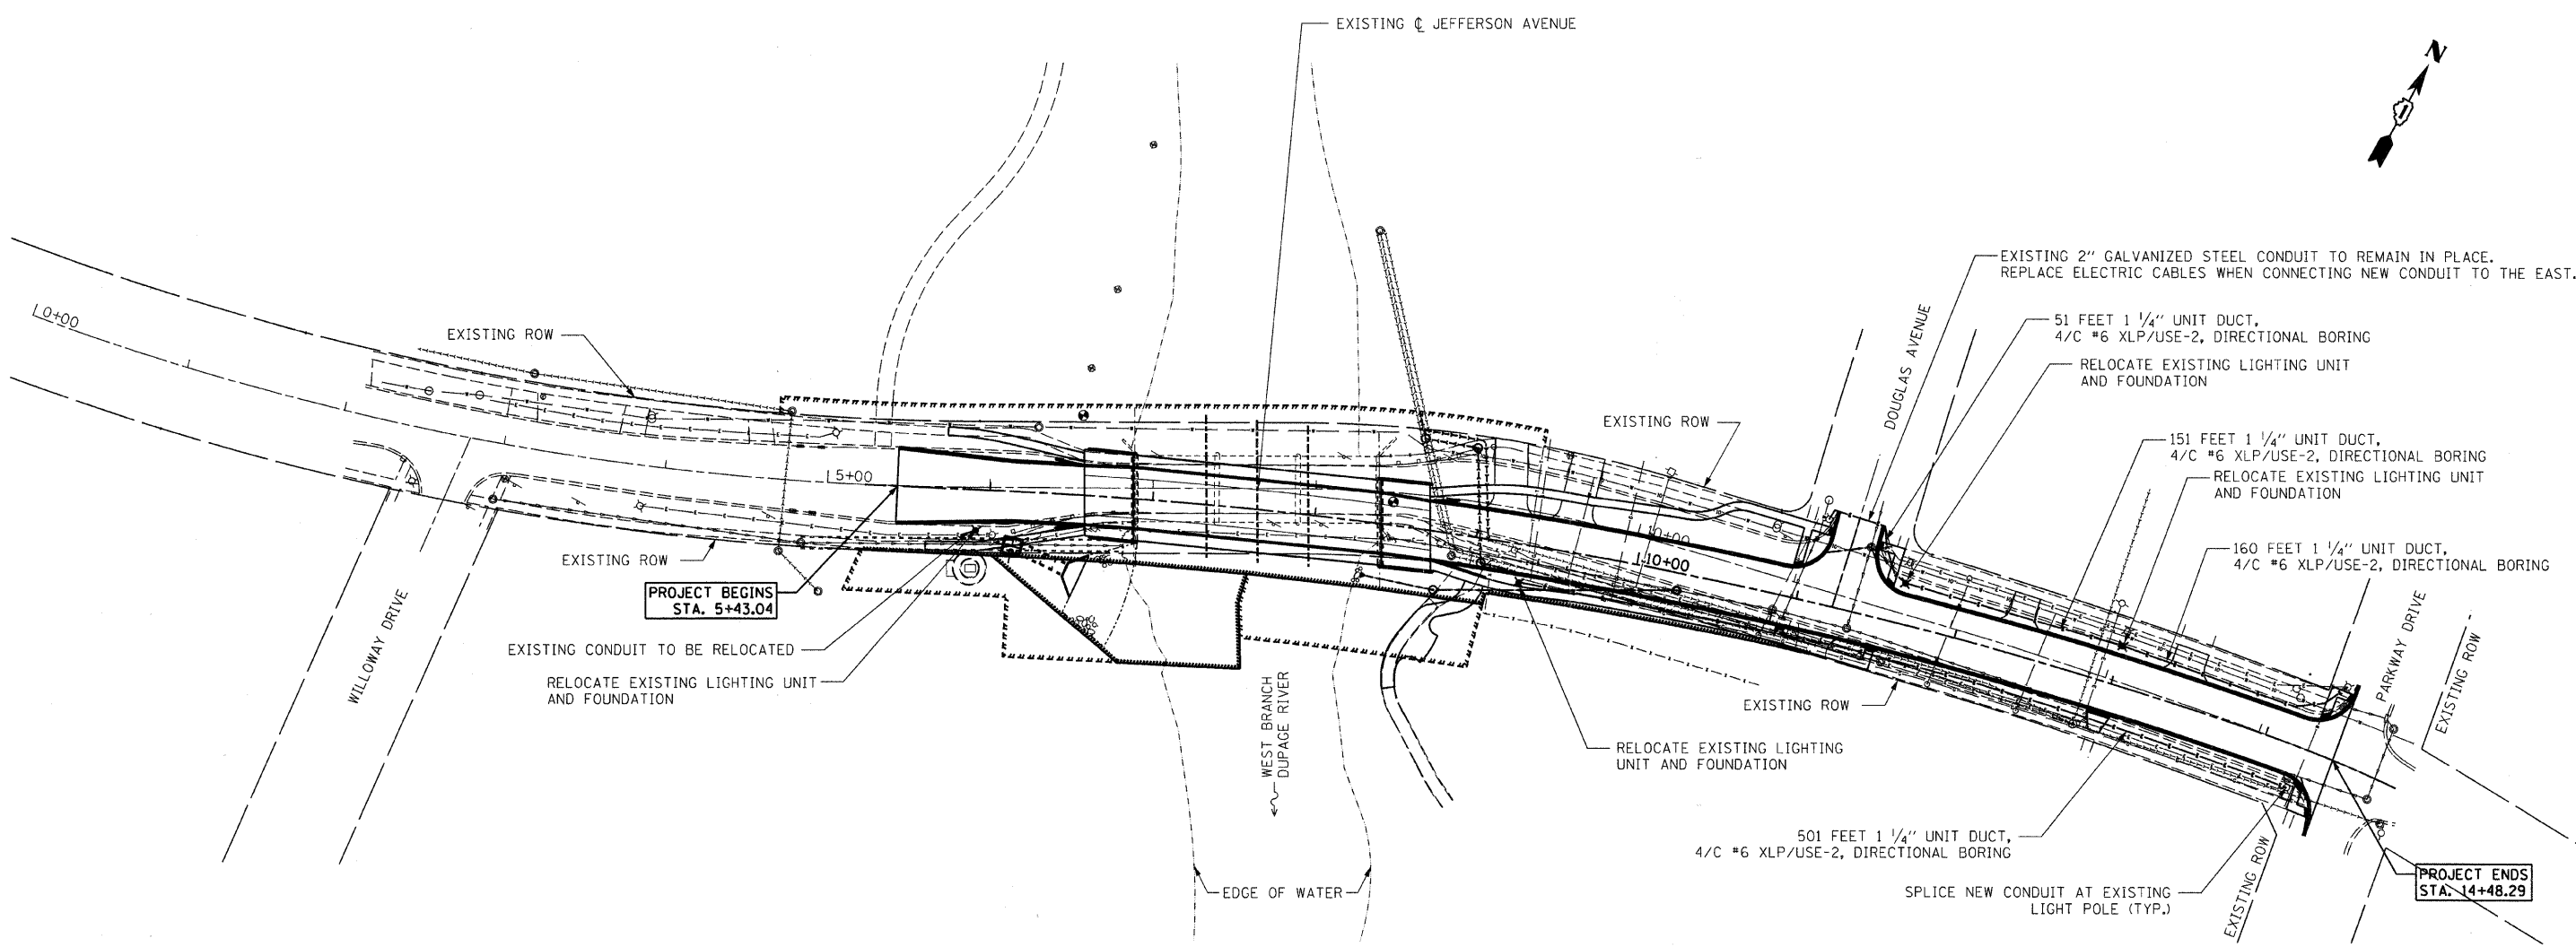

M:\865-039 & 065-032 J. Jefferson Revisions 08\CADD Sheets\Lighting.dgn
 7/15/2009 11:46:41 AM

REVISIONS	
NAME	DATE
PER DEC & CLIENT	9/13/05
PER IDOT	11/1/05

ILLINOIS DEPARTMENT OF TRANSPORTATION
 PROPOSED LIGHTING PLAN
 JEFFERSON AVENUE OVER
 WEST BRANCH DUPAGE RIVER
 SCALE: 1" = 50'
 DATE: APRIL 6, 2009
 DRAWN BY: GM
 CHECKED BY: HRT