

V:\PROJECTS\DRAWINGS\MACOMB\WARD ST\PHASE 2\WARD-ST-PH2.dwg, 3/30/2009 10:03:11 AM

CITY OF MACOMB-WARD STREET  
 SEC. 09-00139-01-PV F.A.U. 6919  
 PROJ. ARA-5040 (010)  
 CONTRACT No. 89527 SHT 13 OF 32





SHEET NO.  
**13**  
 of **32**

**McClure**  
 Engineering Associates, Inc.  
 Macomb, Illinois 61455  
 13091 833-4594 FAX 13091 837-4809  
 Design Firm License #BA-000618 Copyright 2009 by McClure Engineering Associates, Inc.

PLOTTING SCALE: 1" = 20'  
 DRAWN BY: TAB  
 CHECKED BY: JAR  
 DATE: MARCH 2009

NO.	REVISIONS	DATE

**WARD STREET IMPROVEMENTS - PHASE 2**  
**STORM SEWER PLAN AND PROFILE-STA. 331+00 TO 336+00**  
 CITY OF MACOMB  
 SOUTH WARD ST.  
 FILE NAME: \MACOMB\WARDST\PHASE 2\WARD-ST-PH2.DWG FIELD BOOK No: 2237 JOB NUMBER: 03-29-0809  
 MACOMB, ILLINOIS

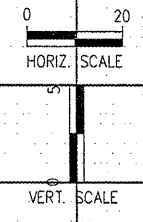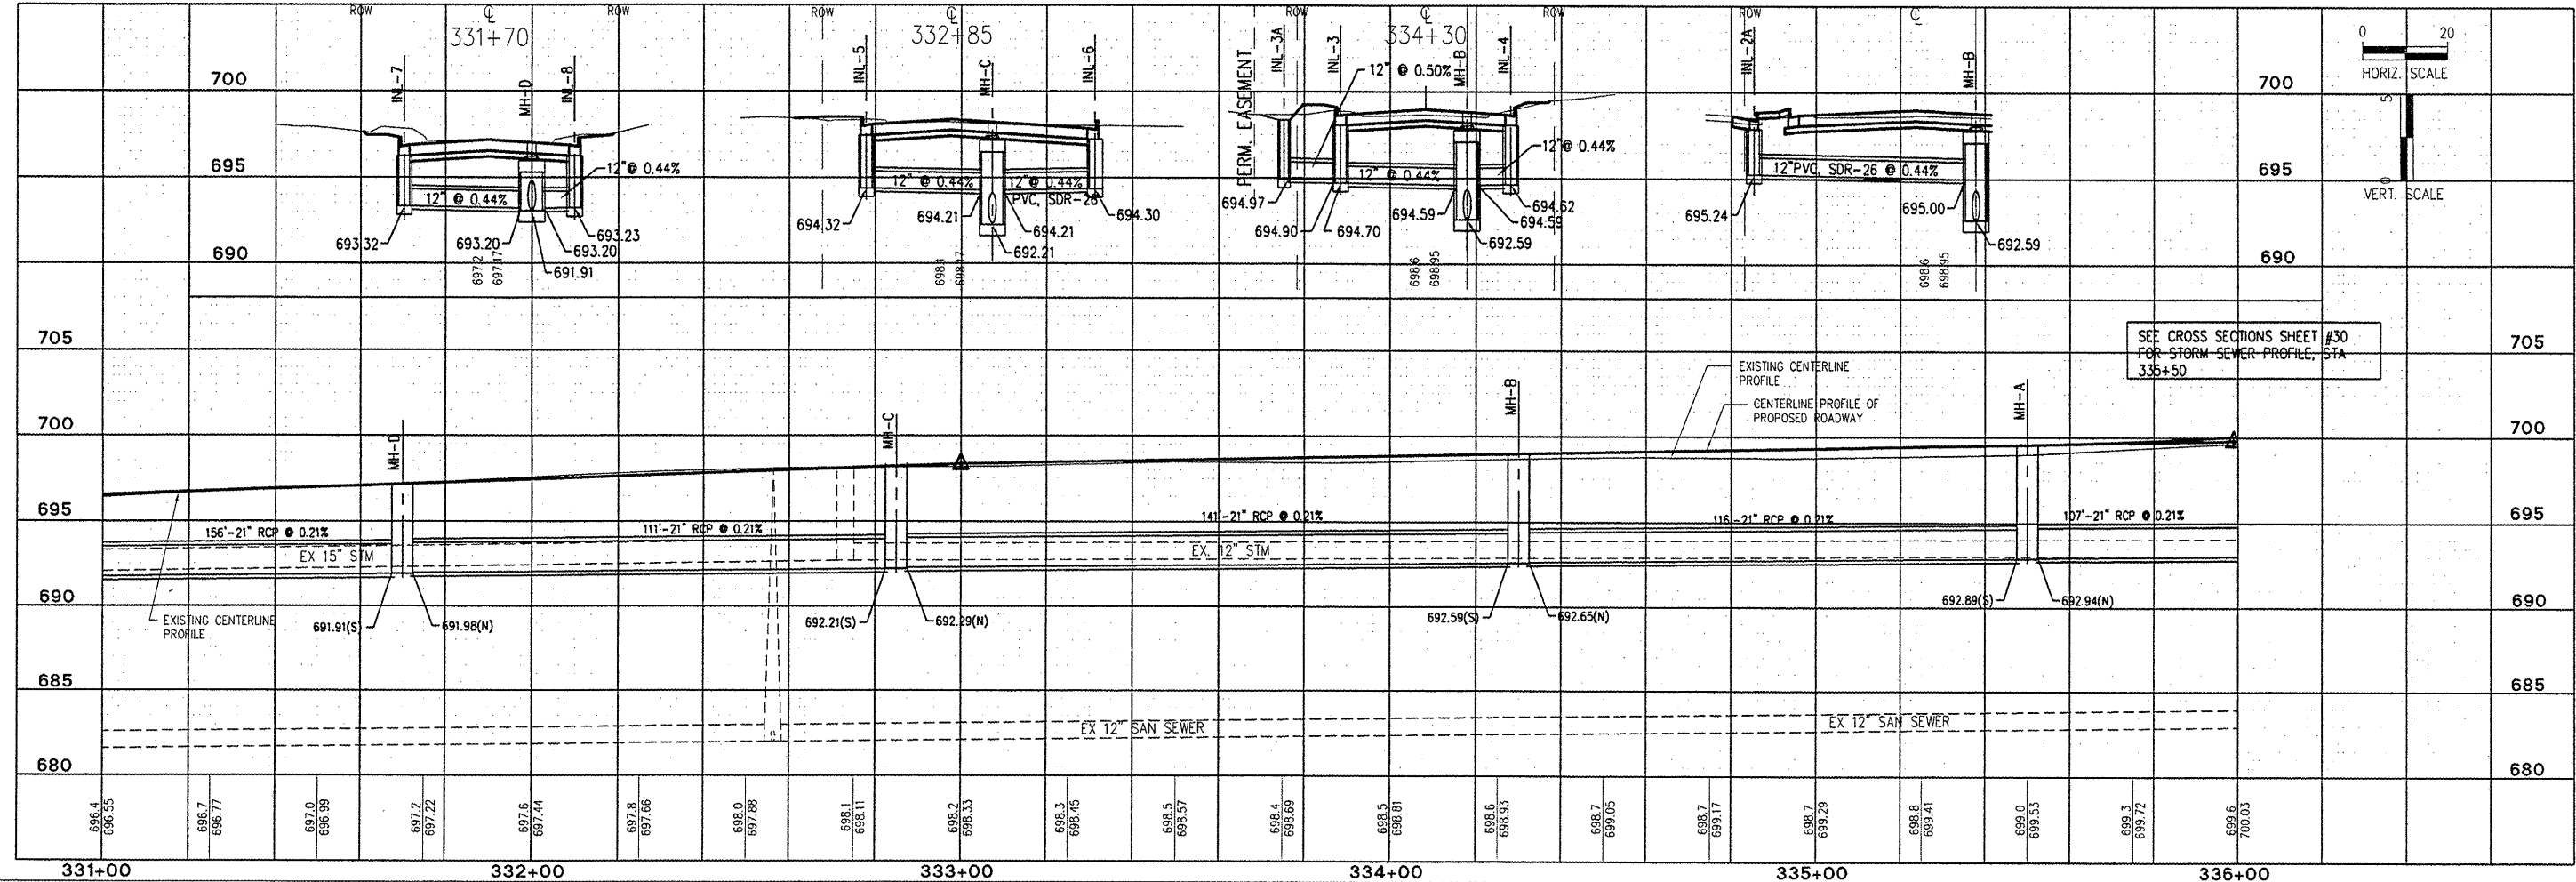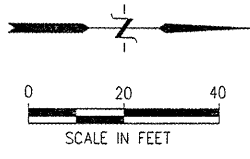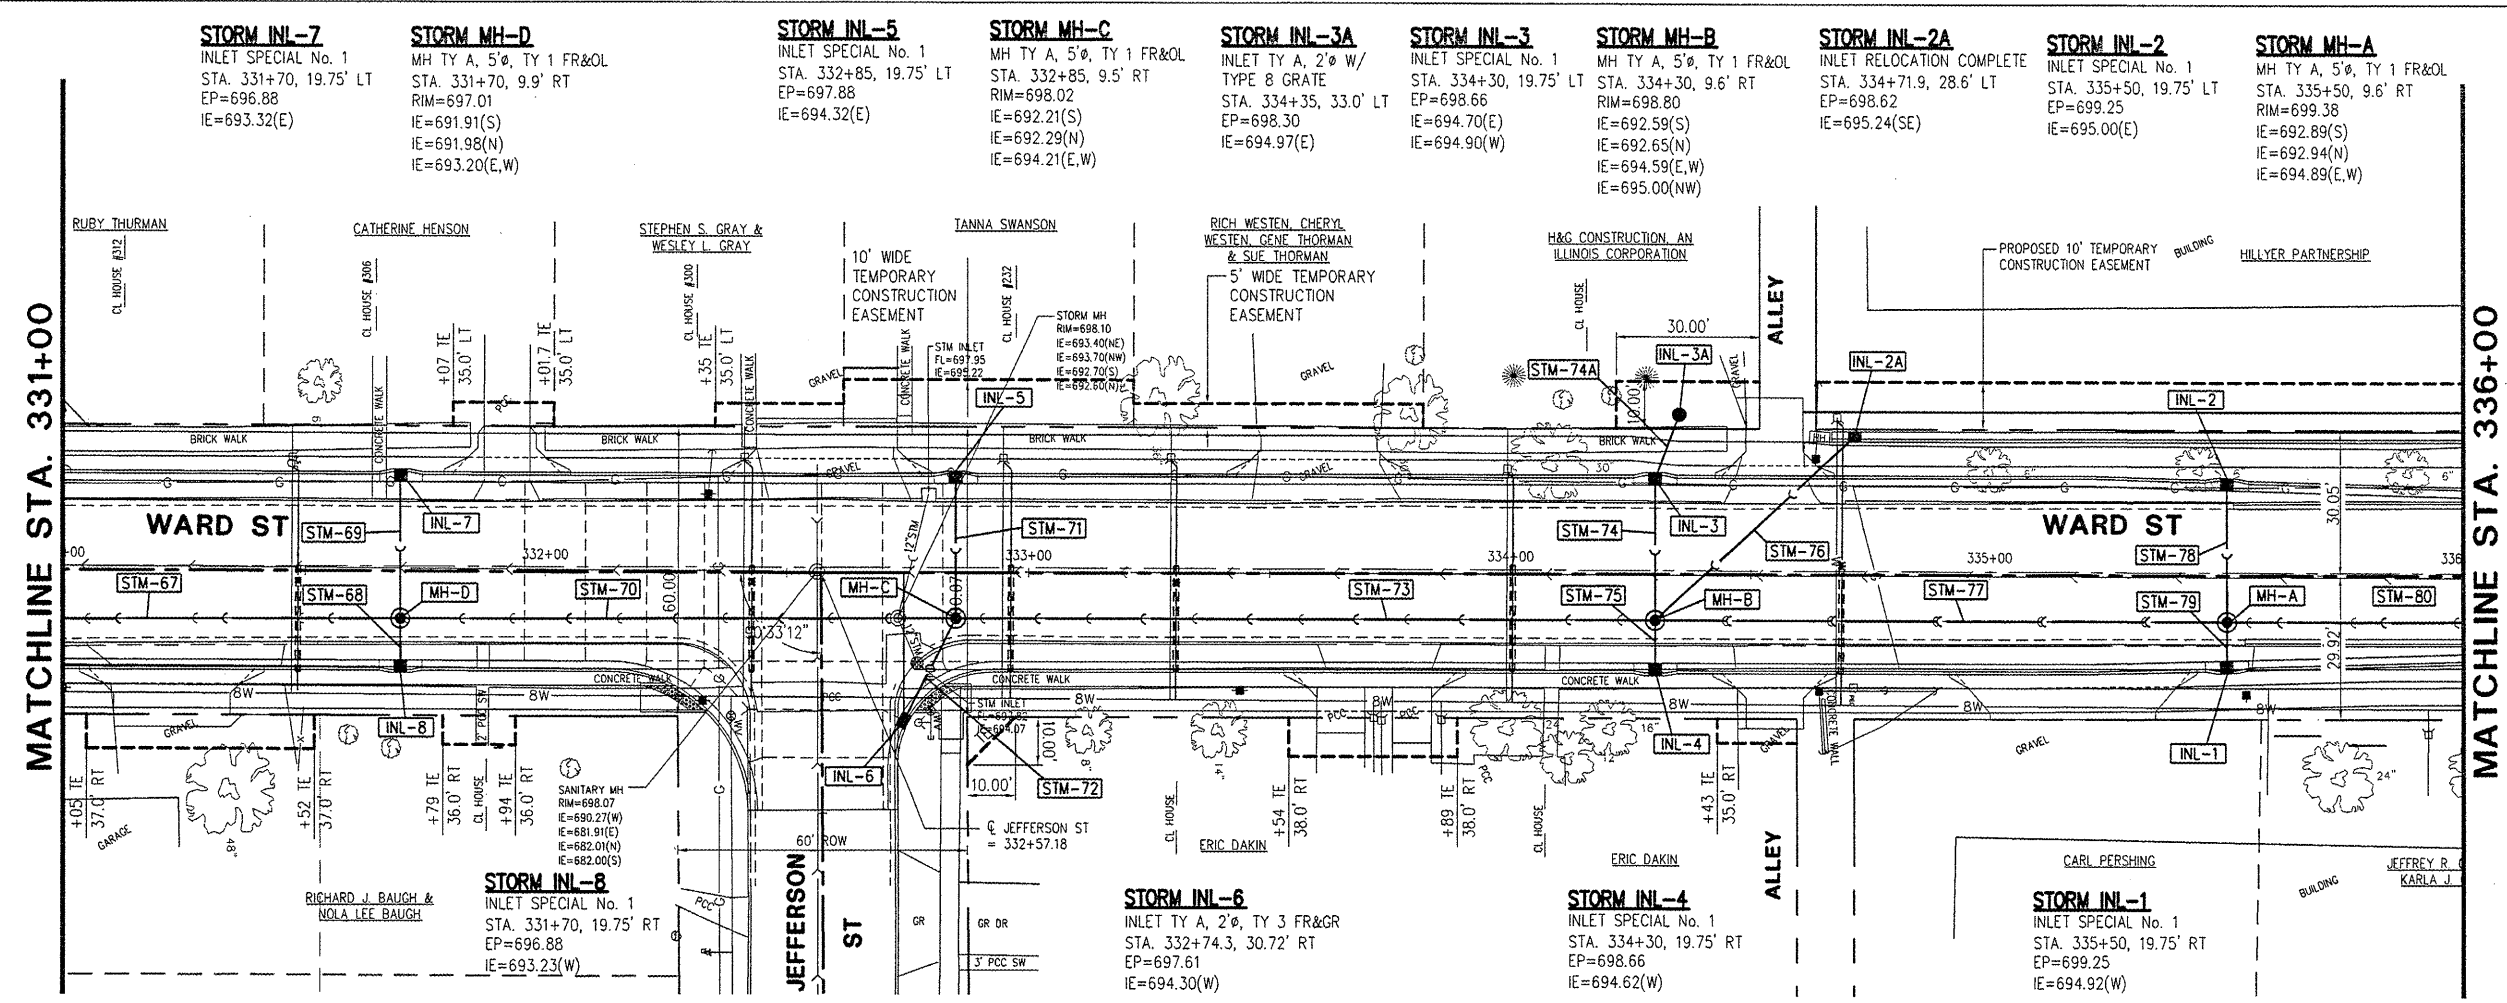

SEE CROSS SECTIONS SHEET #30  
 FOR STORM SEWER PROFILE, STA.  
 335+50