
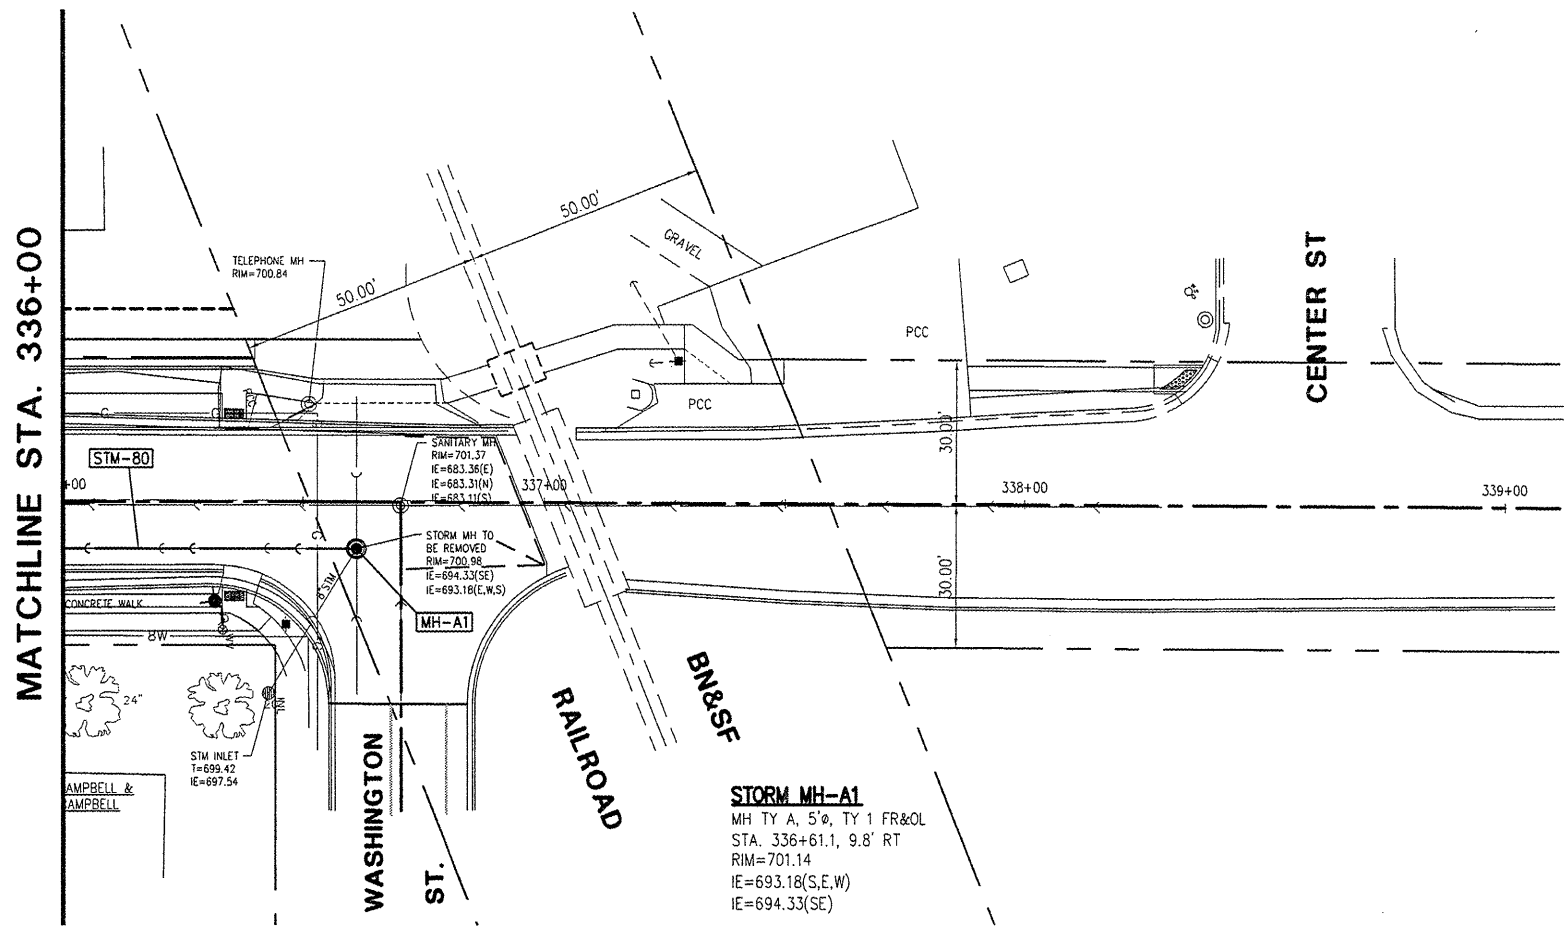


**McClure**  
 Engineering Associates, Inc.  
 Macomb, Illinois 61455  
 714 East Jackson Street  
 (309) 833-4594 FAX (309) 837-4909  
 Design Firm License #184-000016 Copyright 2009 by McClure Engineering Associates, Inc.



PLOTTING SCALE: 1" = 20'  
 DRAWN BY: TAB  
 CHECKED BY: JAR  
 DATE: MARCH 2009

NO.	REVISIONS	DATE

**WARD STREET IMPROVEMENTS - PHASE 2**  
**STORM SEWER PLAN AND PROFILE-STA. 336+00 TO 336+99.88**  
 CITY OF MACOMB  
 SOUTH WARD ST.  
 FILE NAME: \\MACOMB\WARDST\PHASE 2\WARD-ST-PH2.DWG FIELD BOOK No. 2257 JOB NUMBER: 02-28-000099

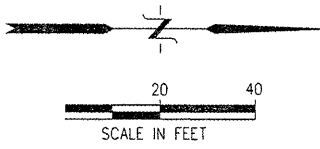

**STORM MH-A1**  
 MH TY A, 5'ø, TY 1 FR&OL  
 STA. 336+61.1, 9.8' RT  
 RIM=701.14  
 IE=693.18(S,E,W)  
 IE=694.33(SE)

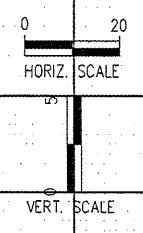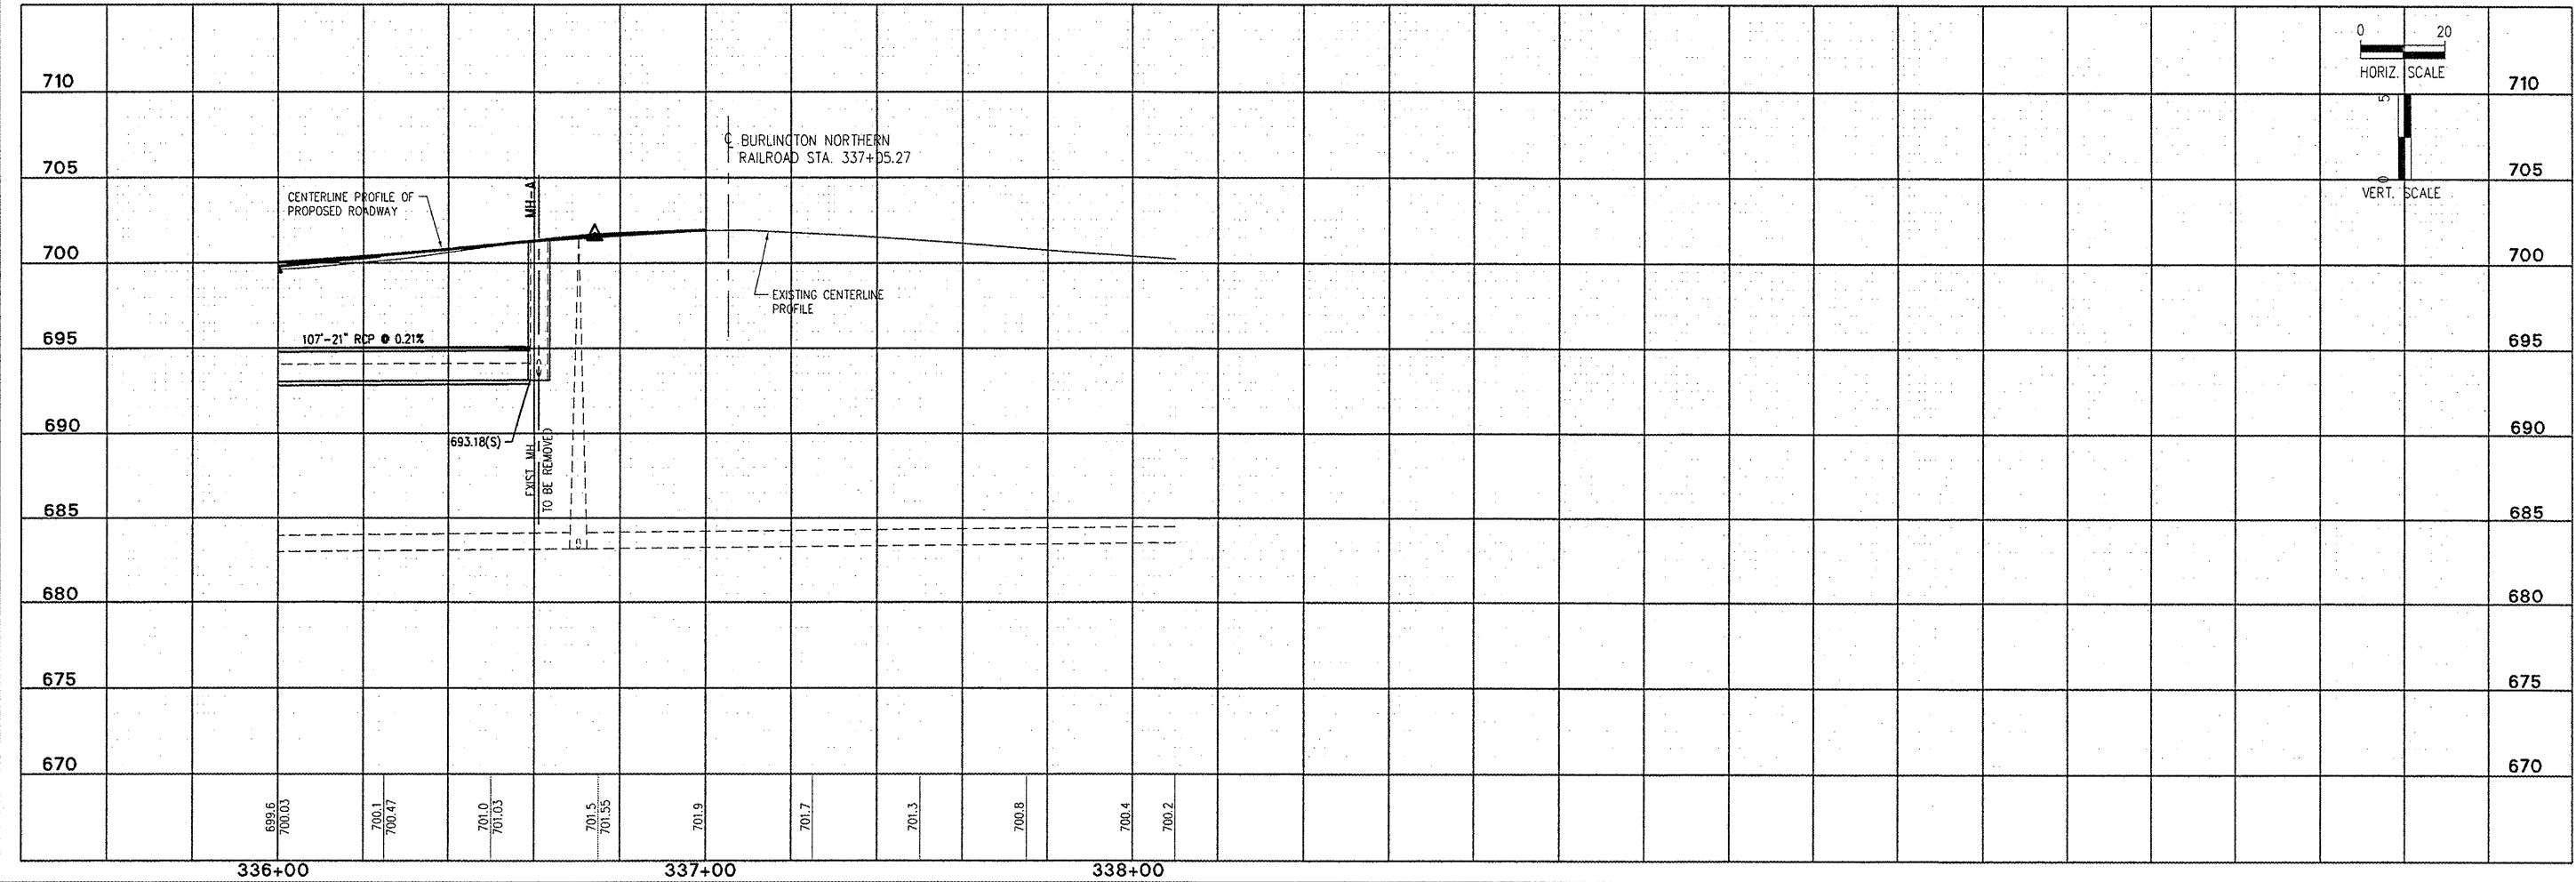

V:\PROJECTS\DRAWINGS\MACOMB\WARD ST\PHASE 2\WARD-ST-PH2.dwg, 3/25/2009 9:34:06 AM