


F.A. RTE.	SECTION	COUNTY	TOTAL SHEETS	SHEET NO.
57	991821 R-389-100-1-00-2	WILL	303	125
STA.	TO STA.			
FED. ROAD DIST. NO.	ILLINOIS FED. AID PROJECT			

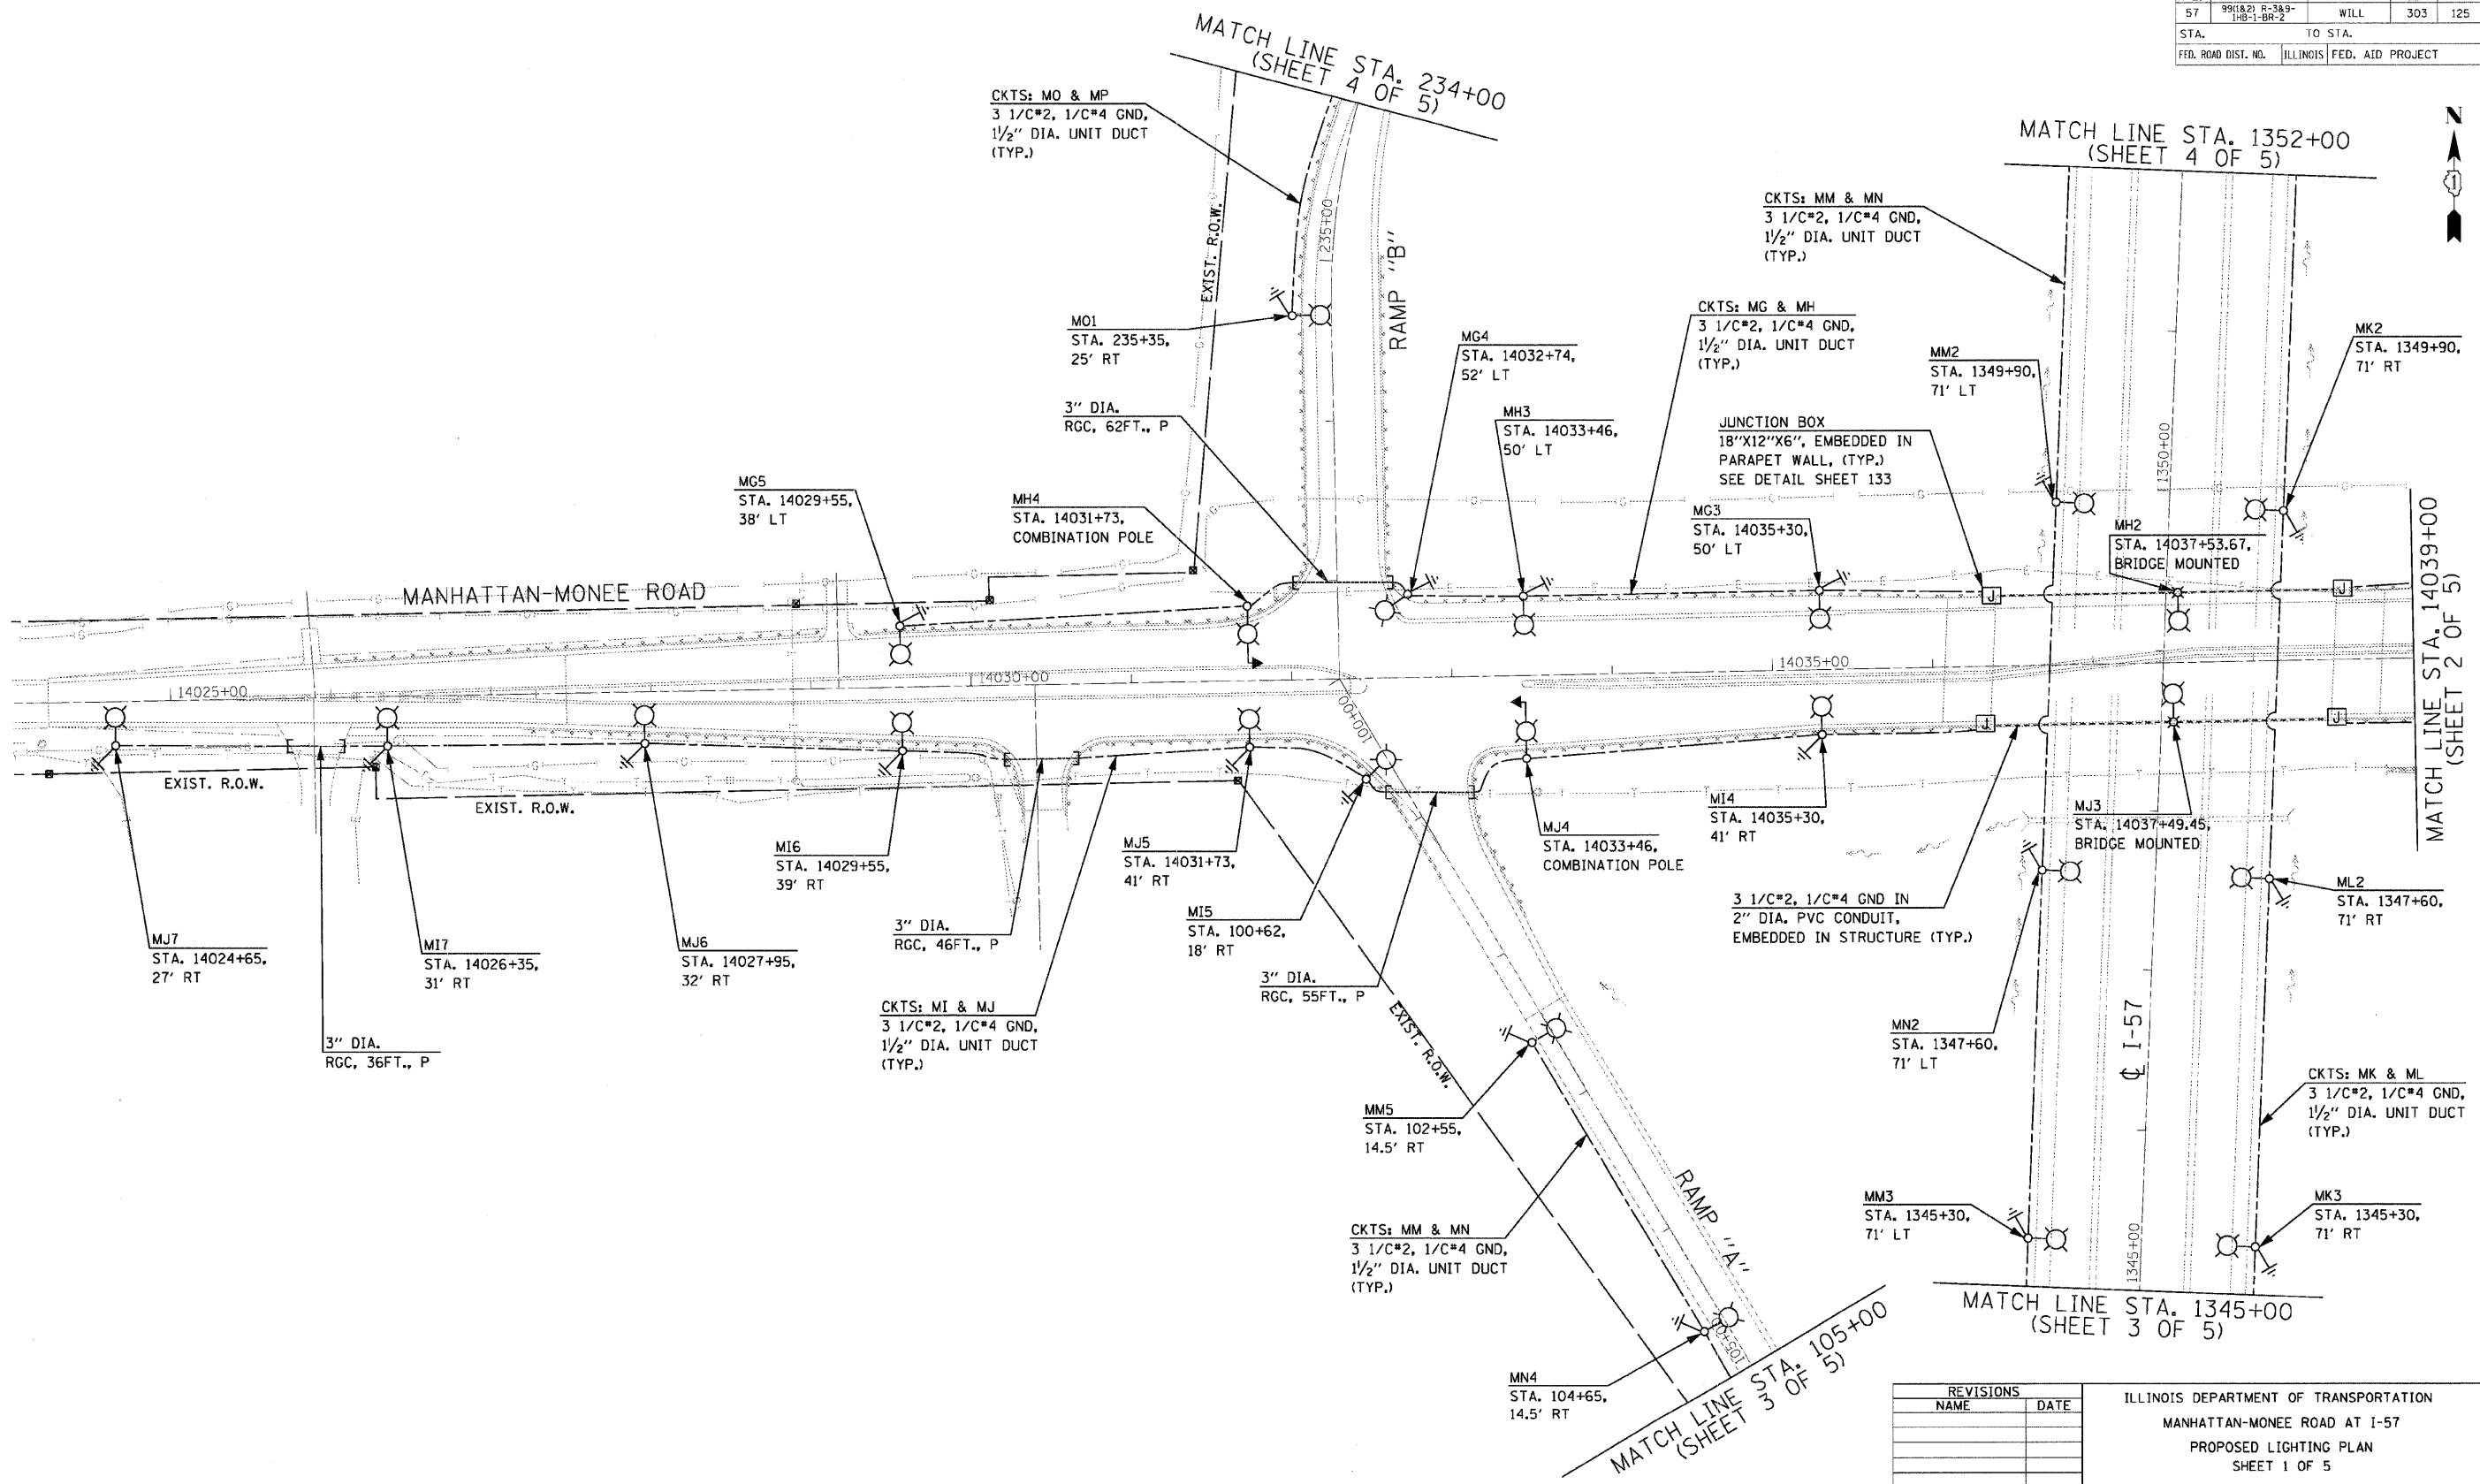

REVISIONS	
NAME	DATE

ILLINOIS DEPARTMENT OF TRANSPORTATION
 MANHATTAN-MONEE ROAD AT I-57
 PROPOSED LIGHTING PLAN
 SHEET 1 OF 5

SCALE: 1"=50'
 DATE 10/09/2006

DRAWN BY: KGP
 DESIGNED BY: PKG/KGP
 CHECKED BY: PKG

go GANDHI AND ASSOCIATES, INC.
 ENGINEERS AND PLANNERS
 6035 N. NORTHWEST HIGHWAY
 SUITE 306
 CHICAGO, ILLINOIS 60631 TEL. (773) 774-590