


F.A. RTE.	SECTION	COUNTY	TOTAL SHEETS	SHEET NO.
57	991&21 3-389-100-1-00-2	WILL	303	126
STA.	TO STA.			
FED. ROAD DIST. NO.	ILLINOIS FED. AID PROJECT			

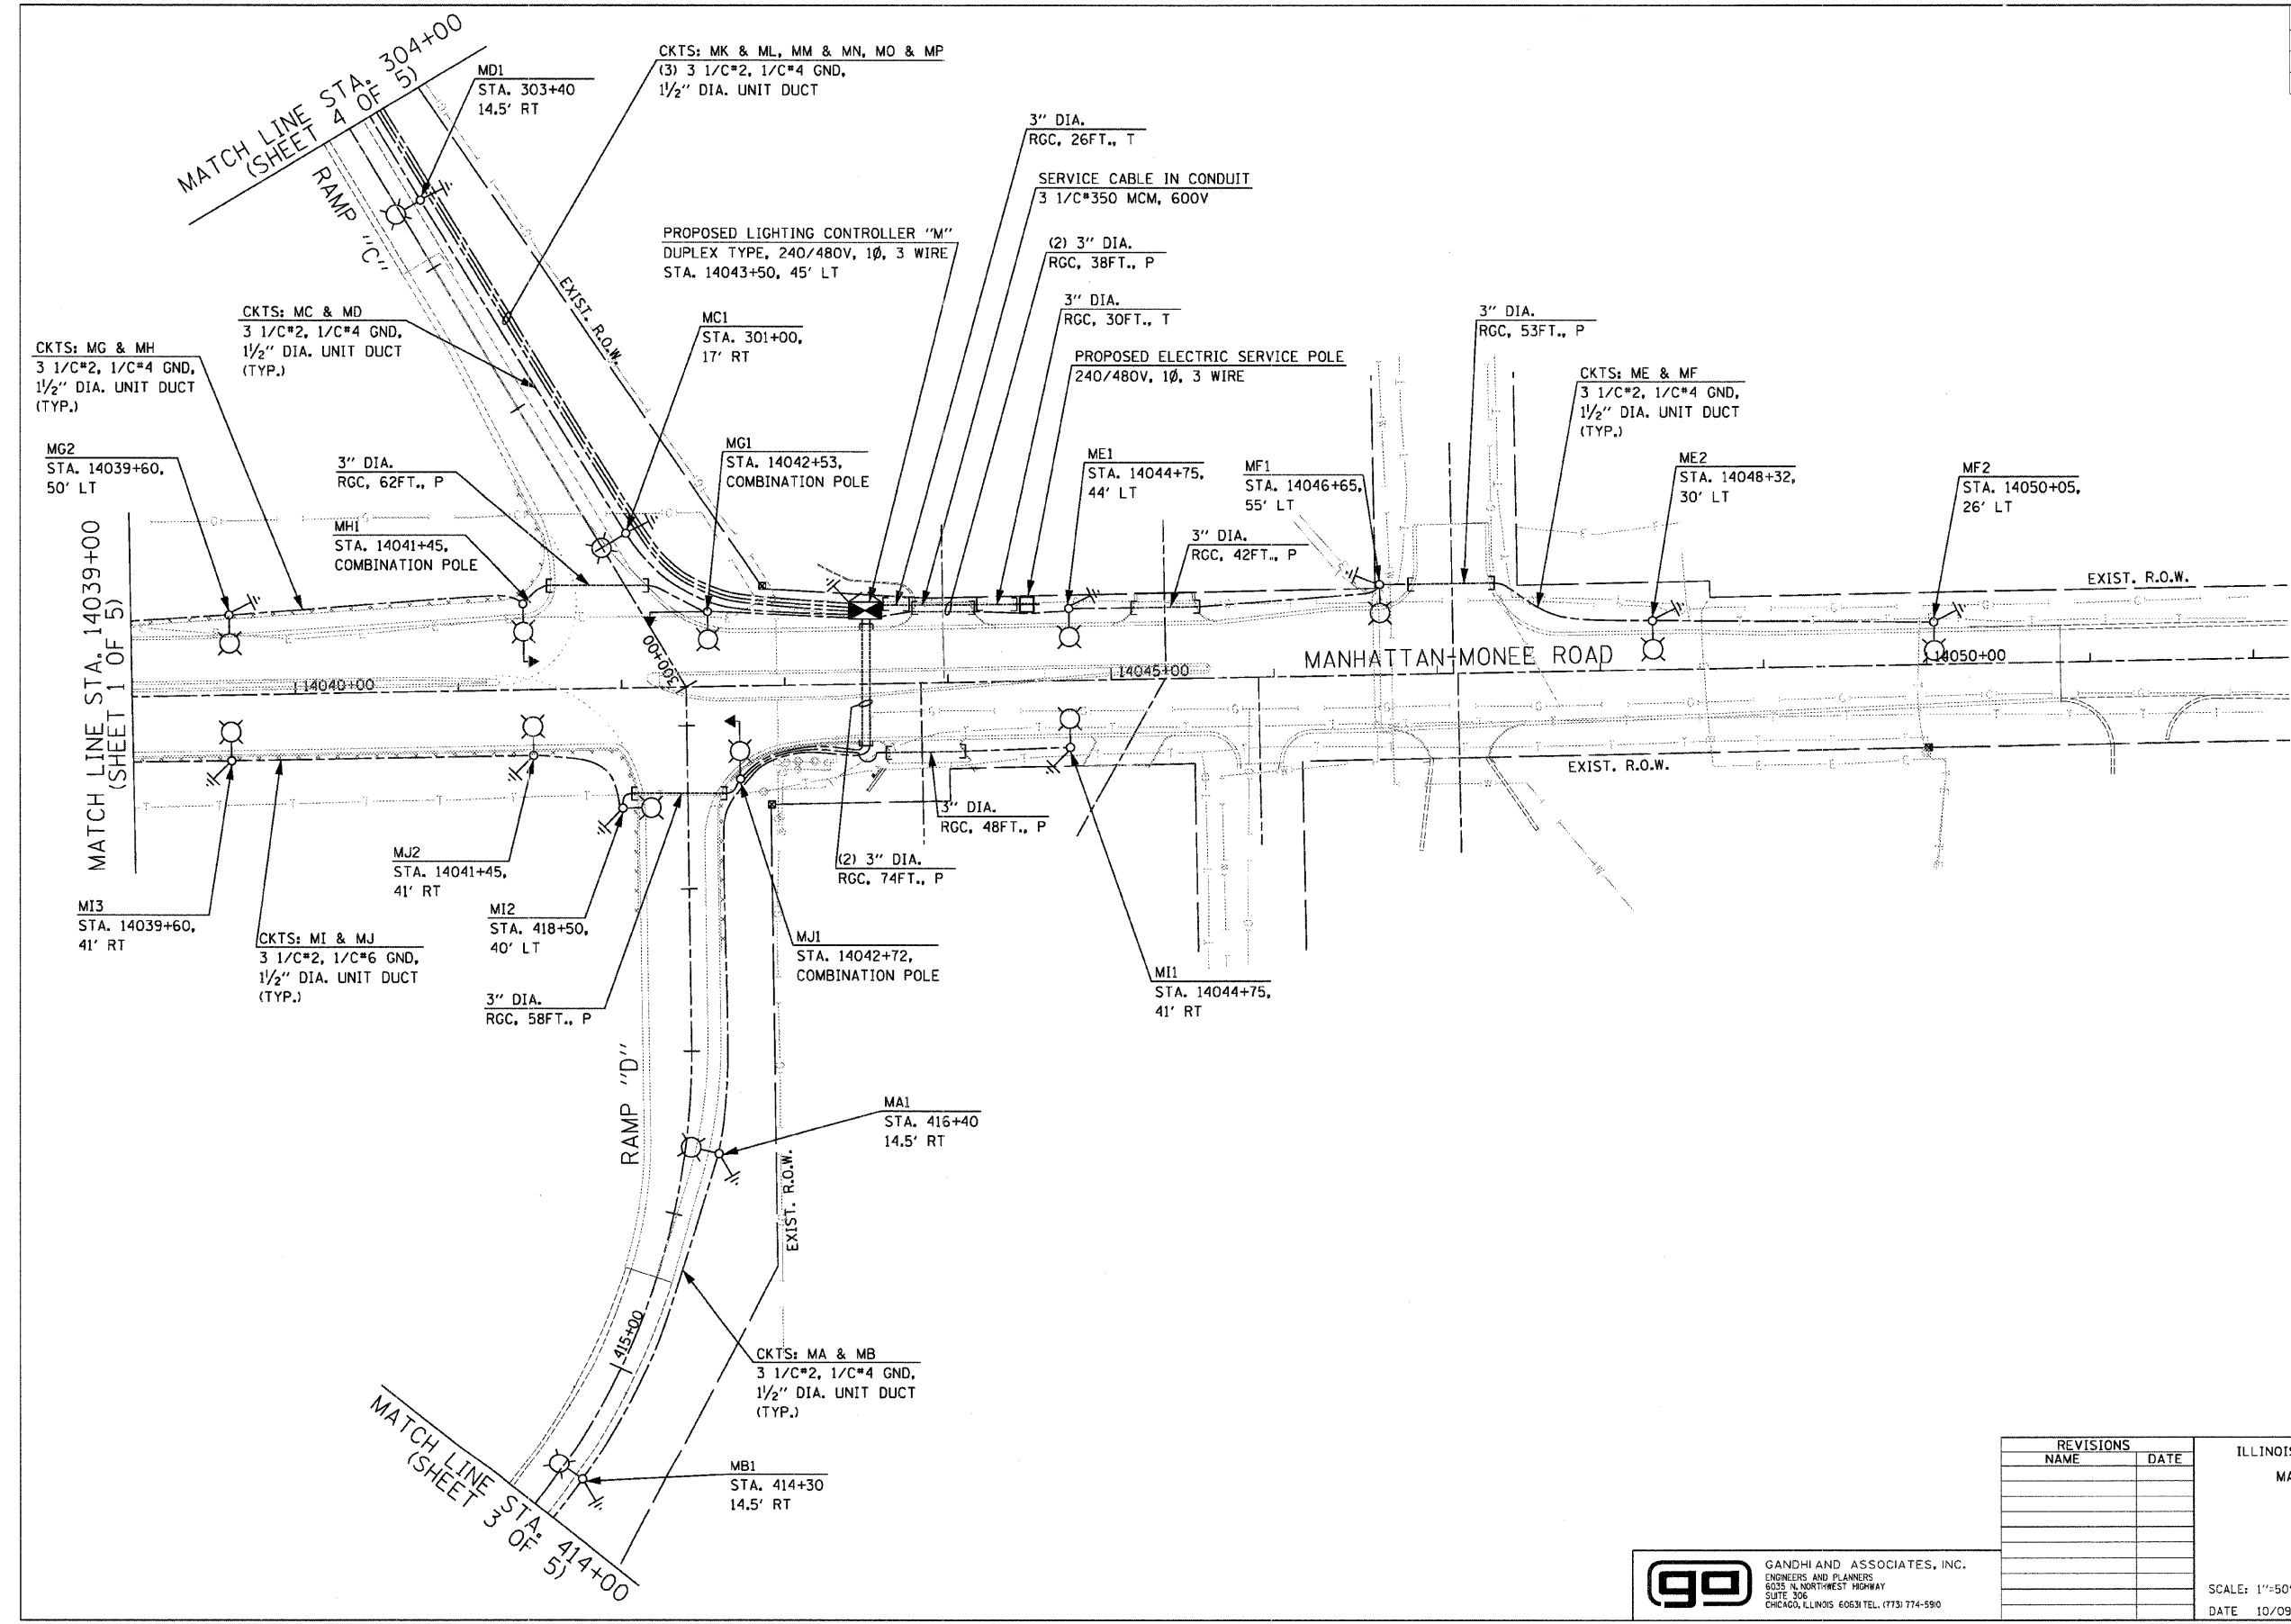

REVISIONS	
NAME	DATE

ILLINOIS DEPARTMENT OF TRANSPORTATION
 MANHATTAN-MONEE ROAD AT I-57
 PROPOSED LIGHTING PLAN
 SHEET 2 OF 5

ga GANDHI AND ASSOCIATES, INC.
 ENGINEERS AND PLANNERS
 6035 N. NORTHWEST HIGHWAY
 SUITE 306
 CHICAGO, ILLINOIS 60631 TEL. (773) 774-5910

SCALE: 1"=50'
 DATE 10/09/2006
 DRAWN BY: KGP
 DESIGNED BY: PKG/KGP
 CHECKED BY: PKG