


F.A. RTE.	SECTION	COUNTY	TOTAL SHEETS	SHEET NO.
57	991&2) R-3&9-1HB-1-BR-2	WILL	303	127
STA.		TO STA.		
FED. ROAD DIST. NO.		ILLINOIS FED. AID PROJECT		

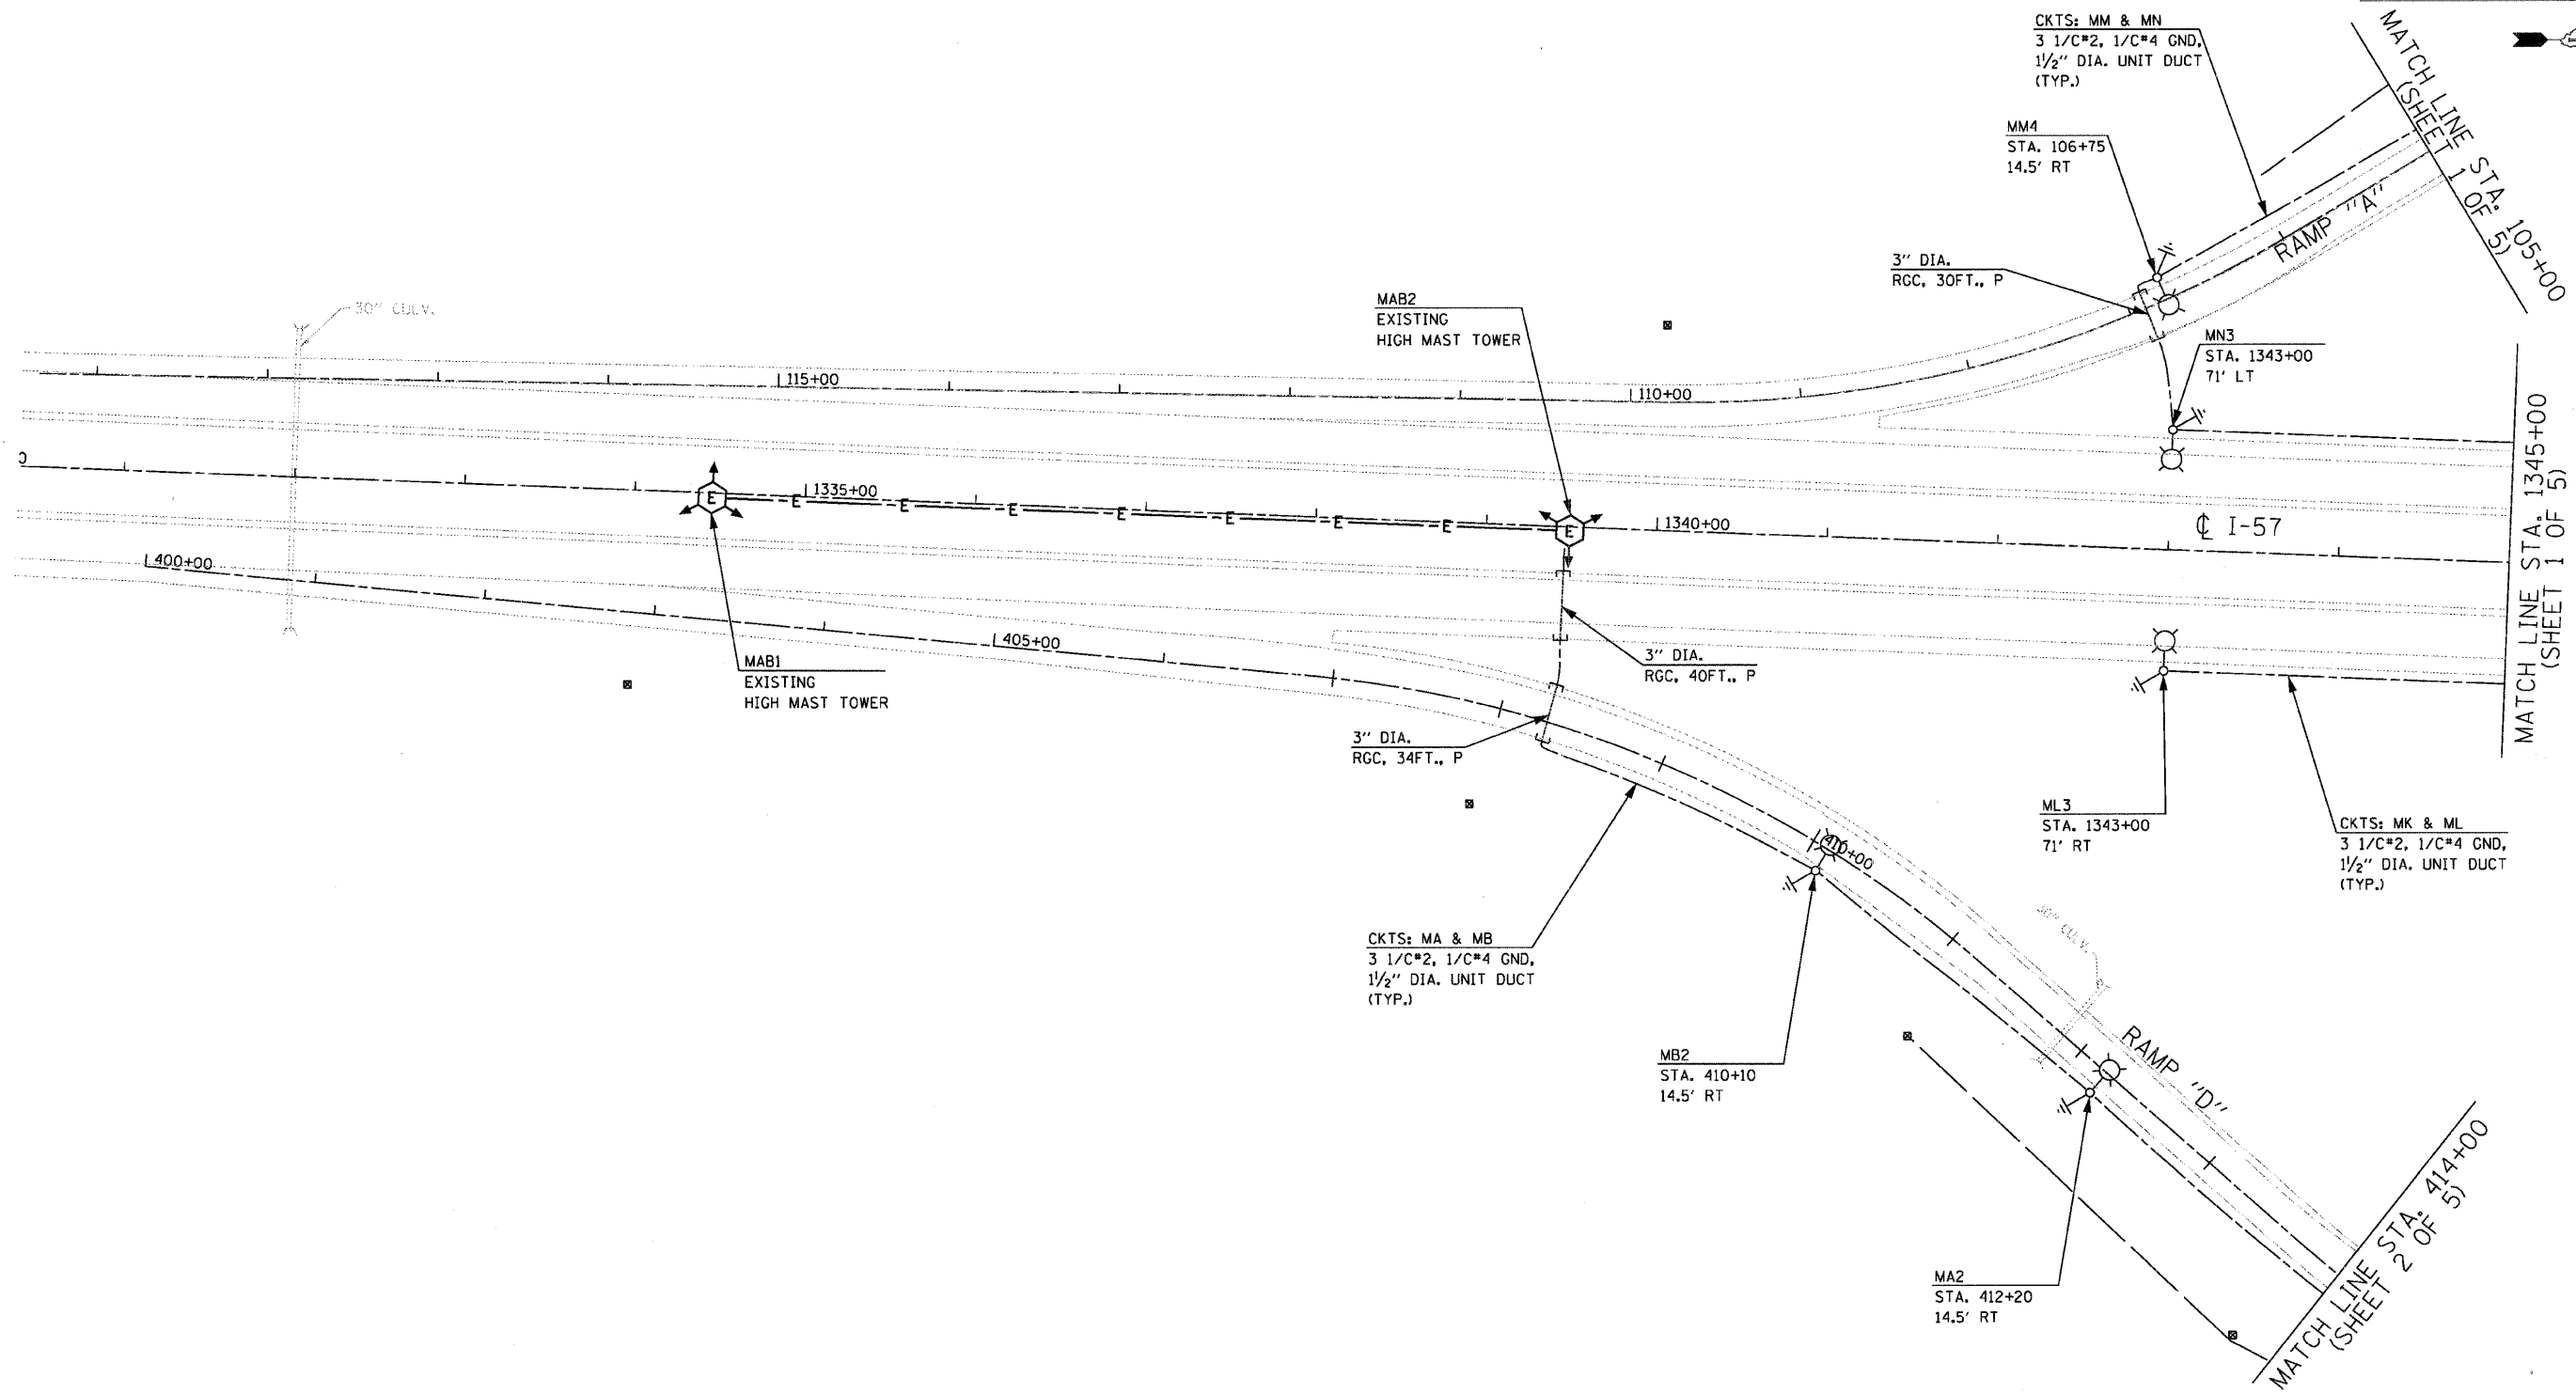

REVISIONS	
NAME	DATE

ILLINOIS DEPARTMENT OF TRANSPORTATION
 MANHATTAN-MONEE ROAD AT I-57
 PROPOSED LIGHTING PLAN
 SHEET 3 OF 5

SCALE: 1"=50'
 DATE: 10/09/2006

DRAWN BY: KGP
 DESIGNED BY: PKG/KGP
 CHECKED BY: PKG

ga GANDHI AND ASSOCIATES, INC.
 ENGINEERS AND PLANNERS
 8035 N. NORTHWEST HIGHWAY
 SUITE 306
 CHICAGO, ILLINOIS 60631 TEL. (773) 774-5900