


F.A. RTE.	SECTION	COUNTY	TOTAL SHEETS	SHEET NO.
57	#	WILL	303	131
STA.		TO STA.		
FED. ROAD DIST. NO.		ILLINOIS FED. AID PROJECT		

981821 R-349-1B-1-BR-2

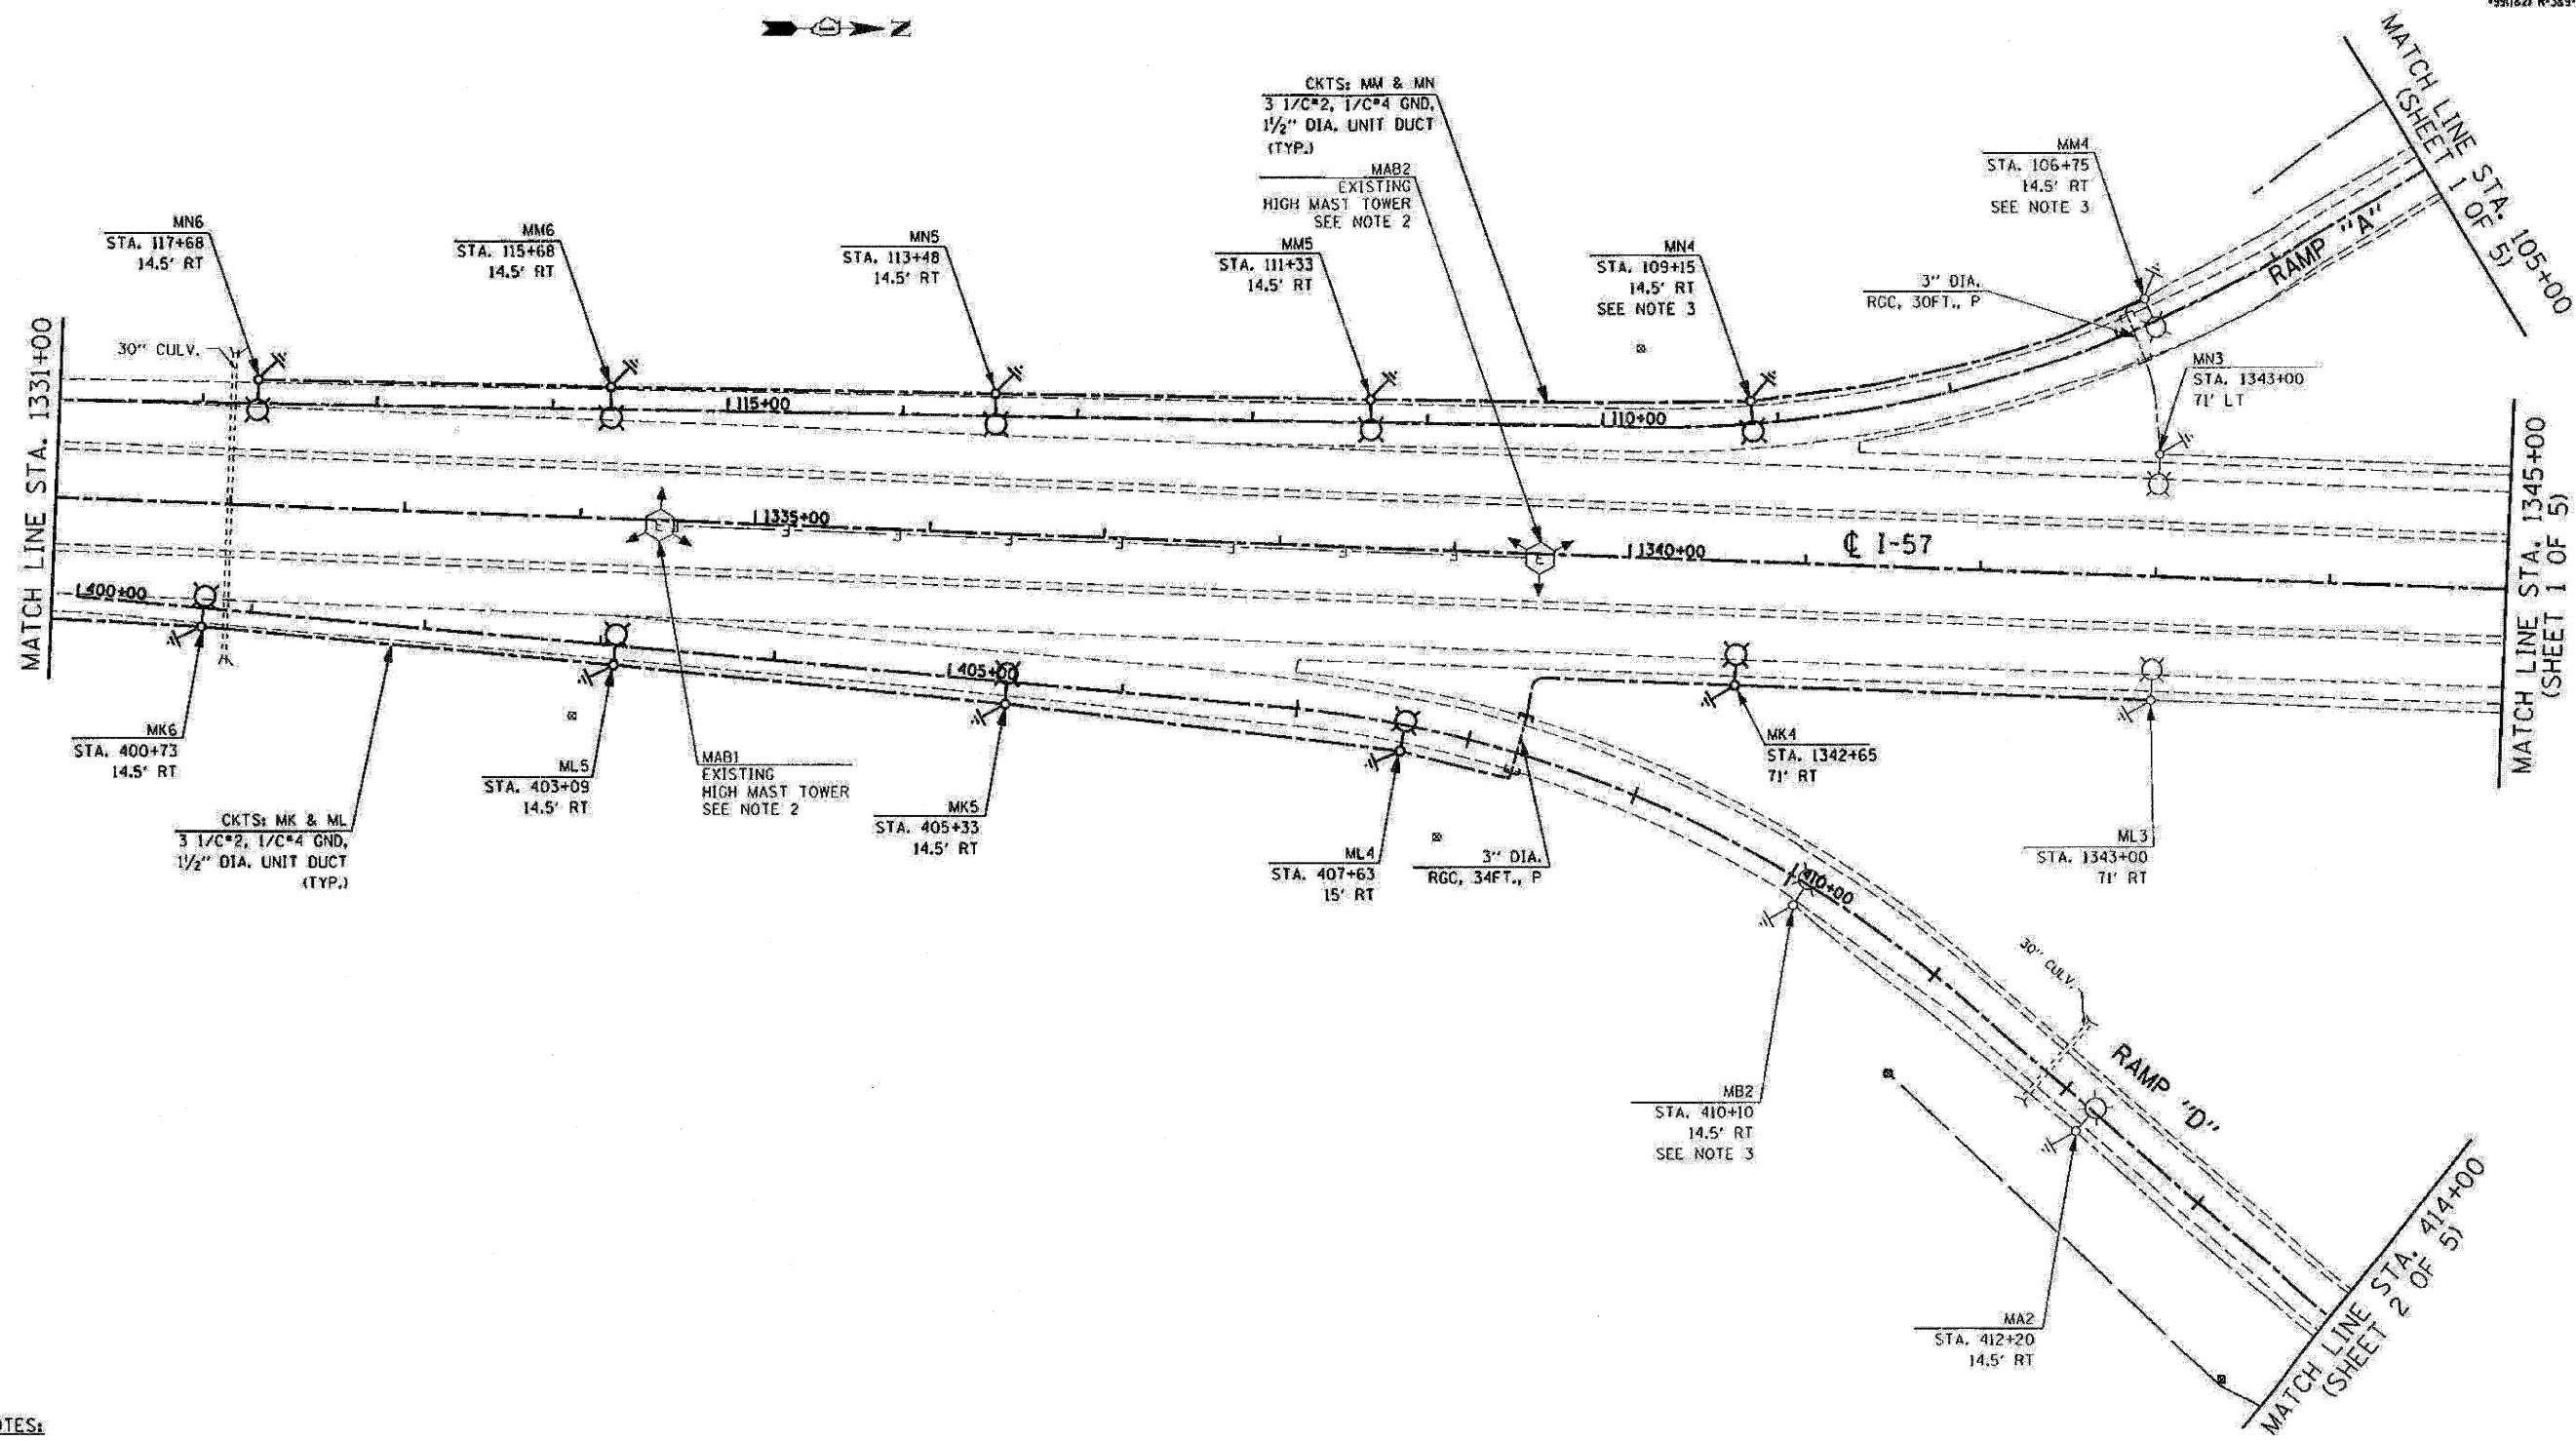

NOTES:

- SEE PLAN NOTES ON SHEET 130.
- THE EXISTING HIGH MAST TOWERS WILL BE REMOVED BY THE IDOT MAINTENANCE CONTRACTOR UNDER SEPARATE CONTRACT. THE CONTRACTOR SHALL COORDINATE THE REMOVAL OF THE EXISTING TOWERS WITH THE IDOT MAINTENANCE CONTRACTOR. THE CONTRACTOR SHALL FACILITATE THE IDOT MAINTENANCE CONTRACTOR'S REMOVAL OF THE TOWERS. SEE NOTE 5 ON SHEET 130 FOR ADDITIONAL INFORMATION.
- THE CONTRACTOR SHALL INSTALL ADDITIONAL PVC RACEWAY IN THE FOUNDATIONS FOR LIGHT POLES MM4, MM4, MB2, MB2 AND MB2. THE WORK AND MATERIAL REQUIRED TO INSTALL AN ADDITIONAL RACEWAY WILL BE INCIDENTAL TO THE PAY ITEM "LIGHT POLE FOUNDATION, 24" DIAMETER", AND NO EXTRA COMPENSATION WILL BE MADE. ANY ADDITIONAL PVC RACEWAY INSTALLED FOR FUTURE USE SHALL BE CAPPED.

REVISIONS	
NAME	DATE

ILLINOIS DEPARTMENT OF TRANSPORTATION
MANHATTAN-MONEE ROAD AT I-57
PROPOSED LIGHTING PLAN
(MAINLINE I-57)

SCALE: 1"=50'
 DATE: 1/30/2008

DRAWN BY:
 DESIGNED BY:
 CHECKED BY:

PLOT DATE: 1/30/2008
 FILE NAME: c:\pwork\mmonee\electrical\2007\131\man-monee.dgn
 PLOT SCALE: 1/30/2008 11:58:02 AM
 USER NAME: bward