


F.A. RTE.	SECTION	COUNTY	TOTAL SHEETS	SHEET NO.
57	*	WILL	303	133
STA. TO STA.		TO STA.		
FED. ROAD DIST. NO.		ILLINOIS FED. AID PROJECT		
-991621 R-349-1HG-1-BR-2				

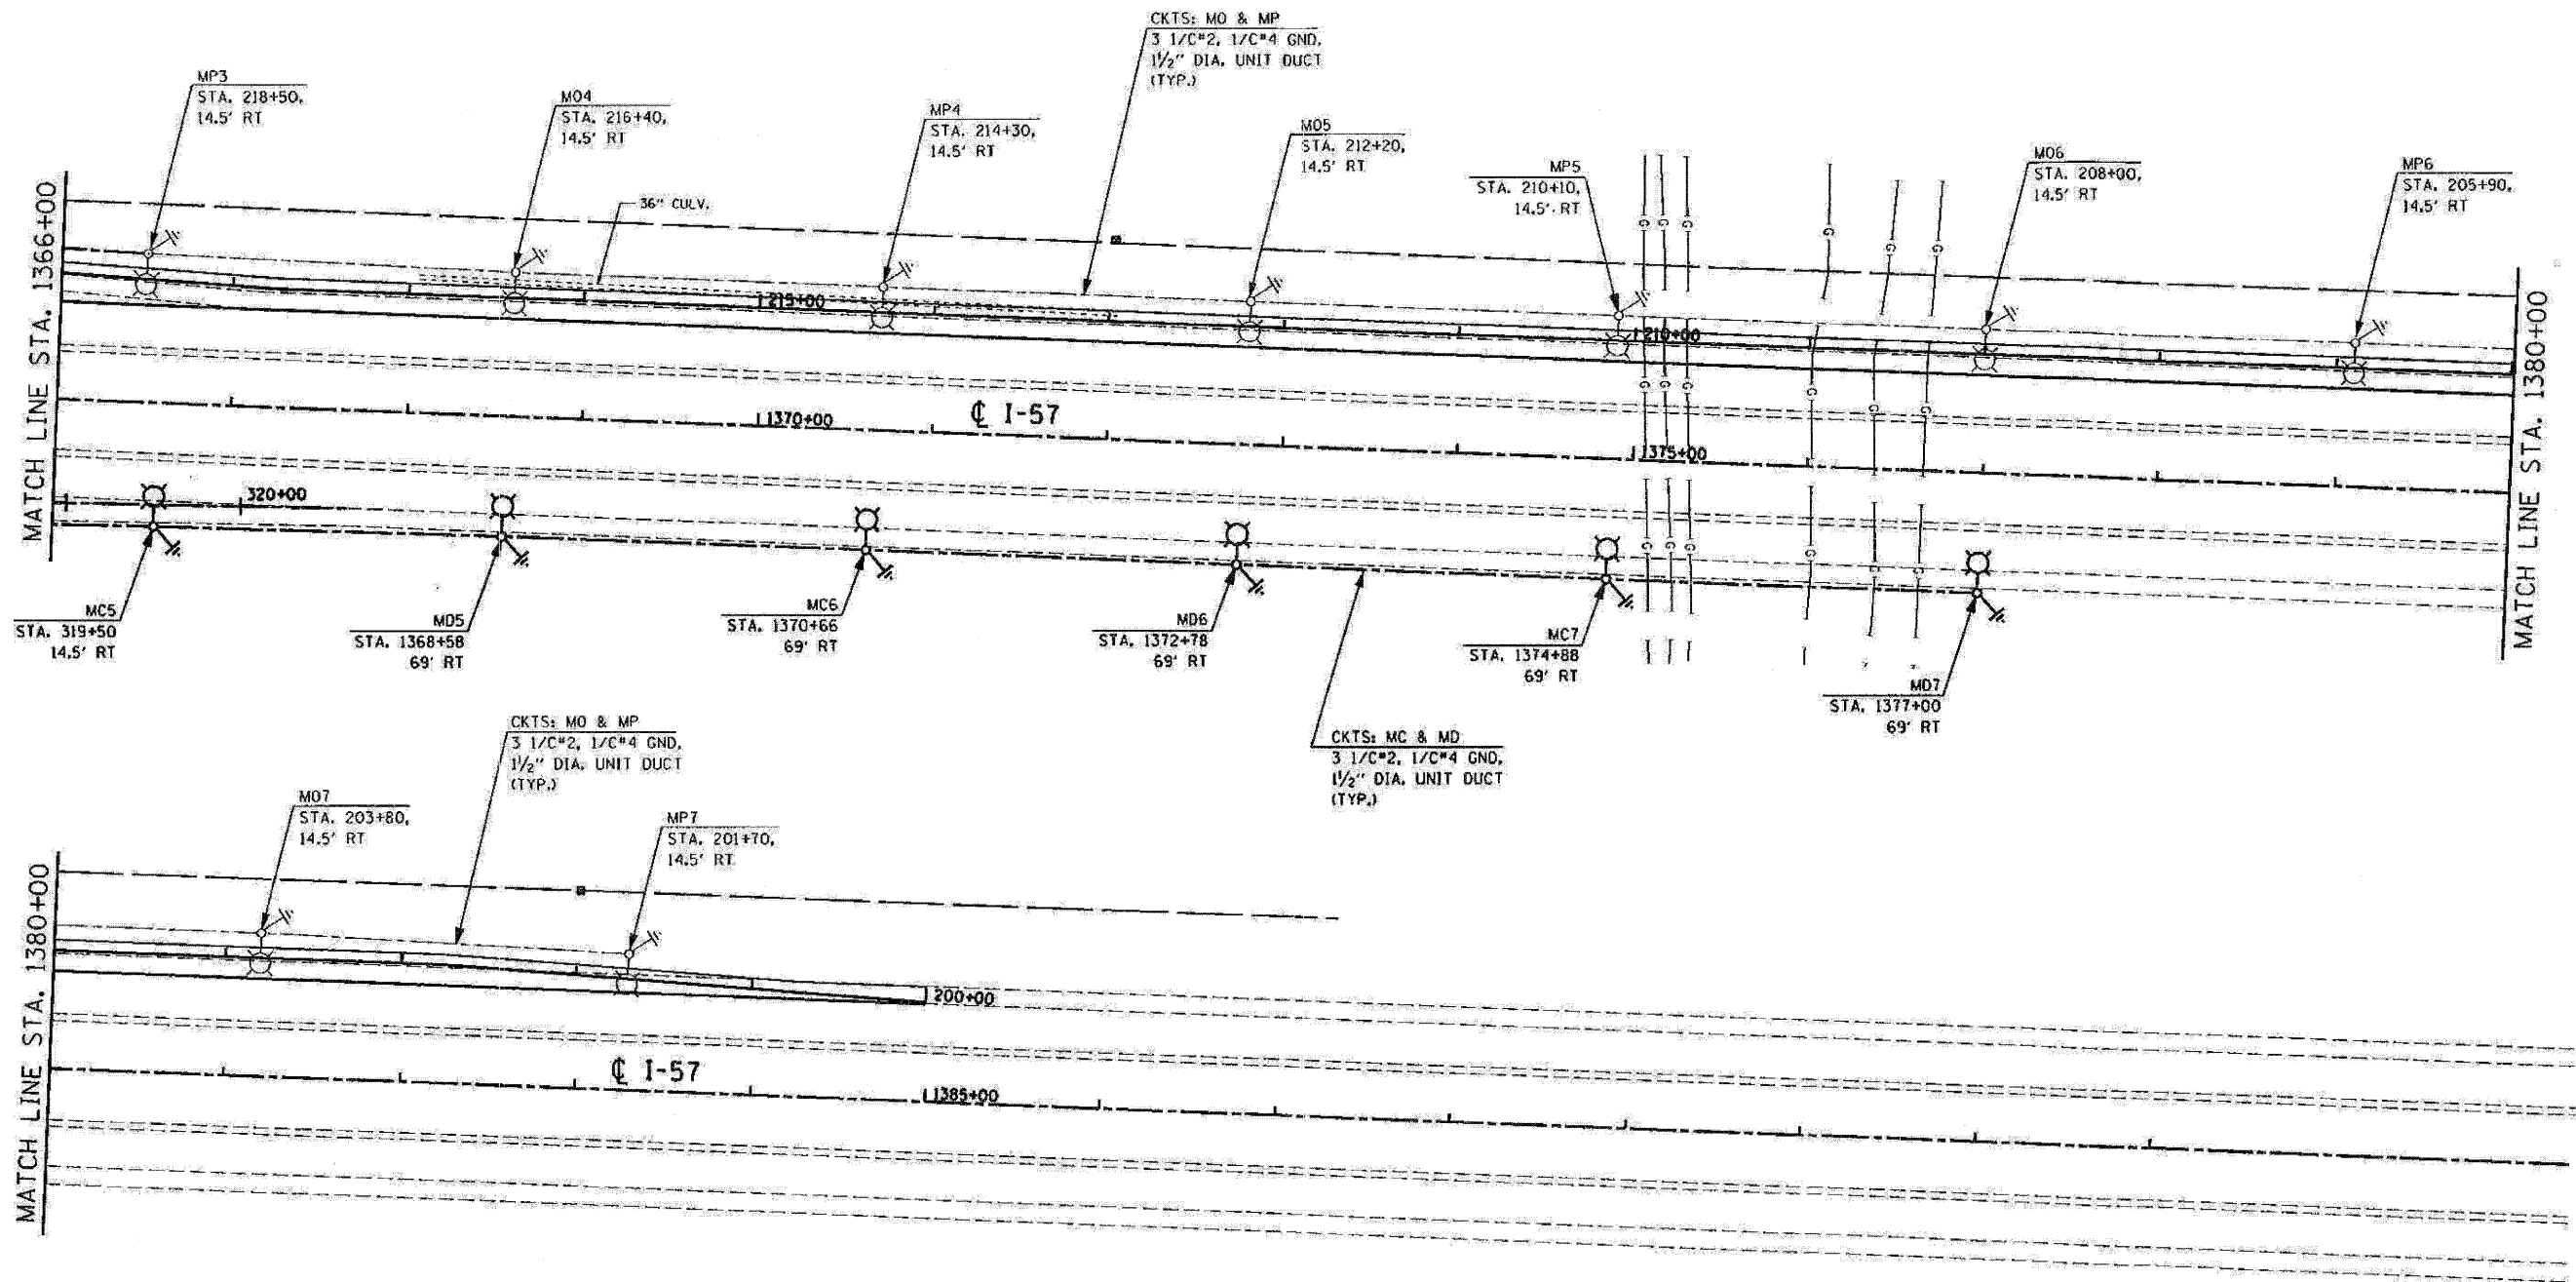

NOTES:

1. SEE PLAN NOTES ON SHEET 130.

REVISIONS	
NAME	DATE

ILLINOIS DEPARTMENT OF TRANSPORTATION
**MANHATTAN-MONEE ROAD AT I-57
 PROPOSED LIGHTING PLAN
 (MAINLINE I-57)**
 SCALE: 1"=50'
 DATE: 1/30/2008
 DRAWN BY:
 DESIGNED BY:
 CHECKED BY:

PLOT DATE: 1/30/2008
 PLOT SCALE: 1"=50'
 USER: NAME: baured