


F.A.U. RTE.	SECTION	COUNTY	TOTAL SHEETS	SHEET NO.
2552	00-00114-00-PV	DuPAGE	563	232
STA.		TO STA.		
FED. ROAD DIST. NO.	ILLINOIS	FED. AID PROJECT		

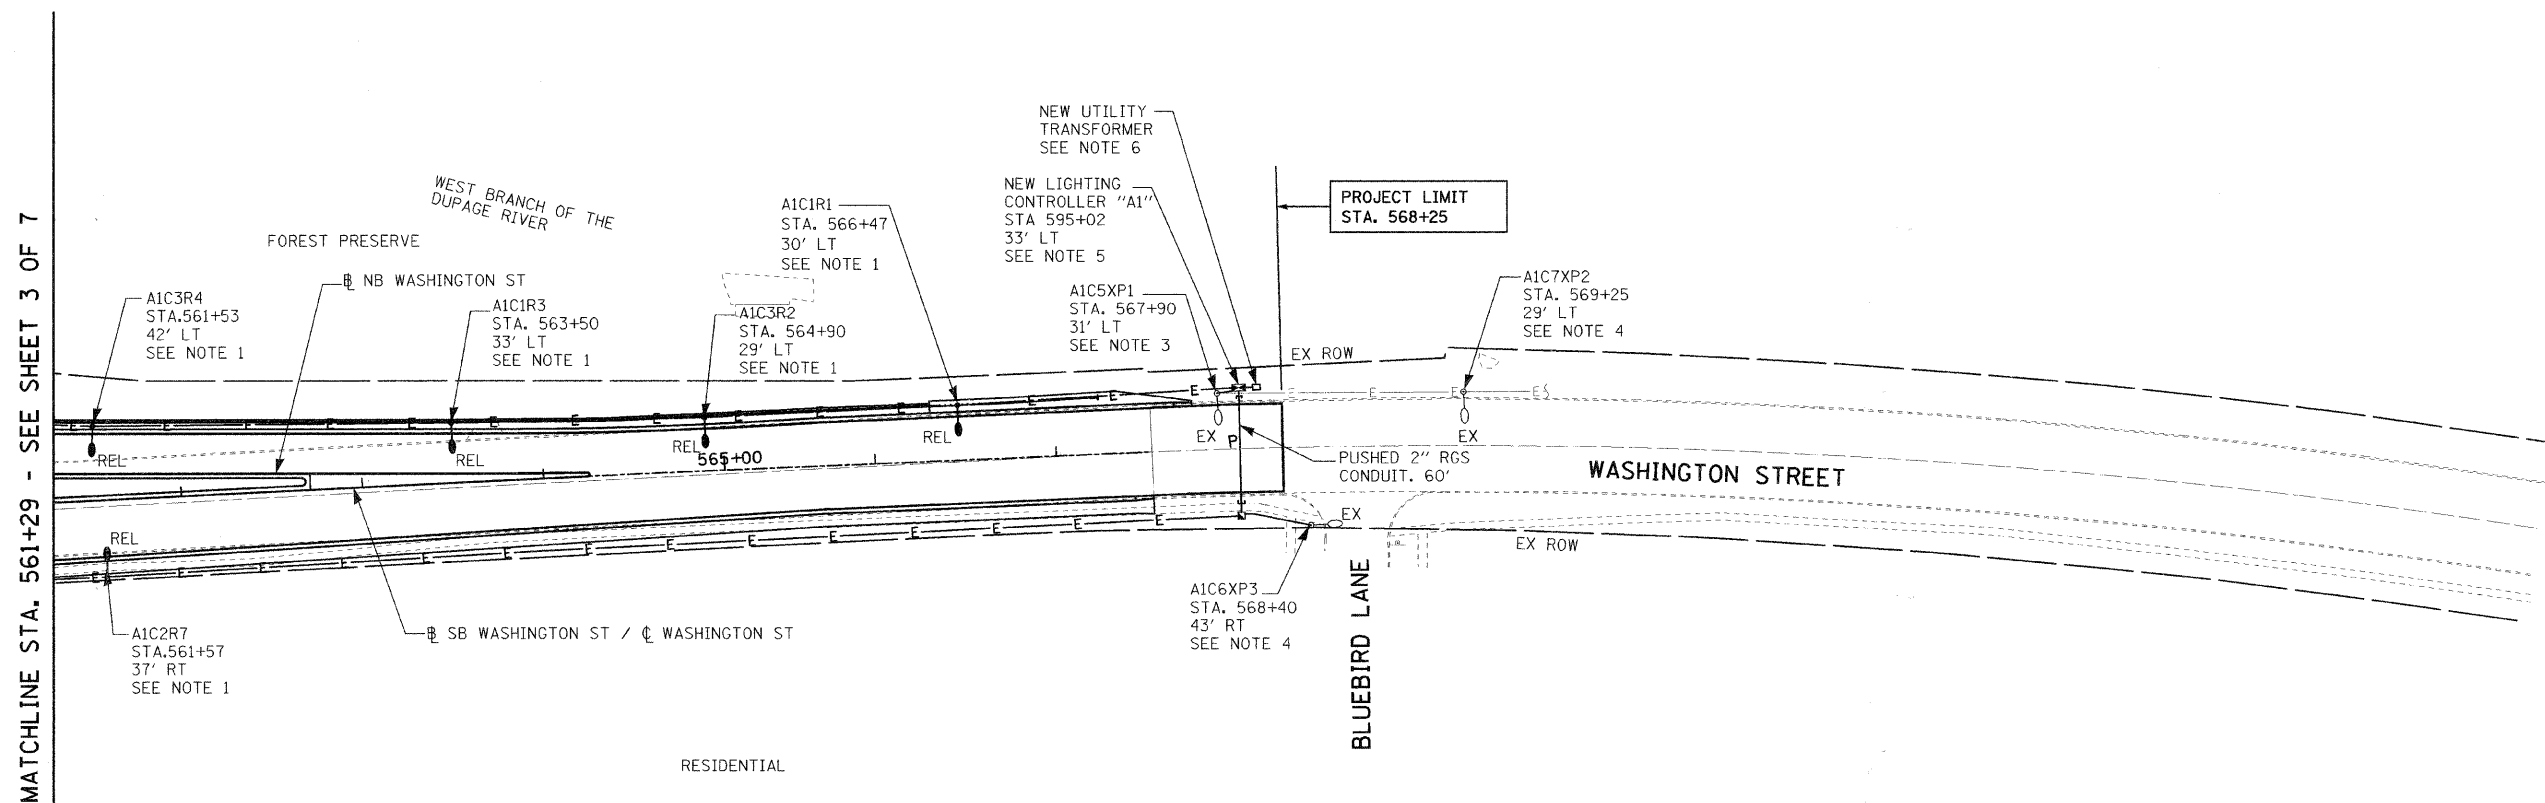


MATCHLINE STA. 561+29 - SEE SHEET 3 OF 7

- NOTES:
- EXISTING RELOCATED LIGHT POLES (R1, R2, R3, R4 AND R7) SHALL BE CONNECTED TO NEW LIGHTING CONTROLLER "A1" AS INDICATED ON PLAN.
 - PROVIDE NEW CIRCUIT WIRES (3-1/C NO. 6 AWG, 1/C NO.6 AWG GROUND) WITHIN 2" DIAMETER UNIT DUCT.
 - EXISTING LIGHT POLE (XP1) AND LUMINAIRE TO REMAIN. DISCONNECT EXISTING CIRCUIT CONNECTION AND RECONNECT TO NEW LIGHTING CONTROLLER "A1". CLEAN AND REPAIR EXISTING LUMINAIRE. PROVIDE NEW AS REQUIRED.
 - EXISTING LIGHT POLE, CIRCUIT AND LUMINAIRES TO REMAIN.
 - PROVIDE NEW LIGHTING CONTROLLER "A1", AS INDICATED ON PLAN. COORDINATE EXACT REQUIREMENTS WITH CITY OF NAPERVILLE.
 - PROVIDE NEW SERVICE FOR NEW CONTROLLER.

REVISIONS	
NAME	DATE
ADDENDUM 1 - NEW SHEET	8/28/08

INTERSECTION IMPROVEMENT
 WASHINGTON STREET - 75th STREET
 PROPOSED ELECTRICAL PLAN
 WASHINGTON STREET
 SHEET 4 OF 7
 STA. 561+50 TO EOP

CONSULTANT
TYLIN INTERNATIONAL

City of  **Naperville**

DRAWN: JRH
 CHECKED: FO
 APPROVED: DEM
 DATE: 04/11/08
 SCALE: 1"=50'-0"
 JOB NO.: P-91-494-00

SHEET NO.
 PROJECT NO.: CMM-7003 (983)

