


F.A.U. RTE.	SECTION	COUNTY	TOTAL SHEETS	SHEET NO.
2552	00-00114-00-PV	DuPAGE	563	233
STA.		TO STA.		
FED. ROAD DIST. NO.	ILLINOIS	FED. AID PROJECT		

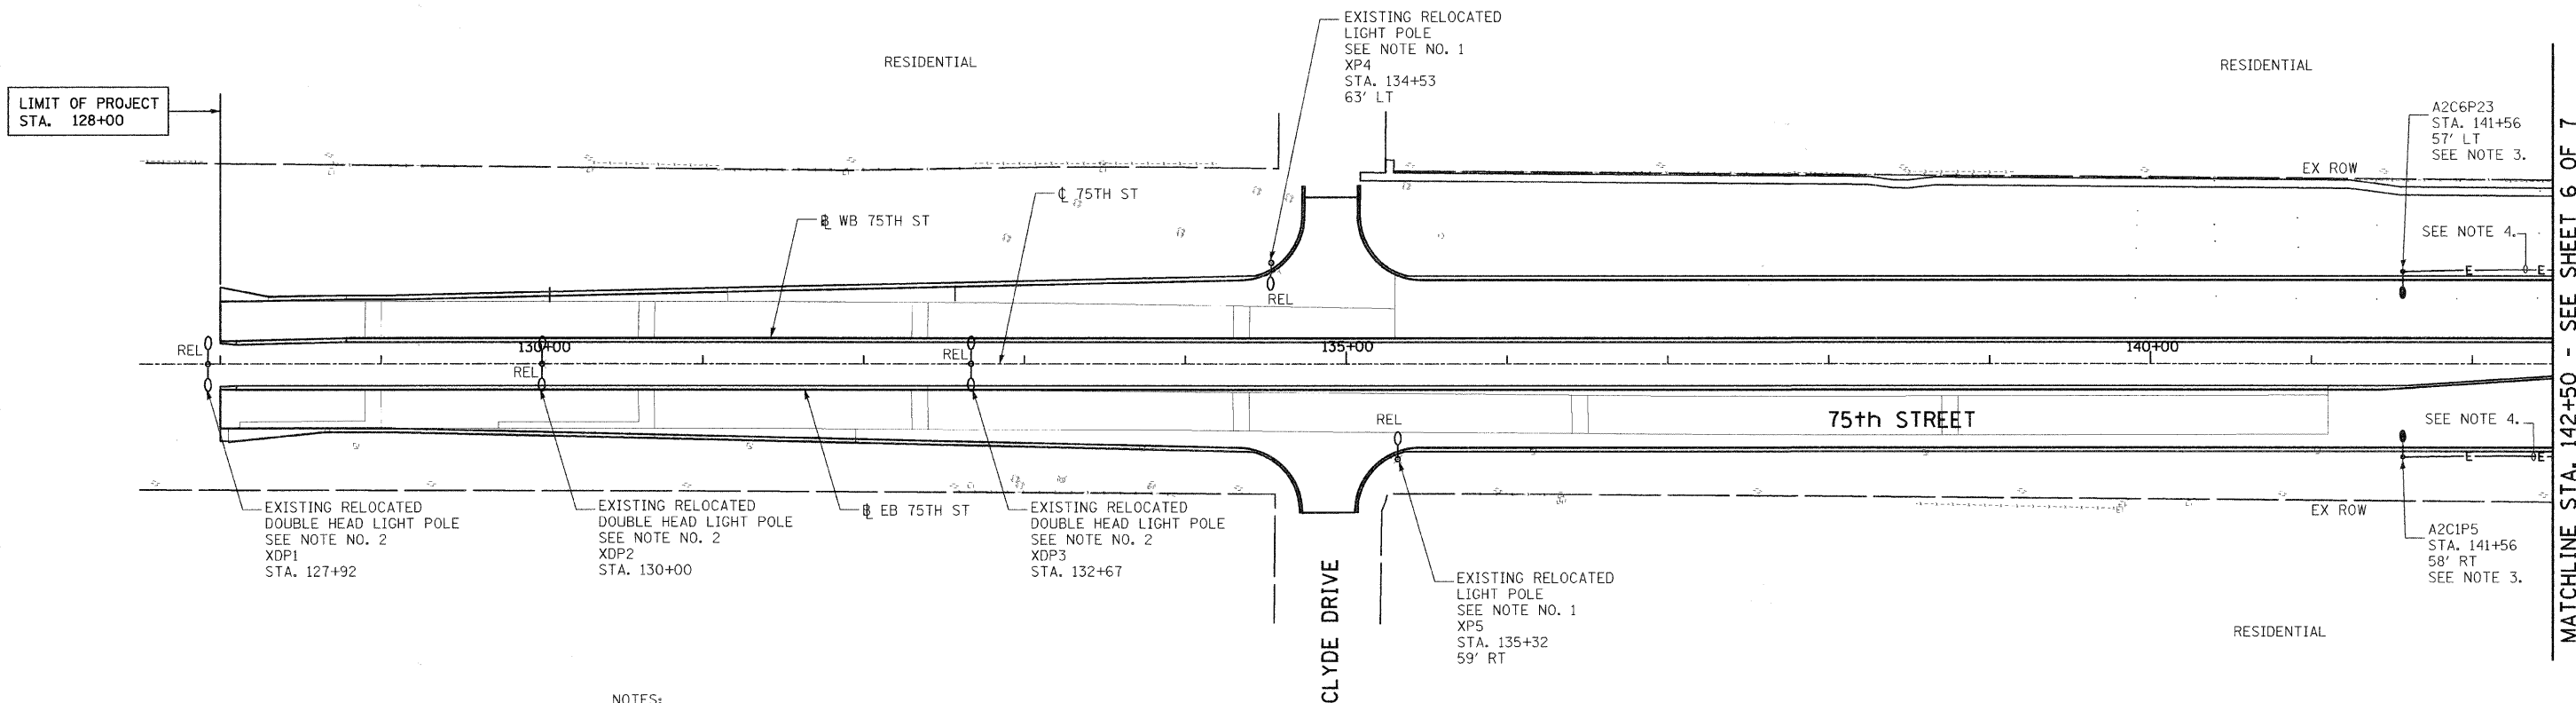


- NOTES:**
1. RELOCATED EXISTING LIGHT POLE AND LUMINAIRE IN NEW LOCATION. EXTEND AND REROUTE EXISTING CONDUIT AND WIRES TO NEW LOCATION. PROVIDE NEW CONDUIT AND WIRES AS REQUIRED. RECONNECT TO EXISTING CIRCUIT IN NEW LOCATION. CLEAN AND REPAIR EXISTING LUMINAIRE.
  2. RELOCATED EXISTING LIGHT POLE AND DOUBLE HEAD LUMINAIRES IN NEW LOCATION. EXTEND AND REROUTE EXISTING CONDUIT AND WIRES TO NEW LOCATION. PROVIDE NEW CONDUIT AND WIRES AS REQUIRED. RECONNECT TO EXISTING CIRCUIT IN NEW LOCATION. CLEAN AND REPAIR EXISTING LUMINAIRES.
  3. PROVIDE NEW LIGHT POLE AND ASSOCIATED LUMINAIRE PER NEW WORK REQUIREMENT. REFER TO GENERAL NOTES AND SYMBOLS SHEET FOR POLE AND LUMINAIRE INFORMATIONS.
  4. PROVIDE NEW CIRCUIT WIRES (3-1/C NO. 6 AWG, 1/C AWG NO. 6 GROUND WITHIN 2" DIAMETER UNIT DUCT). NEW CIRCUIT SHALL BE CONNECTED TO NEW CONTROLLER "A2". REFER TO PROPOSED ELECTRICAL PLAN SHEET 6 OF 7 FOR CONTROLLER LOCATION.

REVISIONS	
NAME	DATE
ADDENDUM 1 - NEW SHEET	8/28/08

INTERSECTION IMPROVEMENT  
 WASHINGTON STREET - 75th STREET  
**PROPOSED ELECTRICAL PLAN**  
 75th STREET  
 SHEET 5 OF 7  
 STA. 127+50 TO STA. 142+50

CONSULTANT  
**TYLIN INTERNATIONAL**

City of  **Naperville**

DRAWN: JRH  
 CHECKED: FO  
 APPROVED: DEM  
 DATE: 04/11/08  
 SCALE: 1"=50'-0"  
 JOB NO.: P-91-494-00

SHEET NO.  
 PROJECT NO.: CMM-7003 (983)



MATCHLINE STA. 142+50 - SEE SHEET 6 OF 7