
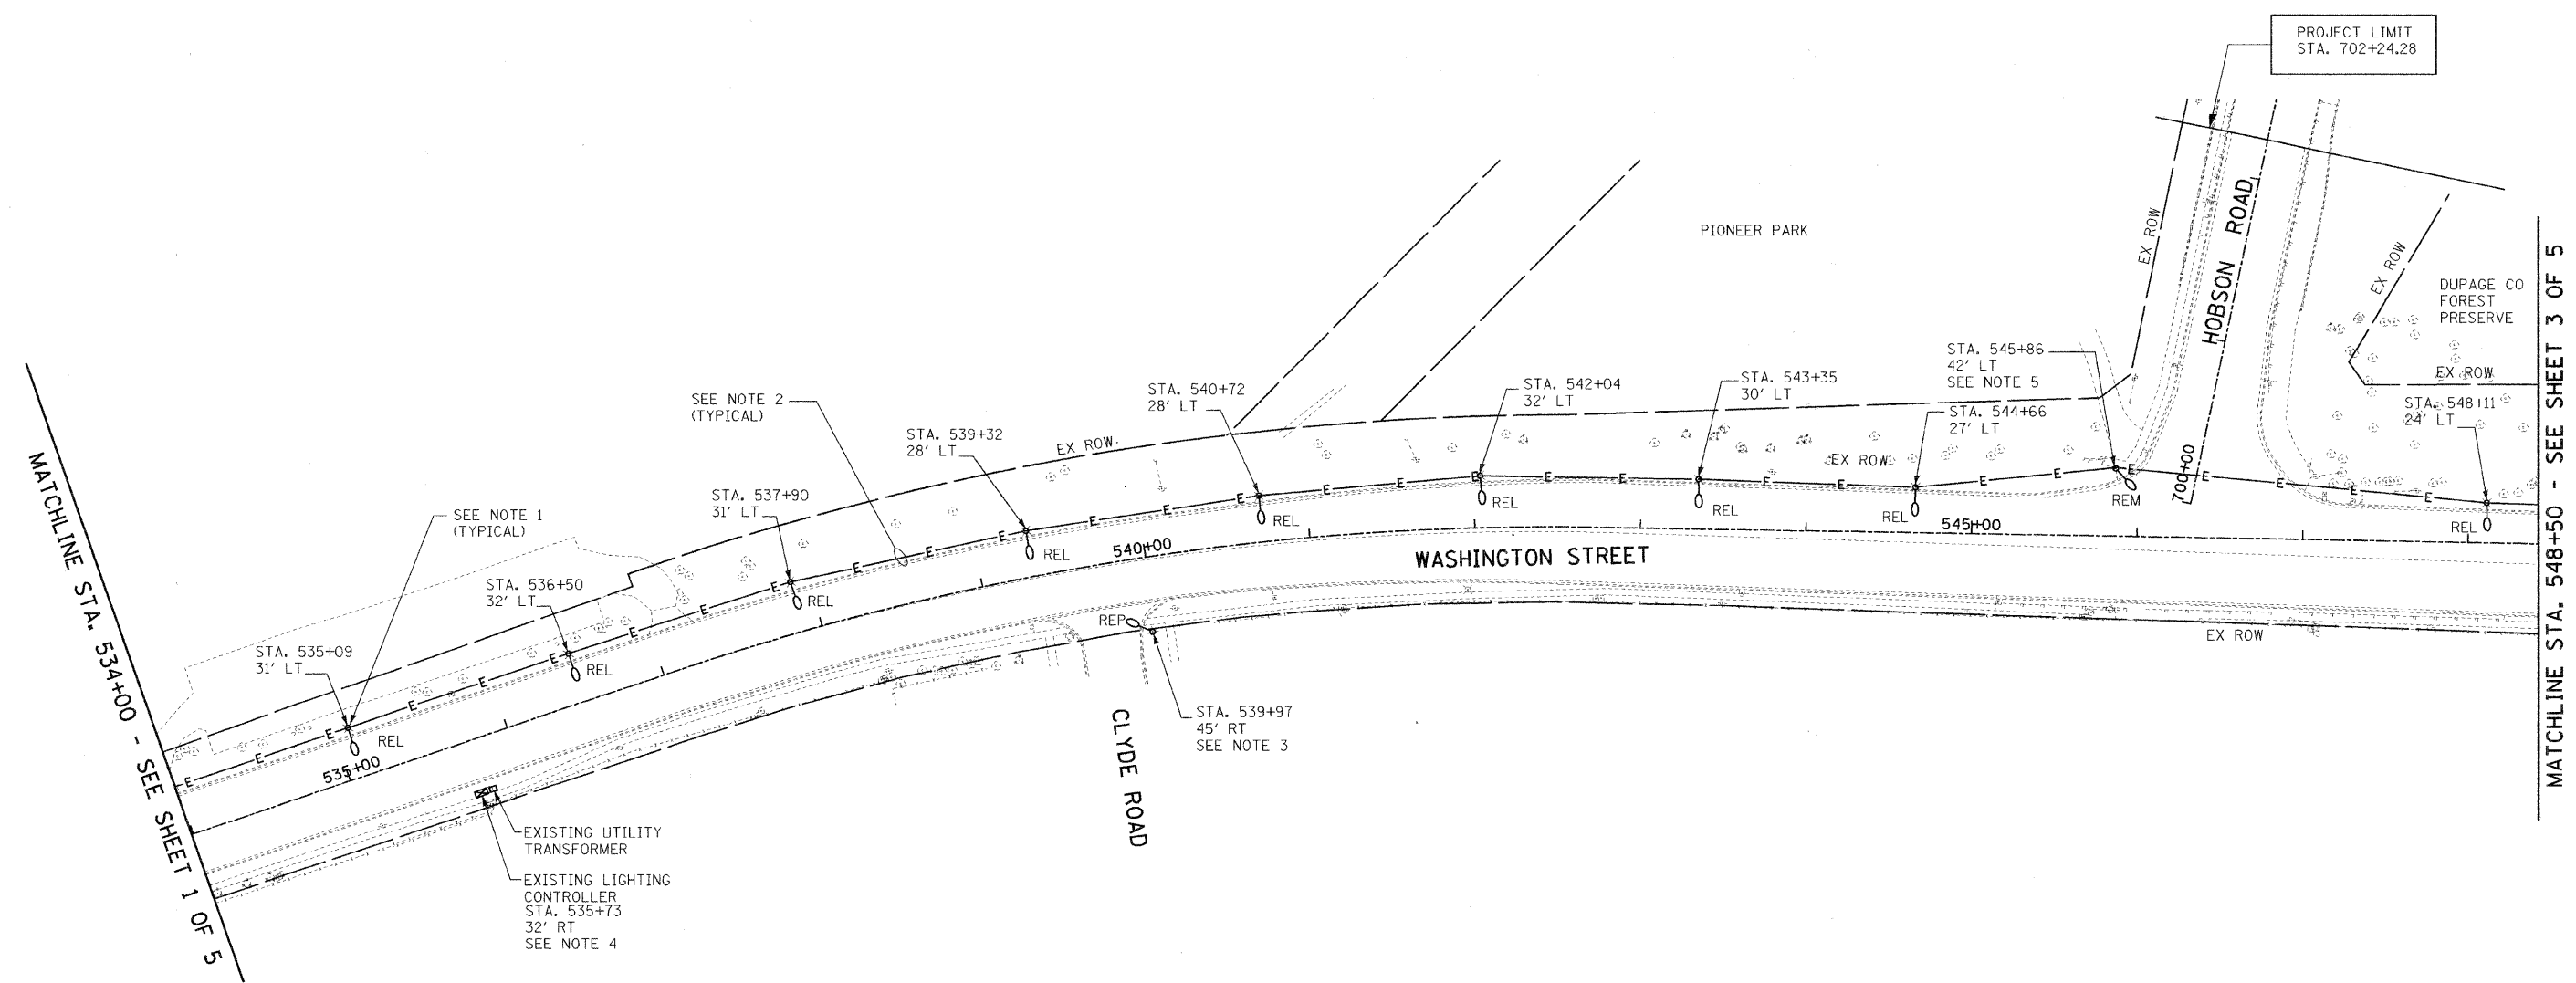


F.A.U. RTE.	SECTION	COUNTY	TOTAL SHEETS	SHEET NO.
2552	00-00114-00-PV	DUPAGE	563	238
STA.		TO STA.		
FED. ROAD DIST. NO.	ILLINOIS	FED. AID PROJECT		

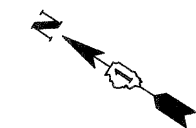


- NOTES:
1. DISCONNECT AND RELOCATE EXISTING LIGHT POLE AND ASSOCIATED LUMINAIRE PER DEMOLITION WORK REQUIREMENT. EXISTING LIGHT POLE AND LUMINAIRE SHALL BE REUSED FOR NEW WORK IN NEW LOCATION. CLEAN AND REPAIR EXISTING LUMINAIRE AND POLE. PROVIDE NEW PARTS OR LUMINAIRE AS REQUIRED.
 2. DISCONNECT AND REMOVE EXISTING WIRES AS INDICATED ON THE PLAN.
 3. DISCONNECT AND REMOVE EXISTING CONCRETE LIGHT POLE AND ASSOCIATED 250W HPS LUMINAIRE AND TURN OVER TO OWNER. SEE PROPOSED ELECTRICAL PLAN, SHEET 2 OF 7 FOR NEW WORK.
 4. EXISTING LIGHTING CONTROLLER TO REMAIN.
 5. COMED RATE SHEET LIGHT TO BE REMOVED BY OTHERS.

MATCHLINE STA. 534+00 - SEE SHEET 1 OF 5

MATCHLINE STA. 548+50 - SEE SHEET 3 OF 5

REVISIONS	
NAME	DATE
ADDENDUM 1 - NEW SHEET	8/28/08

INTERSECTION IMPROVEMENT
 WASHINGTON STREET - 75th STREET
 ELECTRICAL DEMOLITION PLAN
 WASHINGTON STREET
 SHEET 2 OF 5
 STA. 534+00 TO STA. 548+50
 CONSULTANT
TYLIN INTERNATIONAL

City of  **Naperville**

DRAWN: JRH	SHEET NO.
CHECKED: FO	
APPROVED: DEM	
DATE: 04/11/08	
SCALE: 1"=50'-0"	
JOB NO.: P-91-494-00	PROJECT NO.: CMM-7003 (983)



PLANNING & ENGINEERING, INC.