


F.A.U. RTE.	SECTION	COUNTY	TOTAL SHEETS	SHEET NO.
2552	00-00114-00-PV	DuPAGE	563	240
STA.		TO STA.		
FED. ROAD DIST. NO.	ILLINOIS	FED. AID PROJECT		

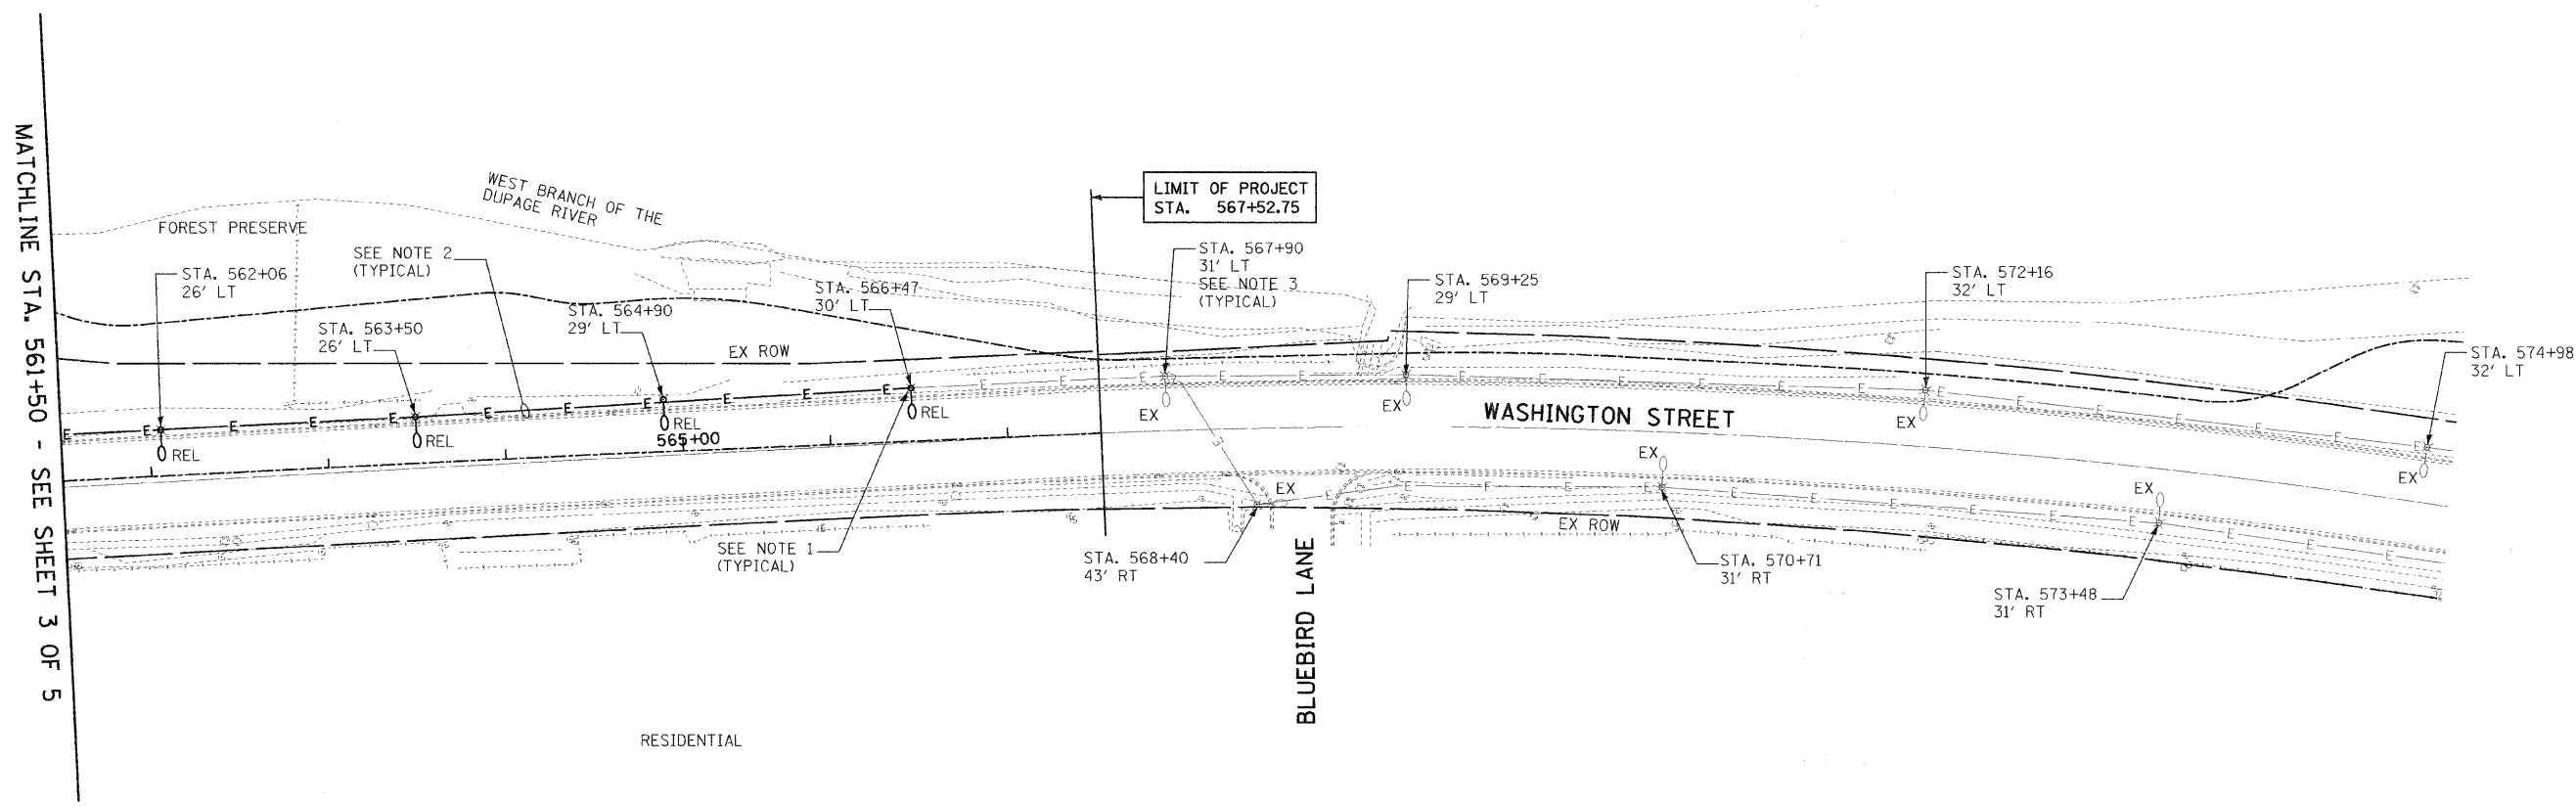

MATCHLINE STA. 561+50 - SEE SHEET 3 OF 5

NOTES:

1. DISCONNECT AND RELOCATE EXISTING LIGHT POLE AND ASSOCIATED LUMINAIRE PER DEMOLITION WORK REQUIREMENT. EXISTING LIGHT POLE AND LUMINAIRE SHALL BE REUSED FOR NEW WORK IN NEW LOCATION. CLEAN AND REPAIR EXISTING LUMINAIRE AND POLE. PROVIDE NEW PARTS OR LUMINAIRE AS REQUIRED.
2. DISCONNECT AND REMOVE EXISTING WIRES AS INDICATED ON THE PLAN.
3. EXISTING LIGHT POLE AND ASSOCIATED LUMINAIRE TO REMAIN. SEE PROPOSED ELECTRICAL PLAN, SHEET 4 OF 7 FOR NEW WORK.

REVISIONS	
NAME	DATE
ADDENDUM 1 - NEW SHEET	8/28/08

INTERSECTION IMPROVEMENT
WASHINGTON STREET - 75th STREET
ELECTRICAL DEMOLITION PLAN
WASHINGTON STREET
 SHEET 4 OF 5
 STA. 561+50 TO EOP

CONSULTANT
TYLIN INTERNATIONAL

City of **Naperville**

DRAWN: JRH	SHEET NO.
CHECKED: FO	
APPROVED: DEM	
DATE: 04/11/08	
SCALE: 1"=50'-0"	
JOB NO.: P-91-494-00	PROJECT NO.: CMM-7003 (983)

