




|                     |                |                  |                    |           |
|---------------------|----------------|------------------|--------------------|-----------|
| F.A.U. RTE.         | SECTION        | COUNTY           | TOTAL SHEETS       | SHEET NO. |
| 2552                | 00-00114-00-PV | DuPAGE           | 563                | 119       |
| STA.                | TO STA.        |                  |                    |           |
| FED. ROAD DIST. NO. | ILLINOIS       | FED. AID PROJECT | CONTRACT NO. 63024 |           |

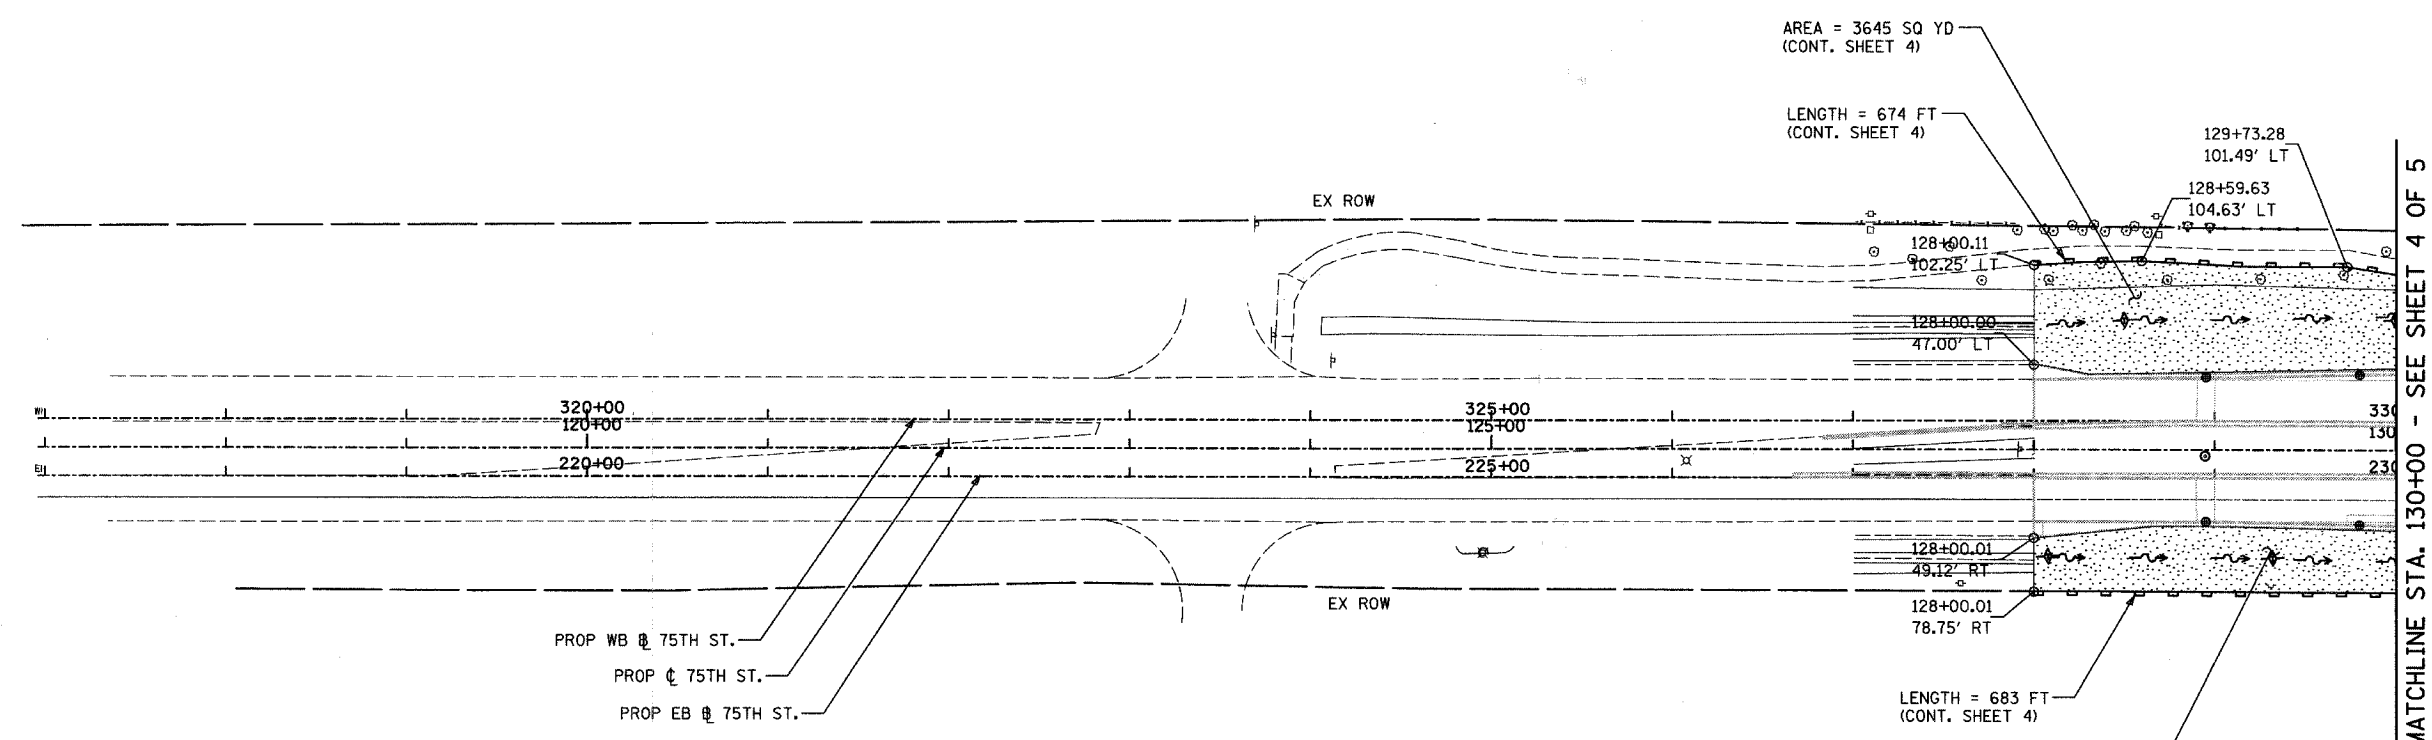

MATCHLINE STA. 130+00 - SEE SHEET 4 OF 5

**LEGEND:**

 - TEMPORARY EROSION CONTROL SEEDING, WITH EROSION CONTROL BLANKET, EXCELSIOR TYPE
- SEDIMENT CONTROL, SILT FENCE
- TEMPORARY DITCH CHECK
- INLET AND PIPE PROTECTION
- INLET FILTER, TO BE INSTALLED IN OFF PROJECT DRAINAGE STRUCTURES ACCEPTING STORMWATER RUNOFF
- EXISTING DRAINAGE SWALE
- PROPOSED DRAINAGE SWALE (SEE DRAINAGE PLANS)
- PROPOSED DRAINAGE DITCH (SEE DRAINAGE PLANS)
- PERIMETER EROSION BARRIER, MODIFIED (DOUBLE ROW)
- TEMPORARY FENCE (15 FEET PER SIDE = 60 FEET TOTAL) OR AS NOTED
- SILT CURTAIN

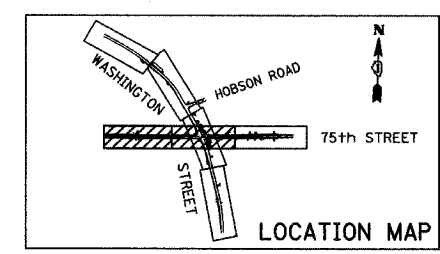

| REVISIONS |      |
|-----------|------|
| NAME      | DATE |
|           |      |
|           |      |
**INTERSECTION IMPROVEMENT  
WASHINGTON STREET - 75th STREET  
EROSION CONTROL  
75th STREET  
SHEET 3 OF 5  
STA. 117+00 TO STA. 130+00**

CONSULTANT  
**TYLIN INTERNATIONAL**

City of **Naperville**

|                      |                               |
|----------------------|-------------------------------|
| DRAWN:               | SHEET NO.                     |
| CHECKED:             |                               |
| APPROVED:            |                               |
| DATE: APRIL 11, 2008 |                               |
| SCALE:               |                               |
| JOB NO.: P-91-494-00 | PROJECT NO.: M-CMM-7003 (985) |

DRAWN BY: J. J. ... 4/11/2008 10:34:43 AM