



F.A.R.L. RTE.	SECTION	COUNTY	TOTAL SHEETS	SHEET NO.
2552	00-00114-00-PV	DuPAGE	563	225
STA.		TO STA.		
FED. ROAD DIST. NO.	ILLINOIS	FED. AID PROJECT		

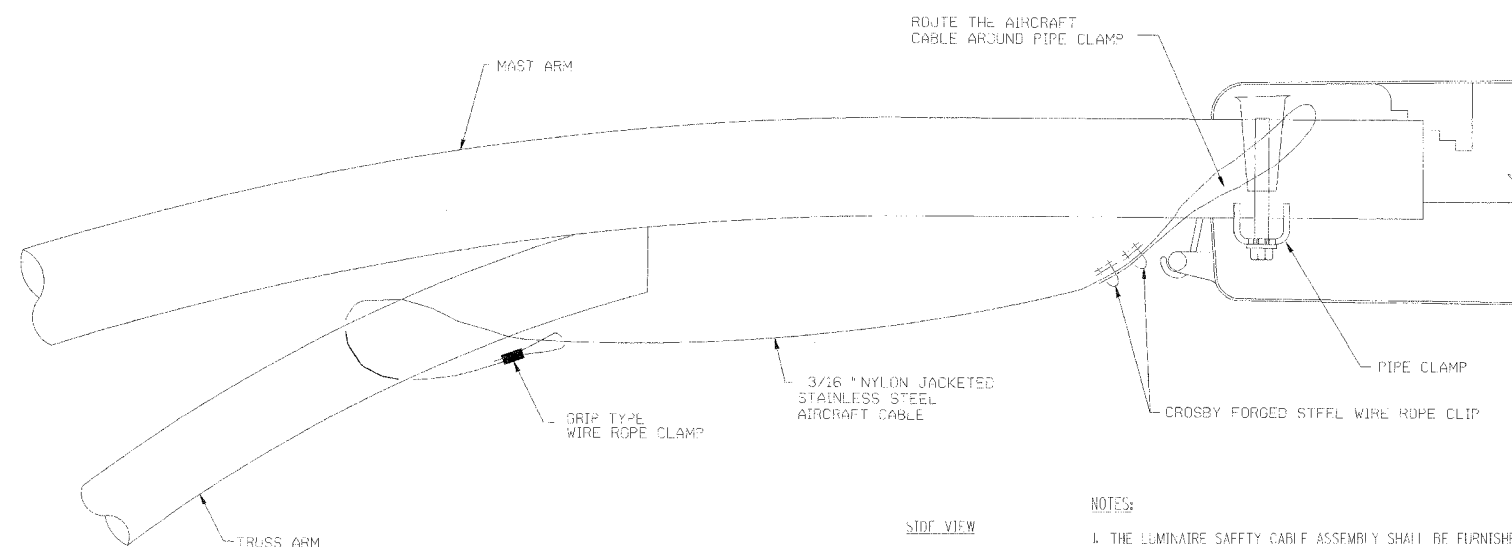

**NOTES:**


1. THE LUMINAIRE SAFETY CABLE ASSEMBLY SHALL BE FURNISHED AND INSTALLED BY THE CONTRACTOR, AND SHALL BE INCIDENTAL TO THE CONTRACT.
2. CONTRACTOR SHALL ADJUST THE WIRE CLIP TO ELIMINATE ANY SLACK FROM THE WIRE ROPE.
3. THE 3/16" NYLON JACKETED STAINLESS STEEL AIRCRAFT CABLE SHALL REMAIN VISIBLE FROM THE GROUND LEVEL.
4. THE BREAKING STRENGTH OF THE CABLE SHALL BE 2000 LBS. M.N.

**1** SPLITTER LUMINAIRE KEEPER PHYSICAL INSTALLATION DETAIL  
NOT TO SCALE

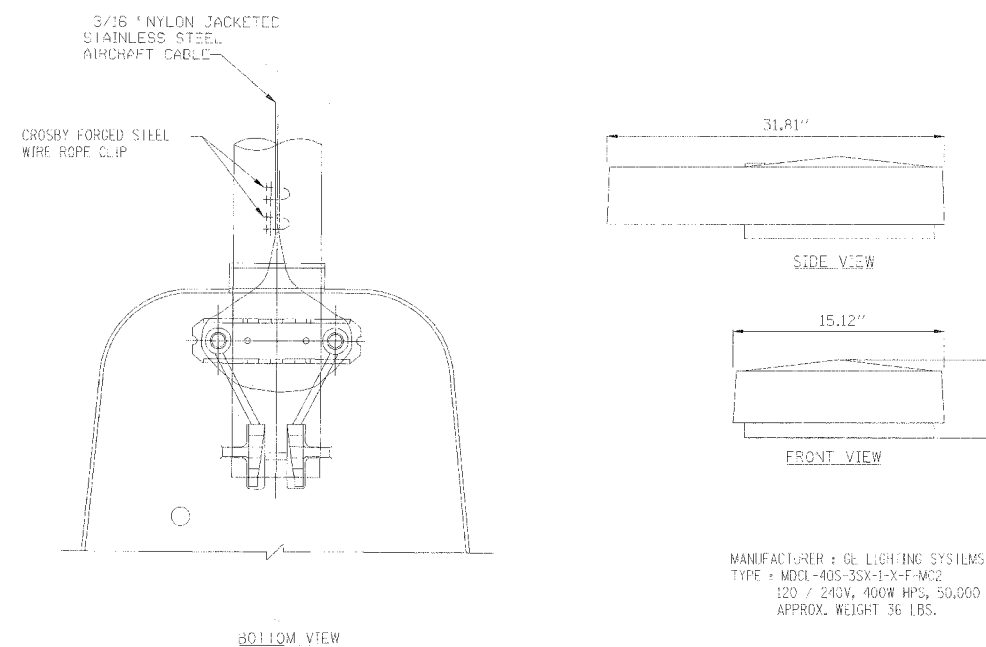

MANUFACTURER: GE LIGHTING SYSTEMS  
TYPE: MDCL-405-3SX-1-X-F-1AC2  
120 / 240V, 400W HP'S, 50,000 LIGHT LUMENS,  
APPROX. WEIGHT 36 LBS.

**2** LUMINAIRE DETAIL  
NOT TO SCALE

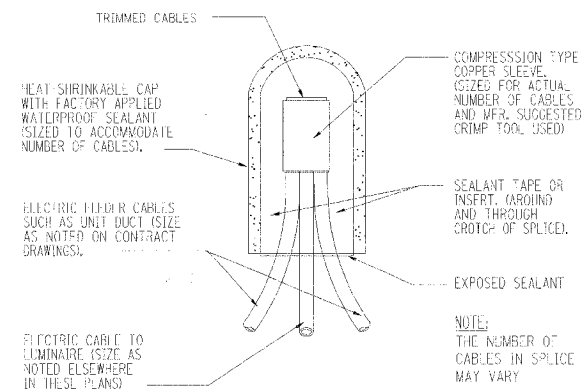

**SPlicing ELECTRIC CABLES**


**3** BASIC MATERIALS AND METHODS  
NOT TO SCALE



REVISIONS	
NAME	DATE

INTERSECTION IMPROVEMENT  
WASHINGTON STREET - 75th STREET  
ELECTRICAL DETAILS  
SHEET 4 OF 4

CONSULTANT  
**TYLIN INTERNATIONAL**

City of  **Naperville**

DRAWN: FO	SHEET NO.
CHECKED: FI	
APPROVED: DEM	
DATE: 04/11/08	
SCALE:	
JOB NO.: P-91-494-00	PROJECT NO.: CMM-7003 (983)

C:\WORK\2008\04\08\983\983.DWG 4/11/08 1:23:38 PM