


F.A.D. RTE.	SECTION	COUNTY	TOTAL SHEETS	SHEET NO.
2552	00-00114-00-PV	DUPAGE	563	232
STA.		TO STA.		
FED. ROAD DIST. NO.		ILLINOIS	FED. AID PROJECT	



MATCHLINE STA. 561+29 - SEE SHEET 3 OF 7

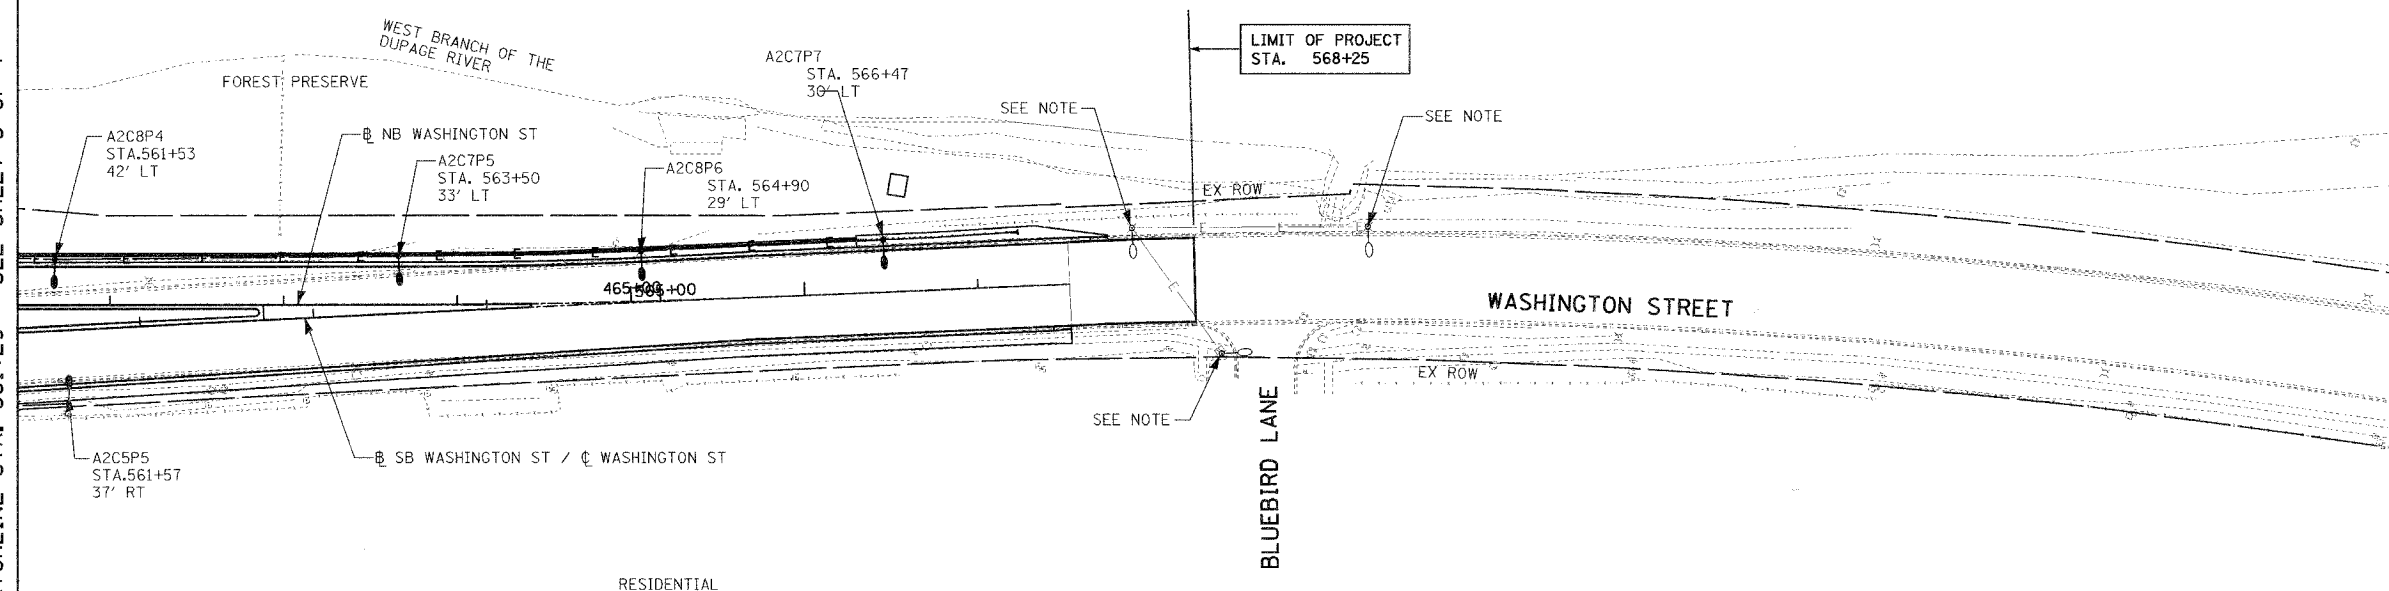


NOTE:  
EXISTING LIGHT POLE AND FIXTURE TO REMAIN.



REVISIONS	
NAME	DATE

INTERSECTION IMPROVEMENT  
WASHINGTON STREET - 75th STREET  
PROPOSED ELECTRICAL PLAN  
WASHINGTON STREET  
SHEET 4 OF 7  
STA. 561+50 TO EOP

CONSULTANT  
**TYLIN INTERNATIONAL**

City of  **Naperville**

DRAWN: FO	SHEET NO.
CHECKED: FI	
APPROVED: DEM	
DATE: 04/11/08	
SCALE: 1"=50'-0"	
JOB NO.: P-91-494-00	PROJECT NO.: CMM-7003 (983)

DRAWN: FO, CHECKED: FI, APPROVED: DEM, DATE: 04/11/08, SCALE: 1"=50'-0", JOB NO.: P-91-494-00, PROJECT NO.: CMM-7003 (983)