
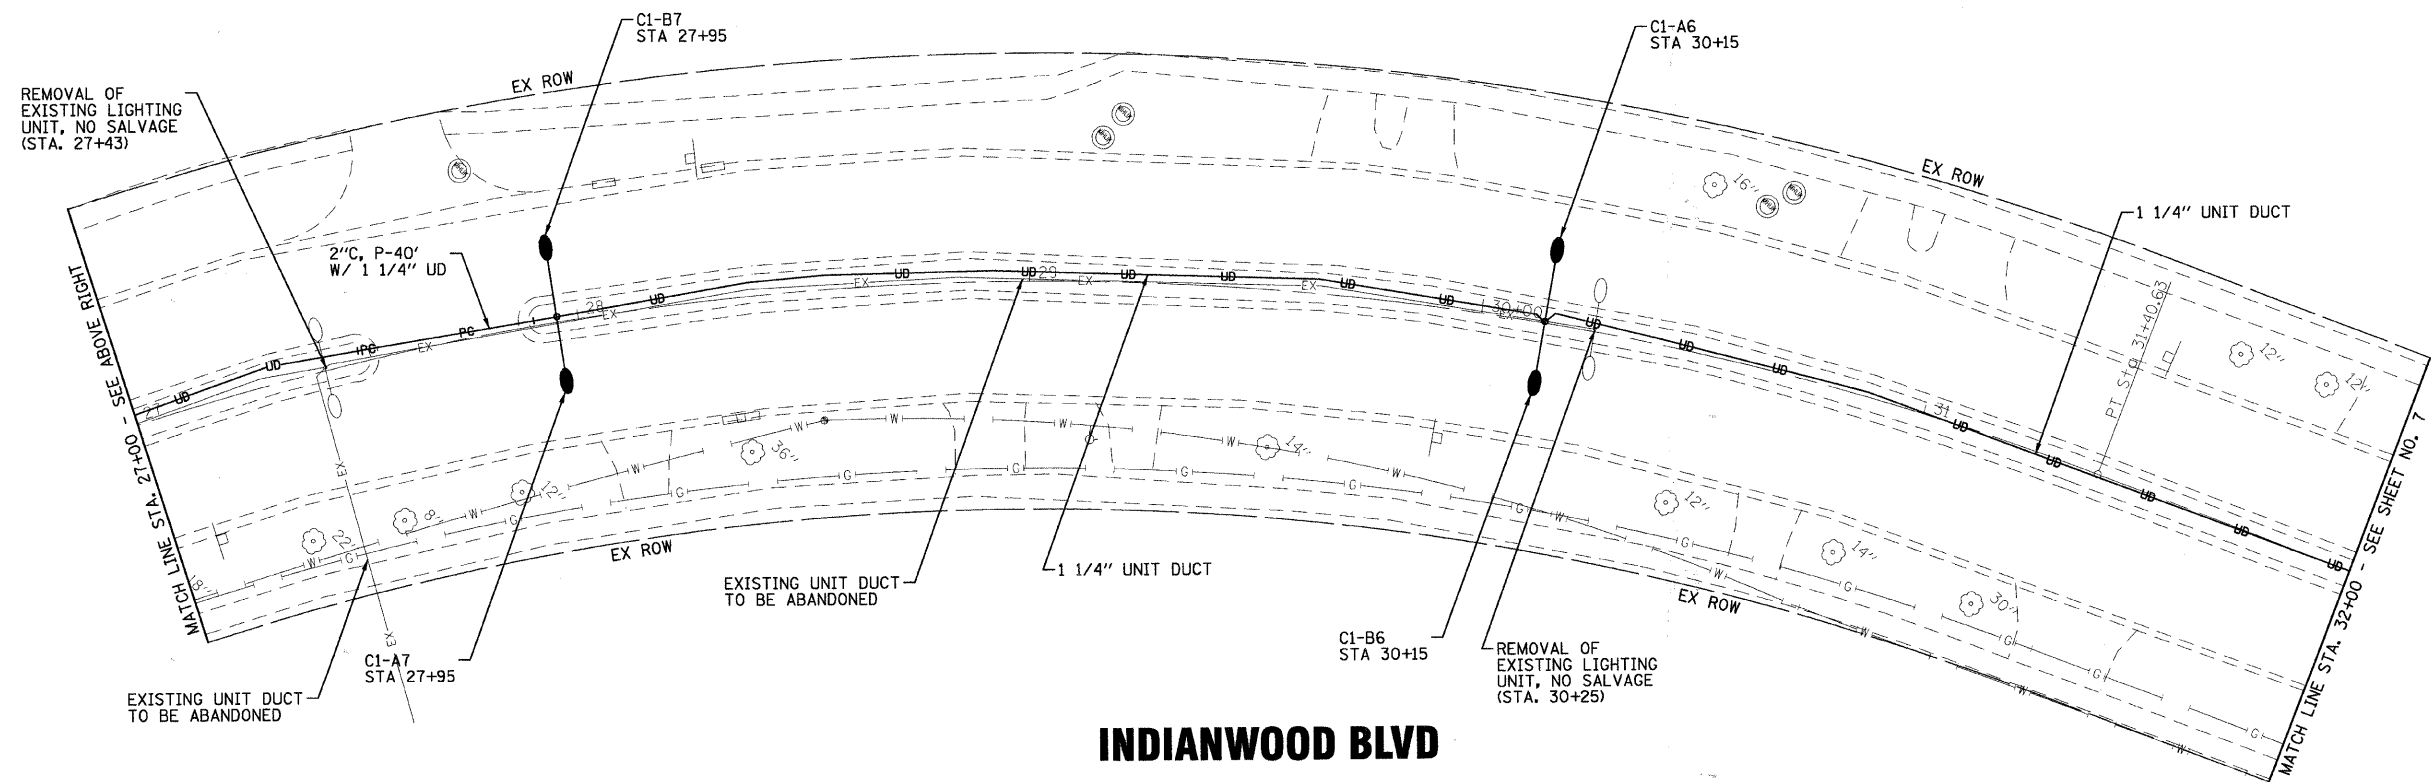


F.A. RTE.	SECTION	COUNTY	TOTAL SHEETS	SHEET NO.
•	••	COOK	10	6
STA.	TO STA.			
FED. ROAD DIST. NO.	ILLINOIS	FED AID PROJECT TCSP-061L (010)		
• NA	CONTRACT NO. 83991			
•• 07-00091-00-LT				

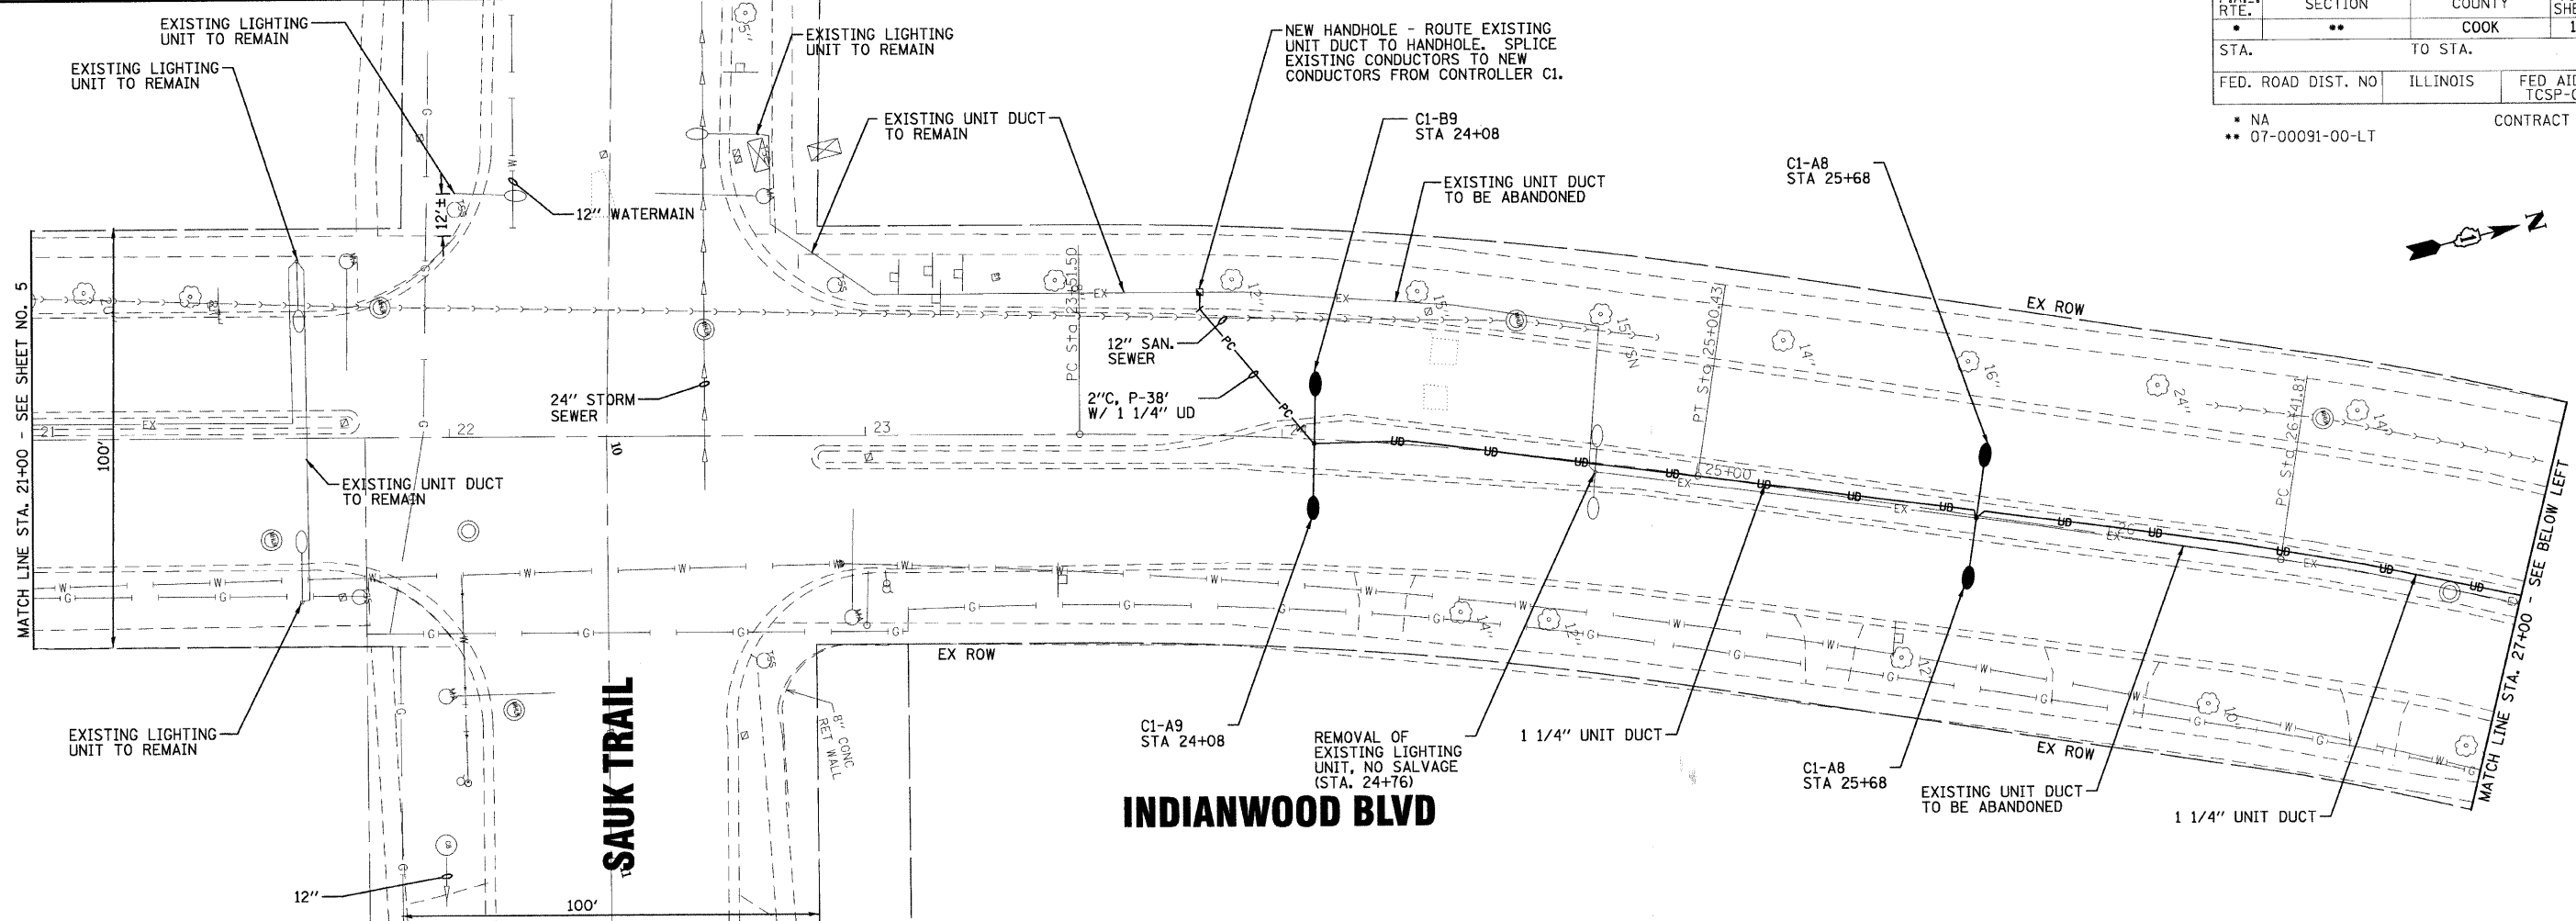

6/29/2008 10:35 AM I:\proj\11\06389.SL2.dgn from mokemo\06389.SL2.dgn
 © 2008 BAXTER & WOODMAN, INC.
 STATE OF ILLINOIS - PROFESSIONAL DESIGN FIRM
 LICENSE NO. - 184-00121 - EXPIRES 4/30/2007

CONSULTANTS	REV. NO.	DATE	DESCRIPTION

* REFER TO EQUIPMENT MANUFACTURER'S SHOP DRAWINGS

DRAWING FILE: ...061389_SL2.dgn

BAXTER & WOODMAN
 Consulting Engineers

Baxter & Woodman
 Crystal Lake, Illinois 815.489.1280
 Burlington, Wisconsin 952.763.7834
 Mokena, Illinois 708.478.2090
 DeKalb, Illinois 815.787.3111
 Graylake, Illinois 847.223.5088
 Rockford, Illinois 815.489.1551
 Plainfield, Illinois 815.609.7425

VILLAGE OF PARK FOREST, ILLINOIS
INDIANWOOD BLVD
BLACKHAWK DR TO ORCHARD DR

STREET LIGHTING PLAN
STA. 21+00 TO STA. 32+00

DESIGNED BY	JLR	SCALE	1" = 20'
DRAWN BY	BCD	PROJECT NO.	061389
CHECKED BY	TMS	SHEET NO.	6 OF 10
DATE	06-13-08		