
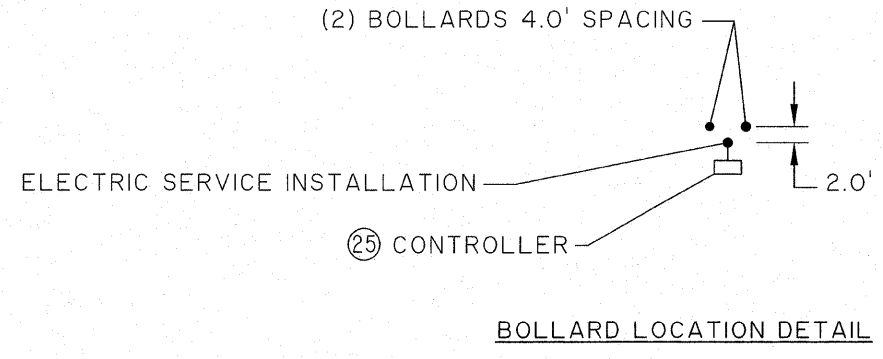
 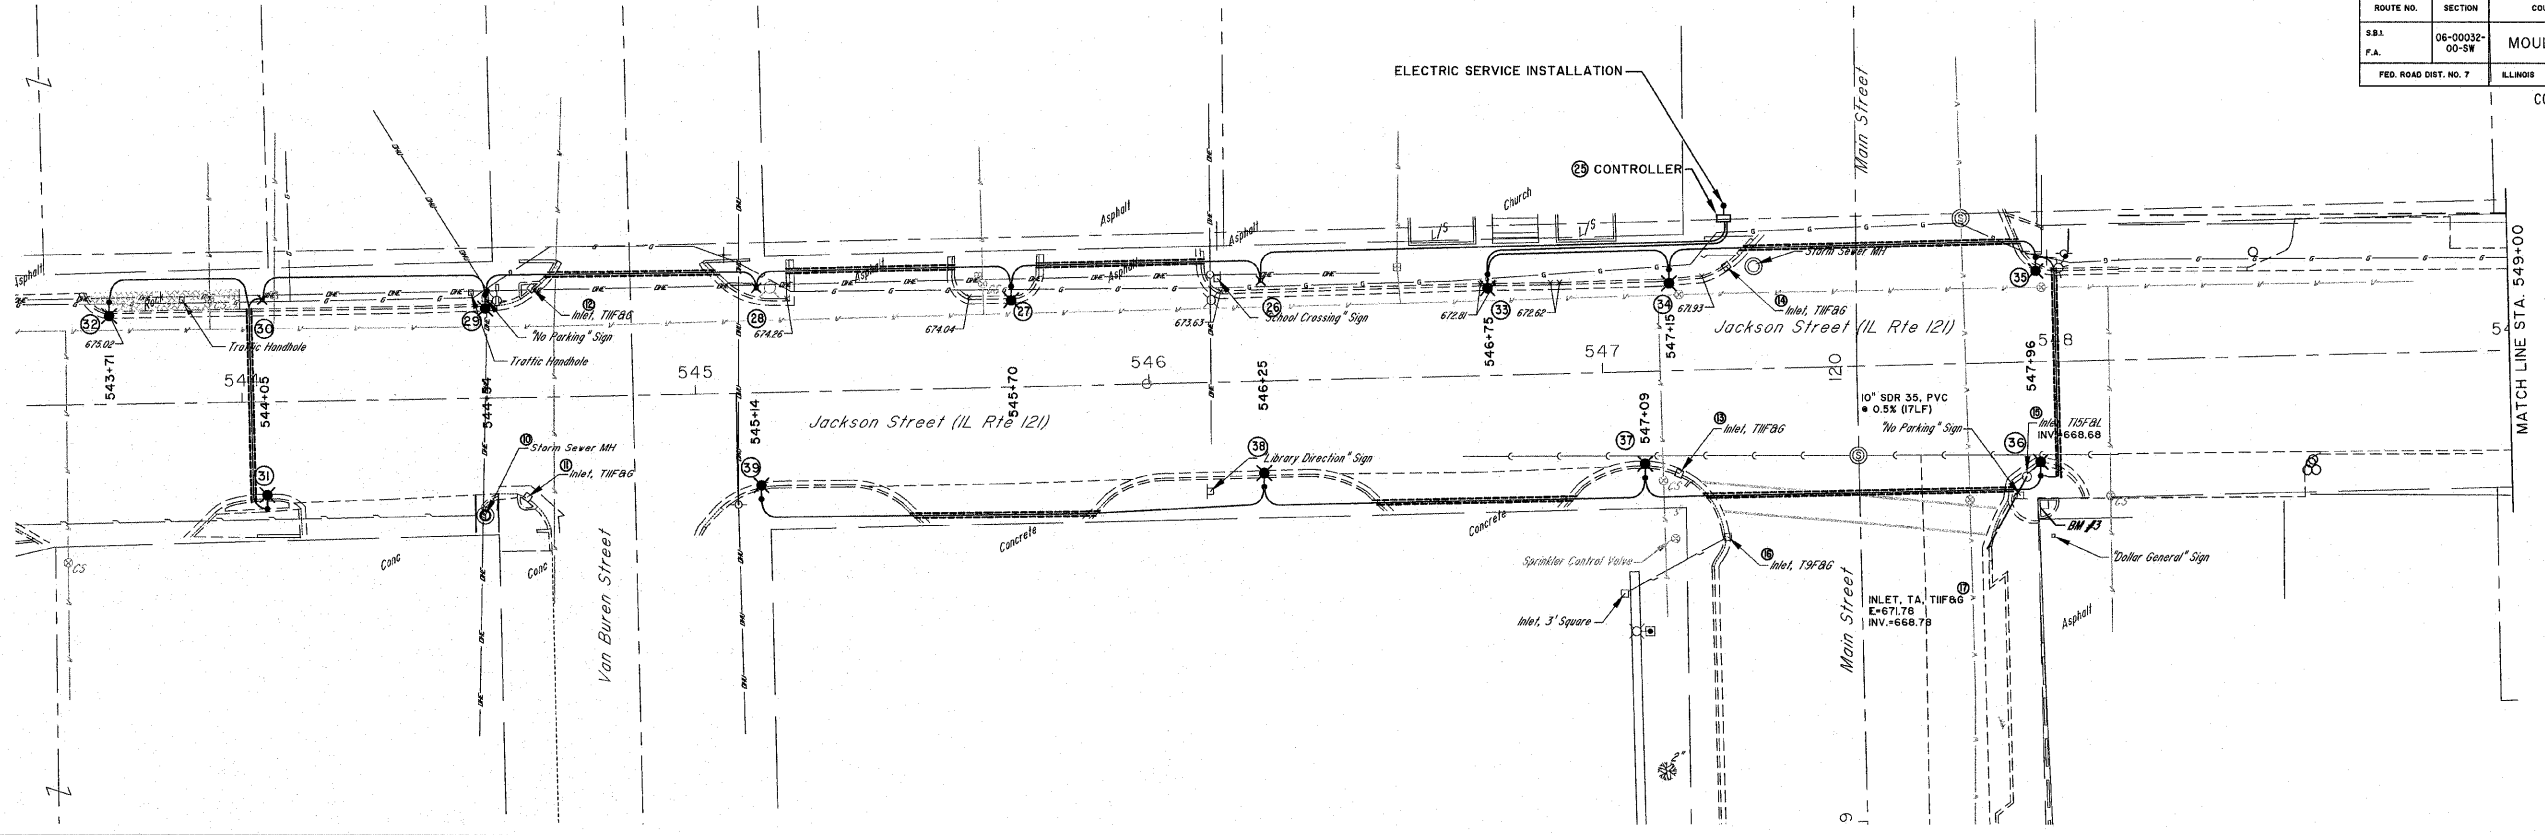


ROUTE NO.	SECTION	COUNTY	TOTAL SHEETS	SHEET NO.
S.B.I.	06-00032-00-SW	MOULTRIE	24	17
F.A.				
FED. ROAD DIST. NO. 7	ILLINOIS	FED. AID PROJECT-		

CONTRACT #95561



**MILANO & GRUNLOH ENGINEERS, LLC**  
 84 WEST WASHINGTON  
 P.O. BOX 897  
 EFFINGHAM, ILLINOIS 62401  
 Phone: (217) 347-7262  
 (800) 677-2774  
 Fax #: (217) 342-3453  
 Web Address: www.mgeengineers.com  
 Design Firm #: 184-00308

**ELECTRICAL PLAN**  
 JACKSON STREET (ILL RTE 121)  
 SIDEWALK ENHANCEMENT  
 CITY OF SULLIVAN  
 MOULTRIE CO., ILLINOIS

File name: S:\DWG\06\06244\dwg\Plans.dwg  
 Plot date: 9/6/07 at 13:45 F.S. 620