


ELEVATION

SN: 050-0177
LOOKING WEST

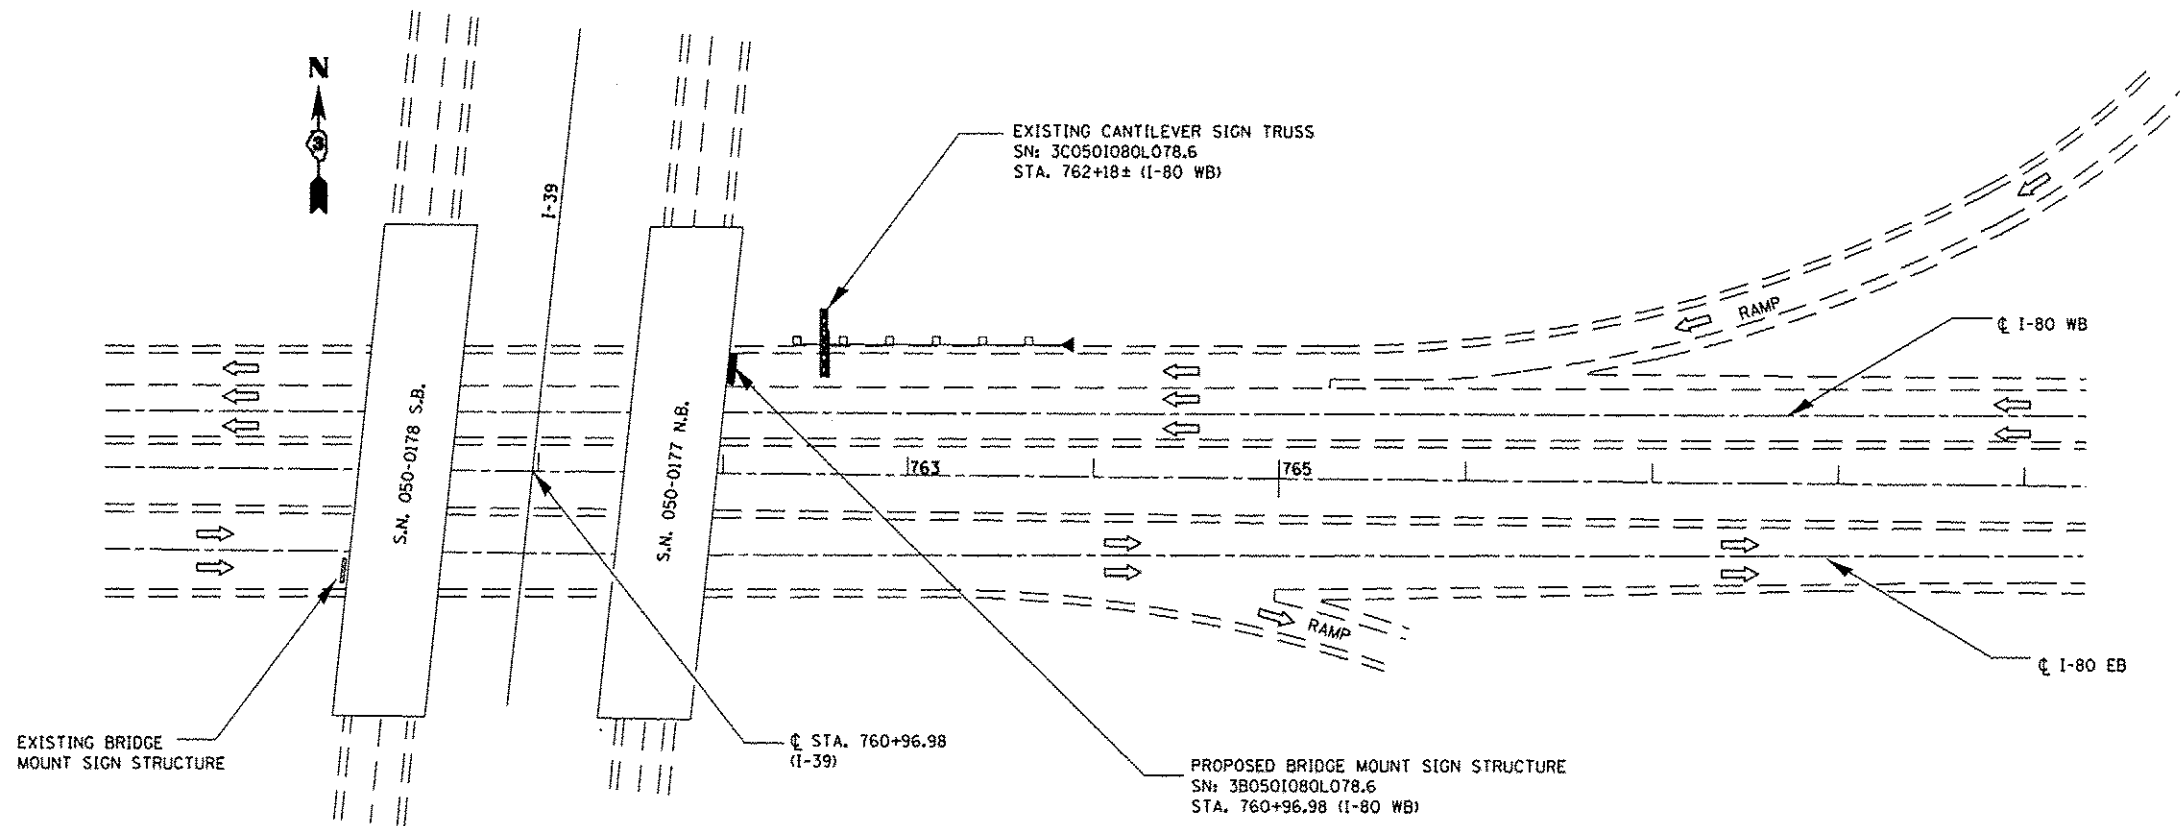

PLAN

SEQUENCE OF OPERATIONS

1. INSTALL PROPOSED BRIDGE MOUNT SIGN STRUCTURE.
2. RELOCATE EXISTING SIGN PANEL(S) TO BRIDGE MOUNT SIGN STRUCTURE.
3. REMOVE EXISTING CANTILEVER SIGN STRUCTURE INCLUDING FOUNDATION.
4. REMOVE AND SALVAGE ALL EXISTING GUARDRAIL AND COMPONENTS, INCLUDING RAILS, POSTS, BLOCKOUTS, AND TERMINAL SECTIONS.

FILE NAME *	USER NAME * patelvj	DESIGNED - YOGESH PATEL	REVISED -	STATE OF ILLINOIS DEPARTMENT OF TRANSPORTATION	GENERAL PLAN & ELEVATION LOCATION 1			F.A.I. RTE.	SECTION	COUNTY	TOTAL SHEETS	SHEET NO.
c:\pwork\p\patelvj\08336977\034676-shr-detailed.dgn	PLT SCALE * 100.0000' / 1"	DRAWN - YOGESH PATEL	REVISED -					80 & 39	03 OVD SIN STR REPL 14-15	LASALLE	14	8
PLT DATE * 7/3/2013	DATE -	CHECKED - RON WOODSHANK	REVISED -		SCALE:	SHEET 1 OF 8 SHEETS	STA.	TO STA.	CONTRACT NO. 46276			
		DATE -	REVISED -		ILLINOIS FED. AID PROJECT							