


ELEVATION

SN: 050-0194
LOOKING NORTH

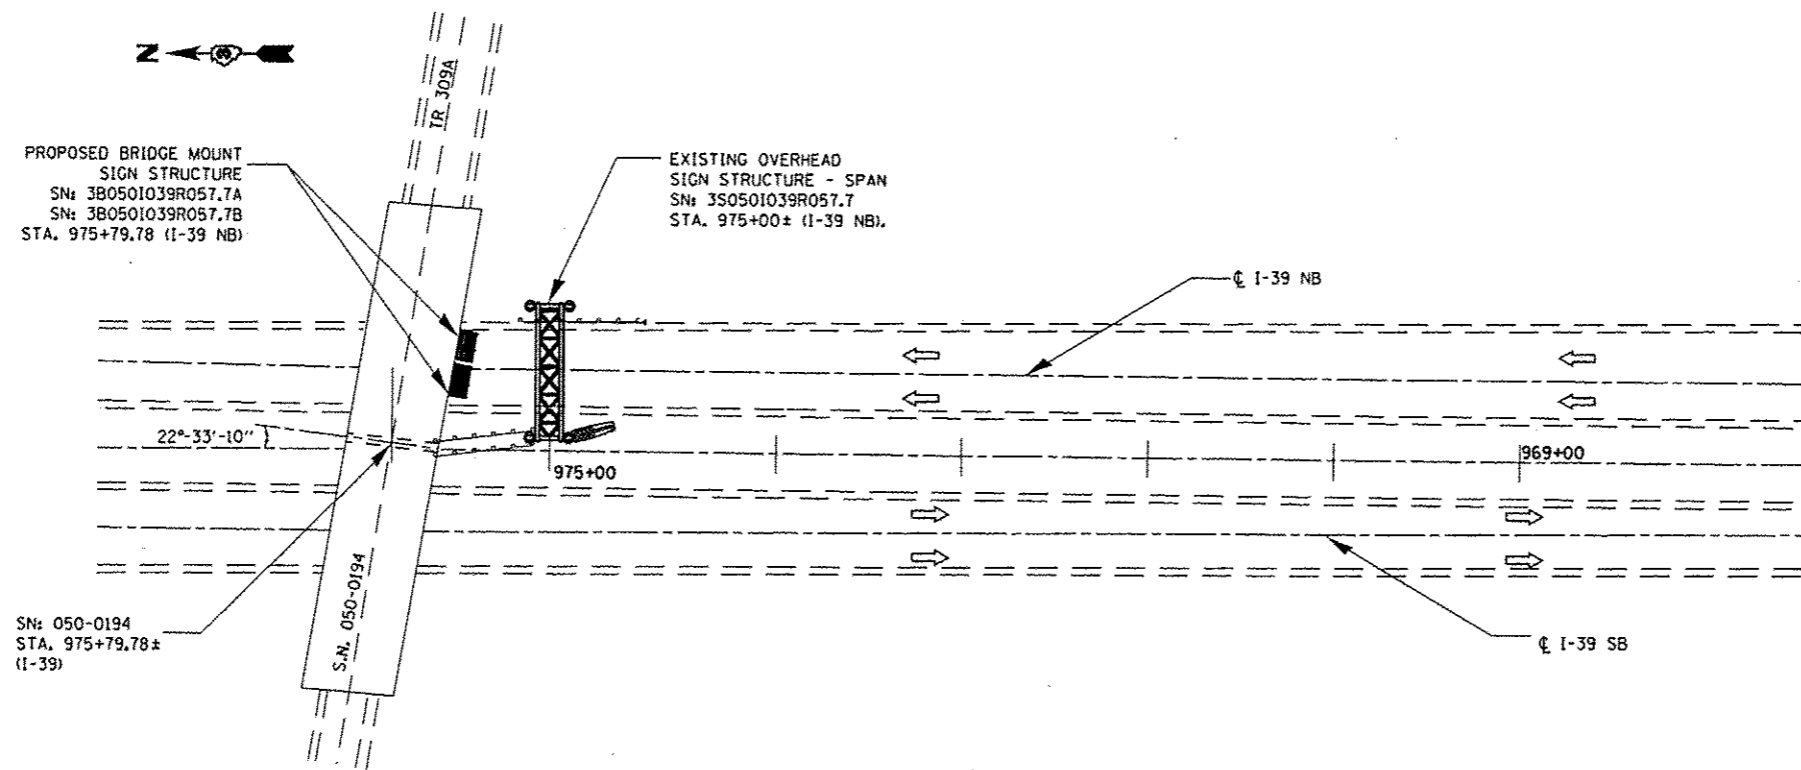

PLAN

SEQUENCE OF OPERATIONS

1. INSTALL PROPOSED BRIDGE MOUNT SIGN STRUCTURE.
2. REMOVE EXISTING SPAN SIGN STRUCTURE INCLUDING FOUNDATIONS AND SIGN PANELS.
3. REMOVE AND SLAVAGE ALL EXISTING GUARDRAIL AND COMPONENTS, INSTALL NEW ATTENUATOR BASE AT CENTER PIER, RELOCATE EXISTING ATTENUATOR SAND BARRELS TO NEW ATTENUATOR BASE, AND REMOVE EXISTING ATTENUATOR BASE.

FILE NAME * c:\pw_work\p\idot\patel\j\0336977\034676-ah\detail.dgn	USER NAME * patel.j	DESIGNED - YOGESH PATEL	REVISED -	STATE OF ILLINOIS DEPARTMENT OF TRANSPORTATION	GENERAL PLAN & ELEVATION LOCATION 2			P.A.I. RTE.	SECTION	COUNTY	TOTAL SHEETS	SHEET NO.
	PLOT SCALE * 1/8"=1'-0"	DRAWN - YOGESH PATEL	REVISED -		SCALE:	SHEET 2 OF 8 SHEETS	STA.	TO STA.	00 & 39/03 OVD SIN STR REPL 14-15	LASALLE	14	9
	PLOT DATE * 7/3/2013	CHECKED - RON WOODSHANK	REVISED -									
		DATE -	REVISED -									
CONTRACT NO. 46276												
[ILLINOIS] FED. AID PROJECT												