
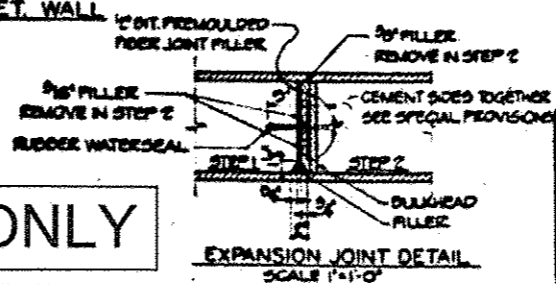
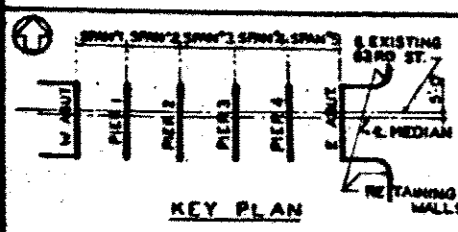


NOTES:
 FOR RAILING DETAILS SEE DRWG NOS 5-11 & 5-12, 5-12 & 13
 FOR DRAINAGE DETAILS SEE DRWG NO 5-2, 5-4, 5-12 & 13
 FOR DETAILS OF CHAIN LINK FENCE SEE SHEET NO. 40
 FOR ELECTRICAL DETAILS SEE SHEET NOS 47 & 48

BILL OF MATERIALS - RETAINING WALLS		
ITEM	UNIT	QUANTITY
CLASS "X" CONCRETE	CU YD	50.4
REINFORCEMENT BARS	LBS	4500

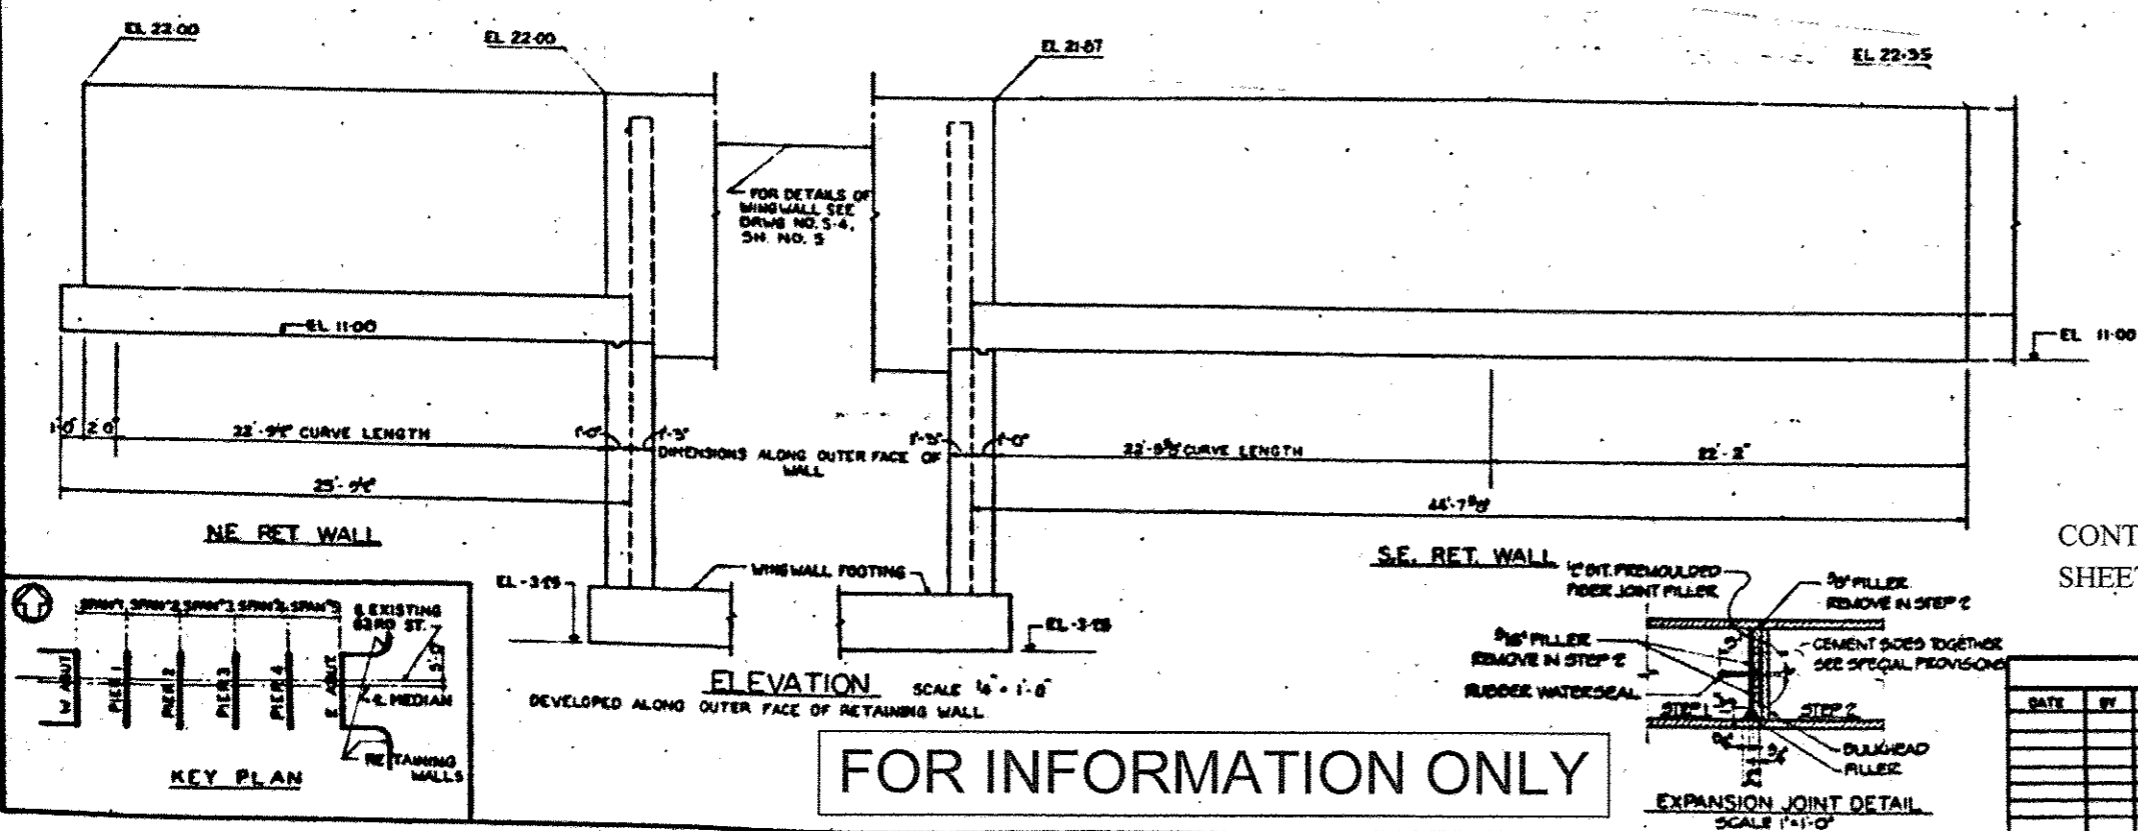

FOR INFORMATION ONLY

CONTRACT NO. 60J15
 SHEET NO. 115 OF 137

REVISIONS		
DATE	BY	DESCRIPTION

DEPARTMENT OF HIGHWAYS
 COOK COUNTY, ILLINOIS

RETAINING WALLS
 63RD STREET GRADE SEPARATION
 OVER
 SOUTH ROUTE EXPRESSWAY

COMPUTED: H.M.K. PROJECT: 111-24-3125150
 DRAWN: R.M.S. SCALE: AS SHOWN
 CHECKED: E.N.C. APPROVED: [Signature]

APPROVED: [Signature] F.A.I. COUNTY: 94 SHEET NO.: 6 TOTAL SHEETS: 48 DRAWING NO.: S-5
 DE LUYP, CATHY & COMPANY CONSULTING ENGINEERS