



**SIGNING LEGEND**

◇ X PROPOSED SIGN

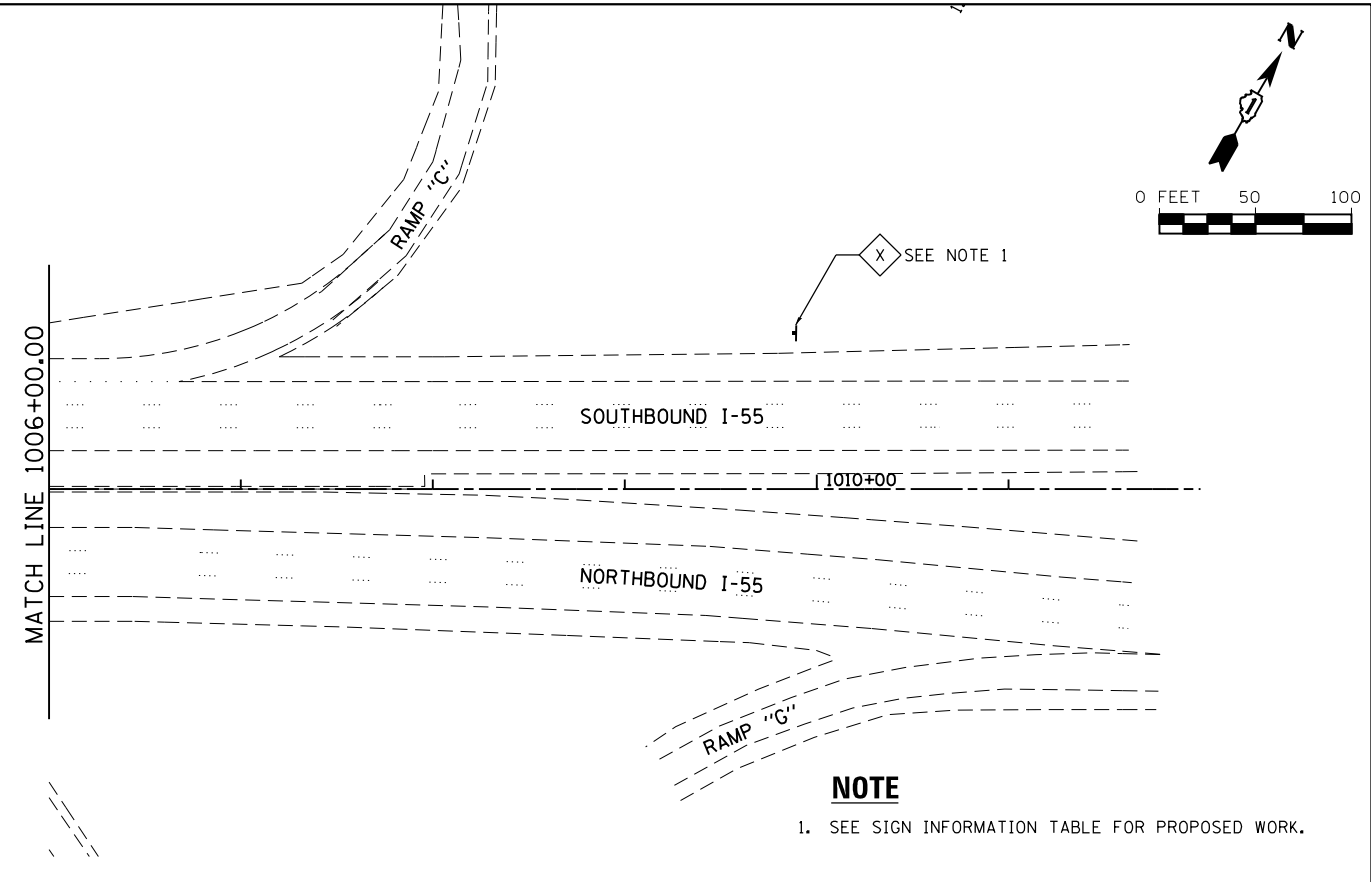

**NOTE**  
1. SEE SIGN INFORMATION TABLE FOR PROPOSED WORK.

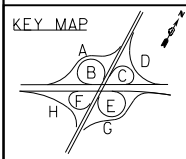

Panel Style: tab1.bsi  
M.U.T.C.D.: 2009 Edition

**SIGN DETAIL**  
1:75

SIGN NUMBER	Sign T & U
WIDTH x HGT.	29'-0" x 9'-6"
BORDER WIDTH	2"
CORNER RADIUS	12"
MOUNTING	Ground
BACKGROUND	TYPE: Reflective COLOR: Green
LEGENDBORDER	TYPE: Reflective COLOR: White/White

SYMBOL	ROT	X	Y	WID	HT
AR_Type A	315	293.4	43.9	23.9	37.8

Panel Style: guide\_exp\_advance\_a.ssi  
M.U.T.C.D.: 2009 Edition

LETTER POSITIONS (X)											LENGTH	SERIES/SIZE			
E	X	I	T	2	7	6	B						E	2000	
24.8	33.7	44.4	47.9	70.4	84.2	99.4	119						106.4	10.15	
N	O	R	T	H										E	2000
139	157.4	173.5	187.3	201.1									74.2	18.15	
C	o	u	n	t	y	L	i	n	e	R	d			EM	2000
24.8	44.8	64.6	85.8	105	119.6	136.6	156.6	175.8	187.8	207.2	220.4	240.4	260.2	248.6	2015

**SIGN T & U DETAIL**

Panel Style: tab1.bsi  
M.U.T.C.D.: 2009 Edition

**SIGN DETAIL**  
1:75

SIGN NUMBER	Sign V & W
WIDTH x HGT.	29'-0" x 9'-6"
BORDER WIDTH	2"
CORNER RADIUS	12"
MOUNTING	Ground
BACKGROUND	TYPE: Reflective COLOR: Green
LEGENDBORDER	TYPE: Reflective COLOR: White/White

SYMBOL	ROT	X	Y	WID	HT
AR_Type A	315	293.4	43.9	23.9	37.8

Panel Style: guide\_exp\_advance\_a.ssi  
M.U.T.C.D.: 2009 Edition

LETTER POSITIONS (X)											LENGTH	SERIES/SIZE				
E	X	I	T	2	7	6	A							E	2000	
23.3	32.2	42.9	46.4	68.9	82.7	97.8	117.5							109.5	10.15	
S	O	U	T	H											E	2000
139	157.5	173.5	188.2	202										75.2	18.15	
C	o	u	n	t	y	L	i	n	e	R	d			EM	2000	
24.8	44.8	64.6	85.8	105	119.6	136.6	156.6	175.8	187.8	207.2	220.4	240.4	260.2	248.6	2015	

**SIGN V & W DETAIL**

FILE NAME = SA\JUL163800-63939\5346\028\Micro\CAD\ Sheets\PI60K77-sh1-pmk4.dgn



1170 SOUTH HOUBOLT ROAD  
JOLIET, ILLINOIS 60431  
(815) 744-4200

USER NAME = dennissw  
MODEL NAME = Default  
PLOT SCALE = 100.0000' / in.  
PLOT DATE = 2/6/2013

DESIGNED - MAG  
DRAWN - DJW  
CHECKED - DWG  
DATE - 01-24-13

REVISED -  
REVISED -  
REVISED -  
REVISED -

**STATE OF ILLINOIS  
DEPARTMENT OF TRANSPORTATION**

**PAVEMENT MARKING & SIGNING PLAN**

SCALE: 1" = 50'  
SHEET 4 OF 5 SHEETS  
STA. TO STA.

F.A.I. RTE.	SECTION	COUNTY	TOTAL SHEETS	SHEET NO.
55	22-1HB-R	COOK/DUPAGE	161	54
CONTRACT NO. 60K77				
ILLINOIS FED. AID PROJECT				