


PROJECT/IMPROVEMENT ENDS
STA 6+50.00

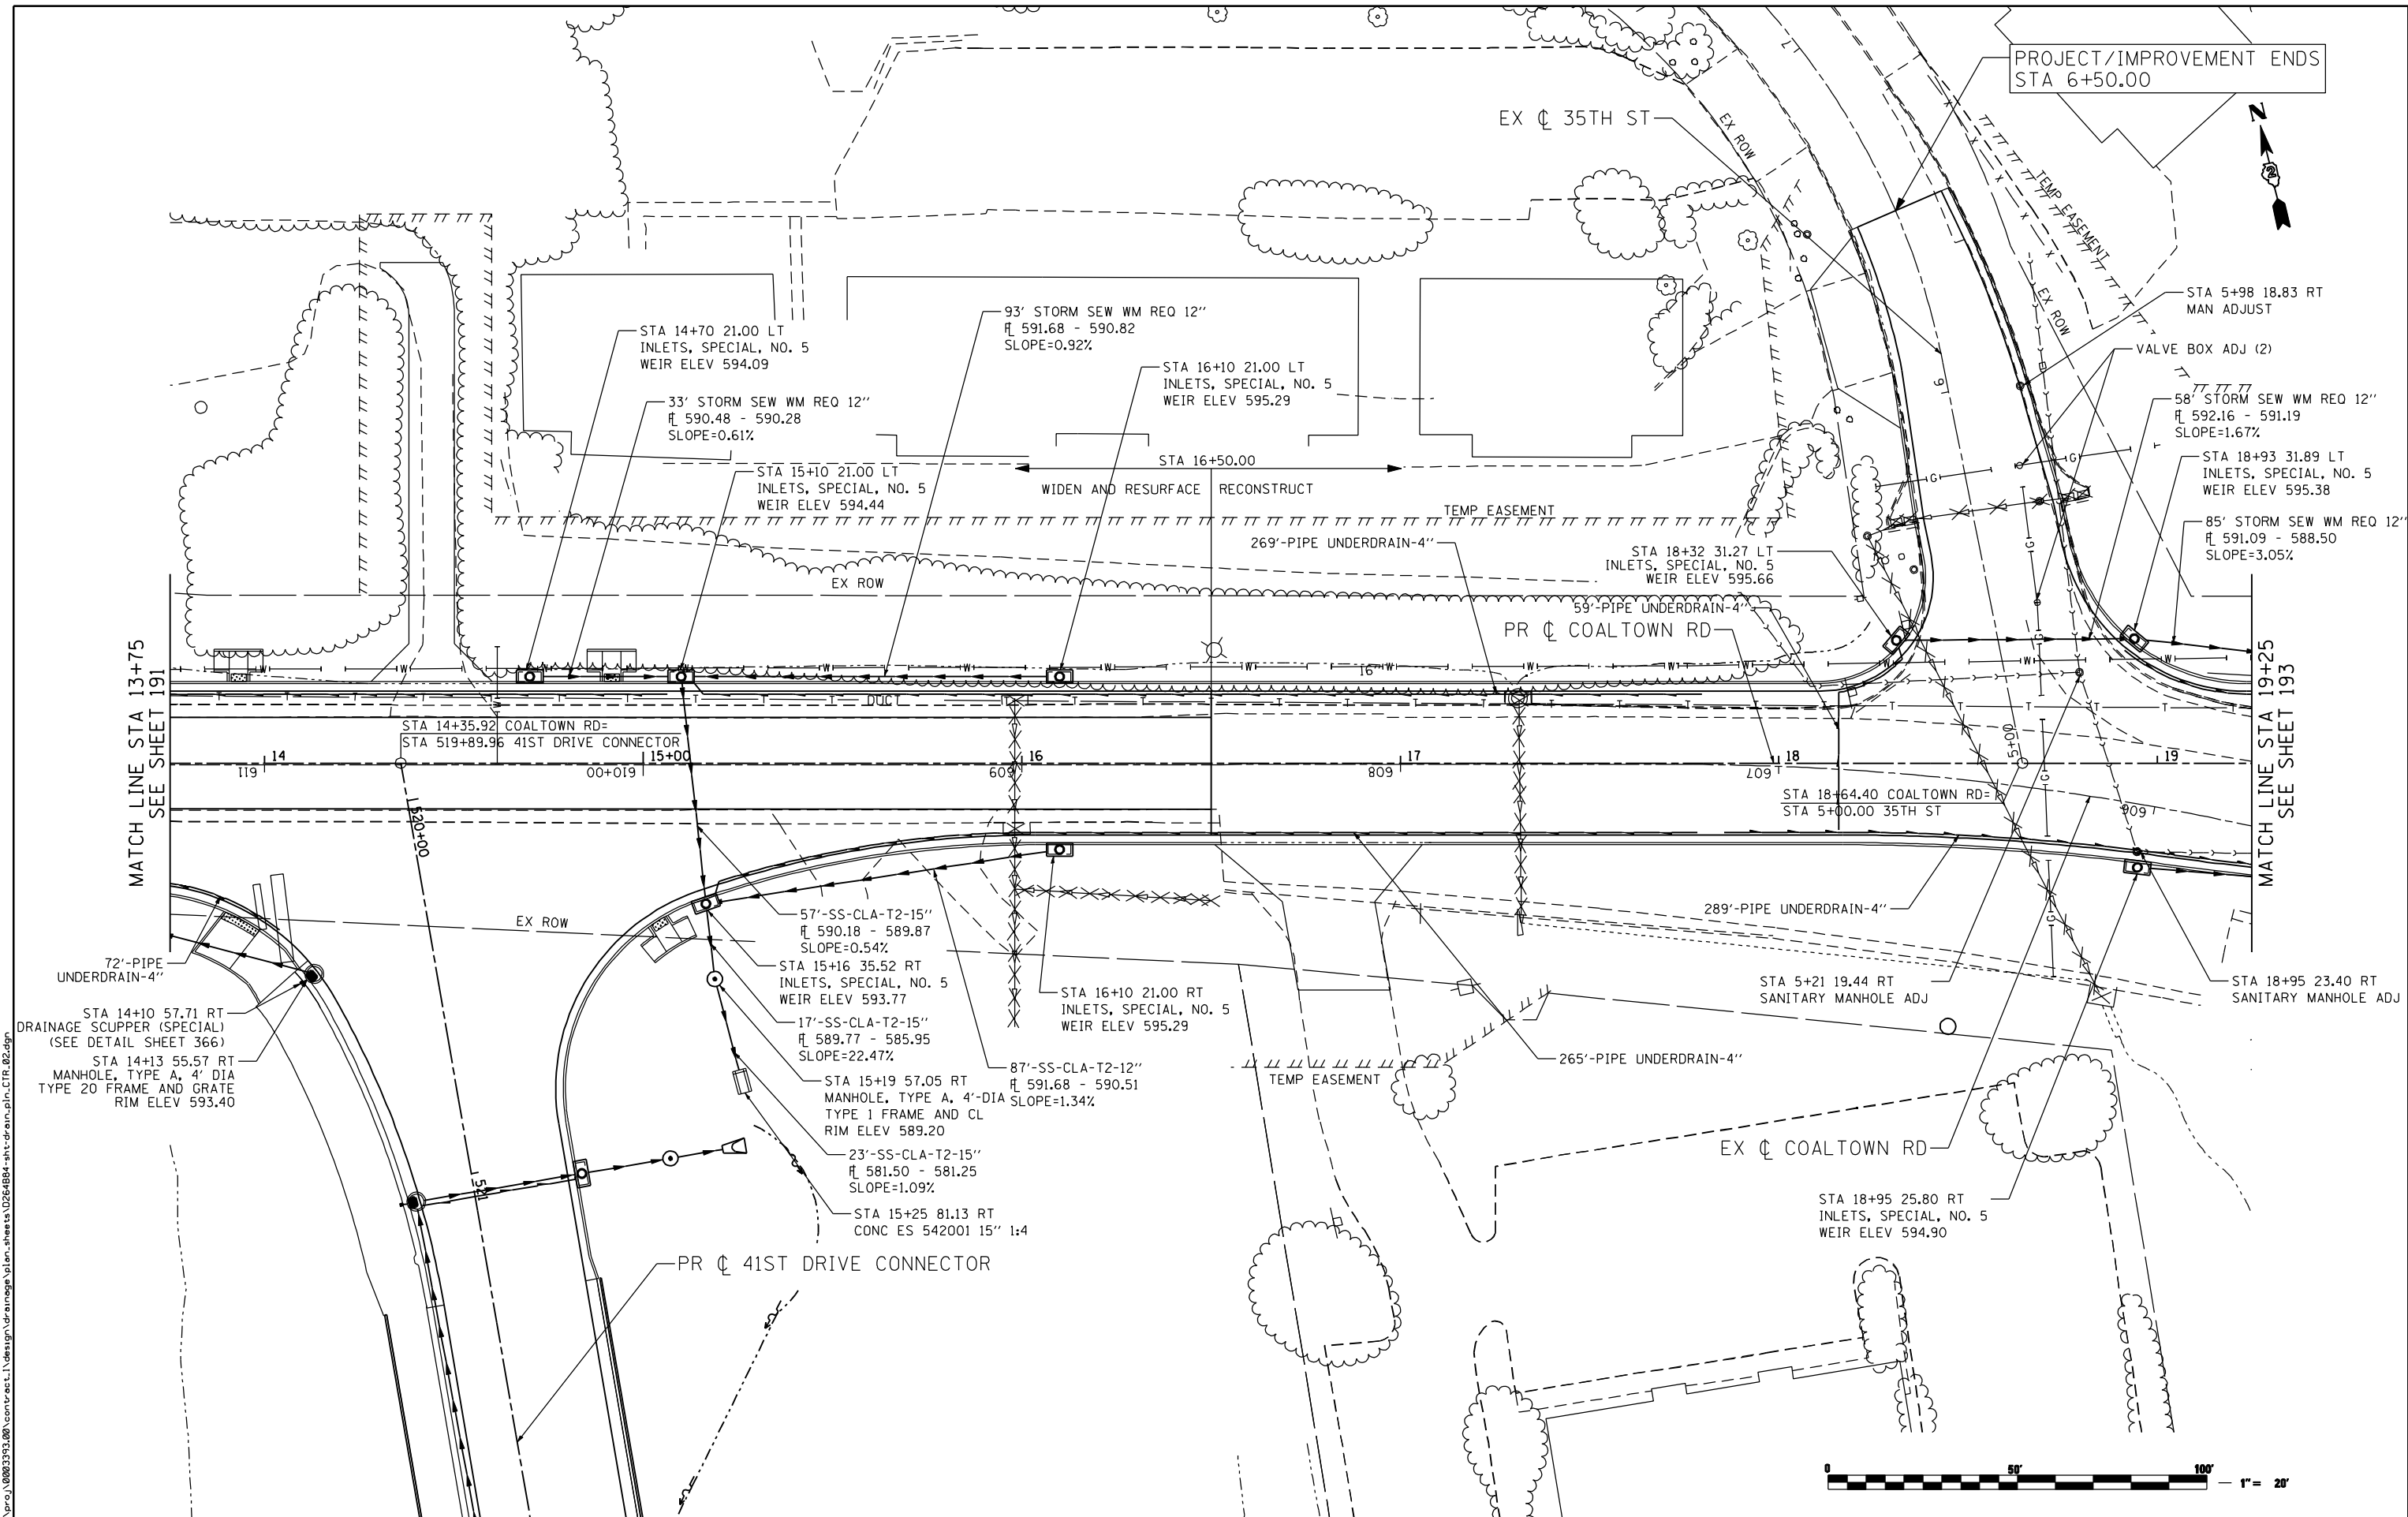

FILE NAME: c:\projects\0803193\08\contract\1\design\drainage\plan_sheets\0264884-int-drain-plan-ctr_02.dwg

Ciorba Group, Inc.
CONSULTING ENGINEERS
6507 North Cumberland Avenue, Suite 402
Chicago, Illinois 60656
Tel. 773.776.4009 Fax 773.776.4014

USER NAME = edow	DESIGNED - JAS	REVISED -
PLOT SCALE = 480.0000' / FT.	DRAWN - AMD	REVISED -
PLOT DATE = 3/11/2013	CHECKED - DMM	REVISED -
	DATE - 3/11/2013	REVISED -

**STATE OF ILLINOIS
DEPARTMENT OF TRANSPORTATION**

**COALTOWN ROAD
PROPOSED DRAINAGE PLANS**

SCALE: 1" = 40' SHEET NO. OF SHEETS STA. TO STA.

F.A.P. RTE.	SECTION	COUNTY	TOTAL SHEETS	SHEET NO.
595	(142-1JR & 142-1HB)	ROCK ISLAND	507	192
CONTRACT NO. 64B84				
ILLINOIS FED. AID PROJECT				