


F.A. NO.	SECTION	COUNTY	TOTAL SHEETS	SHEET NO.
	03-00087-00-LT	COOK	20	4
DUNDEE ROAD STA. 9+50		TO STA. 15+25		
FED. ROAD DISTRICT	ILLINOIS	FED. AID PROJECT		

MATCH LINE STA. 217+50
(SEE SHEET NO. 15)



MATCH LINE STA. 9+50
(SEE SHEET NO. 3)

MATCH LINE STA. 15+25
(SEE SHEET NO. 5)

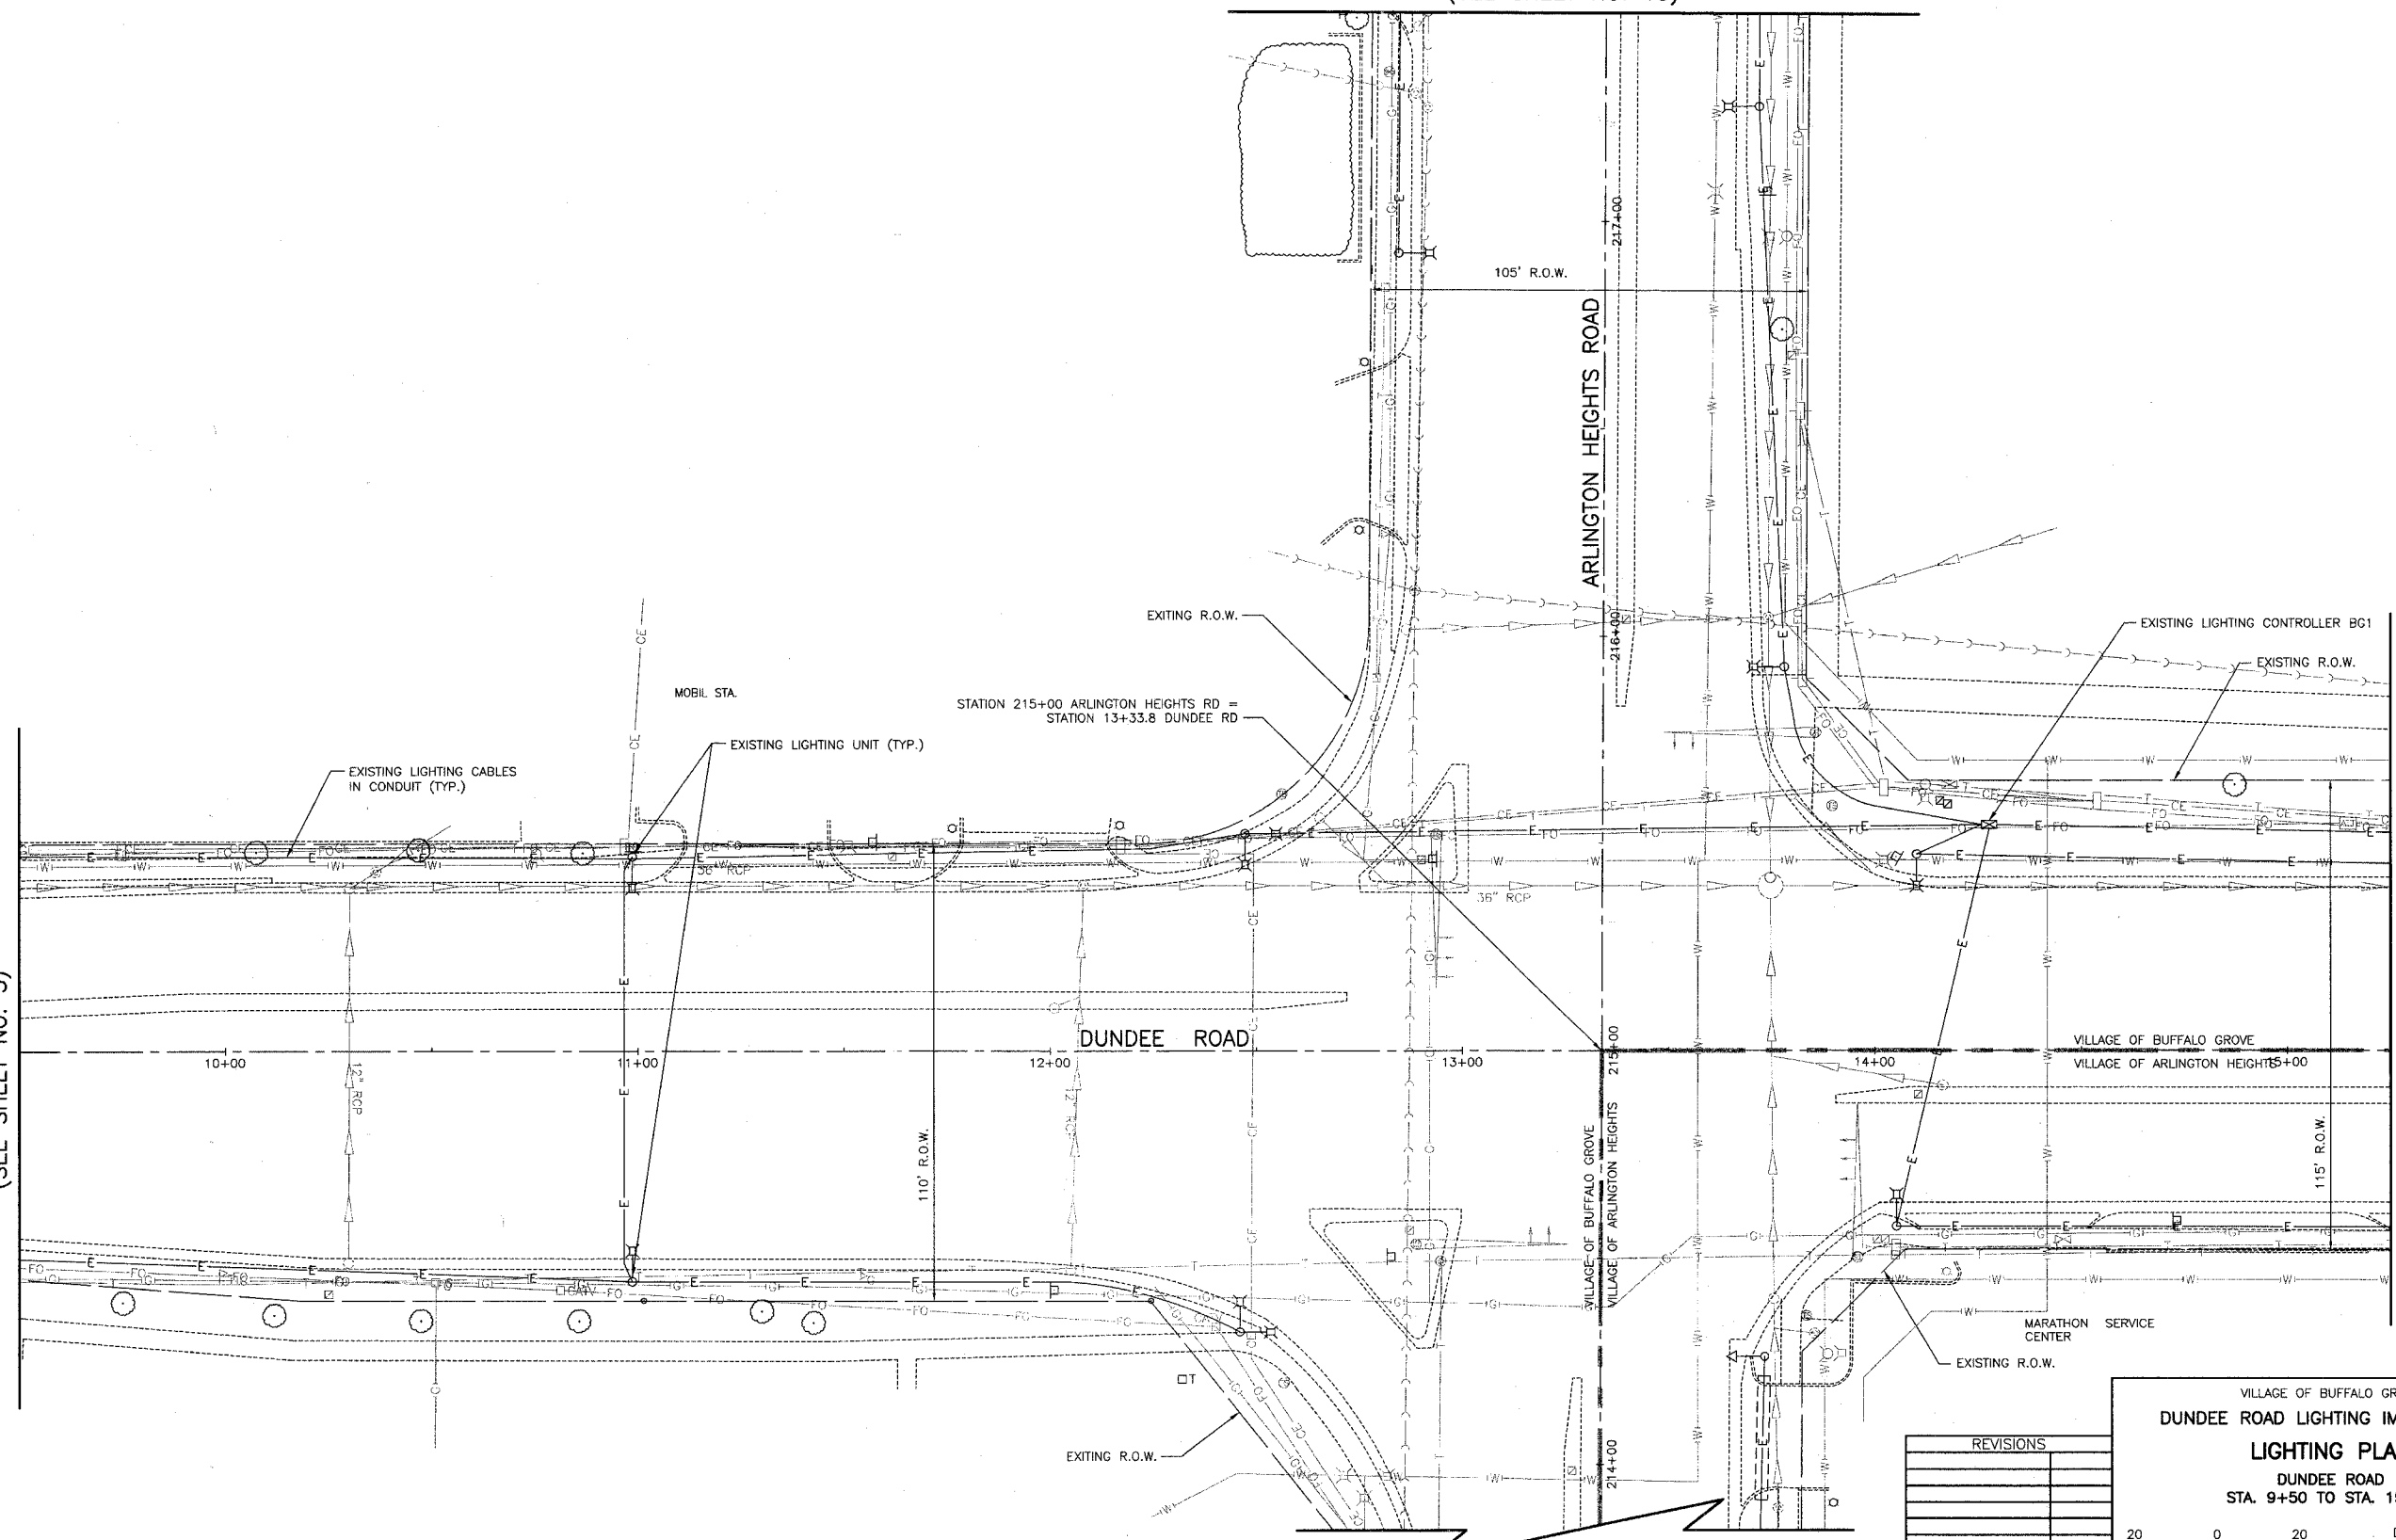

NO.	REVISIONS

VILLAGE OF BUFFALO GROVE
DUNDEE ROAD LIGHTING IMPROVEMENT
LIGHTING PLAN
 DUNDEE ROAD
 STA. 9+50 TO STA. 15+25

DESIGNED BY: S.J.C.
 CHECKED BY: D.N.M.
 DATE: 07/10/2007

SCALE IN FEET