

F.A. RTE.	SECTION	COUNTY	TOTAL SHEETS	SHEET NO.
	03-00026-00-PK	MADISON	38	31

FEDERAL AID PROJECT

**KEYED NOTES**

- 1 QUAZITE TYPE BOX INSTALLED FLUSH IN PAVED AREA. SEE DETAIL A, SHEET E6-01 FOR ADDITIONAL INFORMATION.
- 2 (3) 1" EMPTY CONDUITS WITH PULLWIRE FOR FUTURE SITE LIGHTING CIRCUITS. EXTEND AND CONNECT CONDUITS TO PANEL LP, SEE SHEET E3-01 FOR LOCATION OF PANEL LP. EXTEND CONDUITS 10' BEYOND BUILDING LINE AND CAP OFF BELOW GRADE.
- 3 1" EMPTY CONDUIT WITH PULLWIRE FOR POWER SUPPLY WIRING TO FUTURE FLOOD LIGHT. EXTEND CONDUIT TO PANEL LP VIA RELAY PANEL.
- 4 EXTEND AND CONNECT TO PANEL VIA RELAY PANEL.
- 5 (2) 1" EMPTY CONDUITS WITH PULLWIRE FOR POWER SUPPLY WIRING TO FUTURE FOUNTAIN PUMP AND FUTURE WATER WALL PUMP.
- 6 JUNCTION BOXES FOR CONNECTION OF FUTURE EMERGENCY POWER SUPPLY. SEE DETAILS D AND E ON SHEET E6-01.

211 N. Broadway  
Suite 1000  
St. Louis, MO 63102  
(314) 241-0100  
FAX (314) 241-0108

**KAI**

**PHASE 2B  
LEWIS AND CLARK MEMORIAL TOWER  
VILLAGE OF HARTFORD, ILLINOIS  
HARTFORD, ILLINOIS 62049**

SHEET TITLE  
**PLAZA  
LIGHTING PLAN**


REV. NO.	REMARKS	DATE

KENNEDY PROJECT NO  
KAI# 10-02048

ISSUE DATE  
12-JULY-05

SHEET NO  
**E2-02**

© 2005 KENNEDY ASSOCIATES INCORPORATED

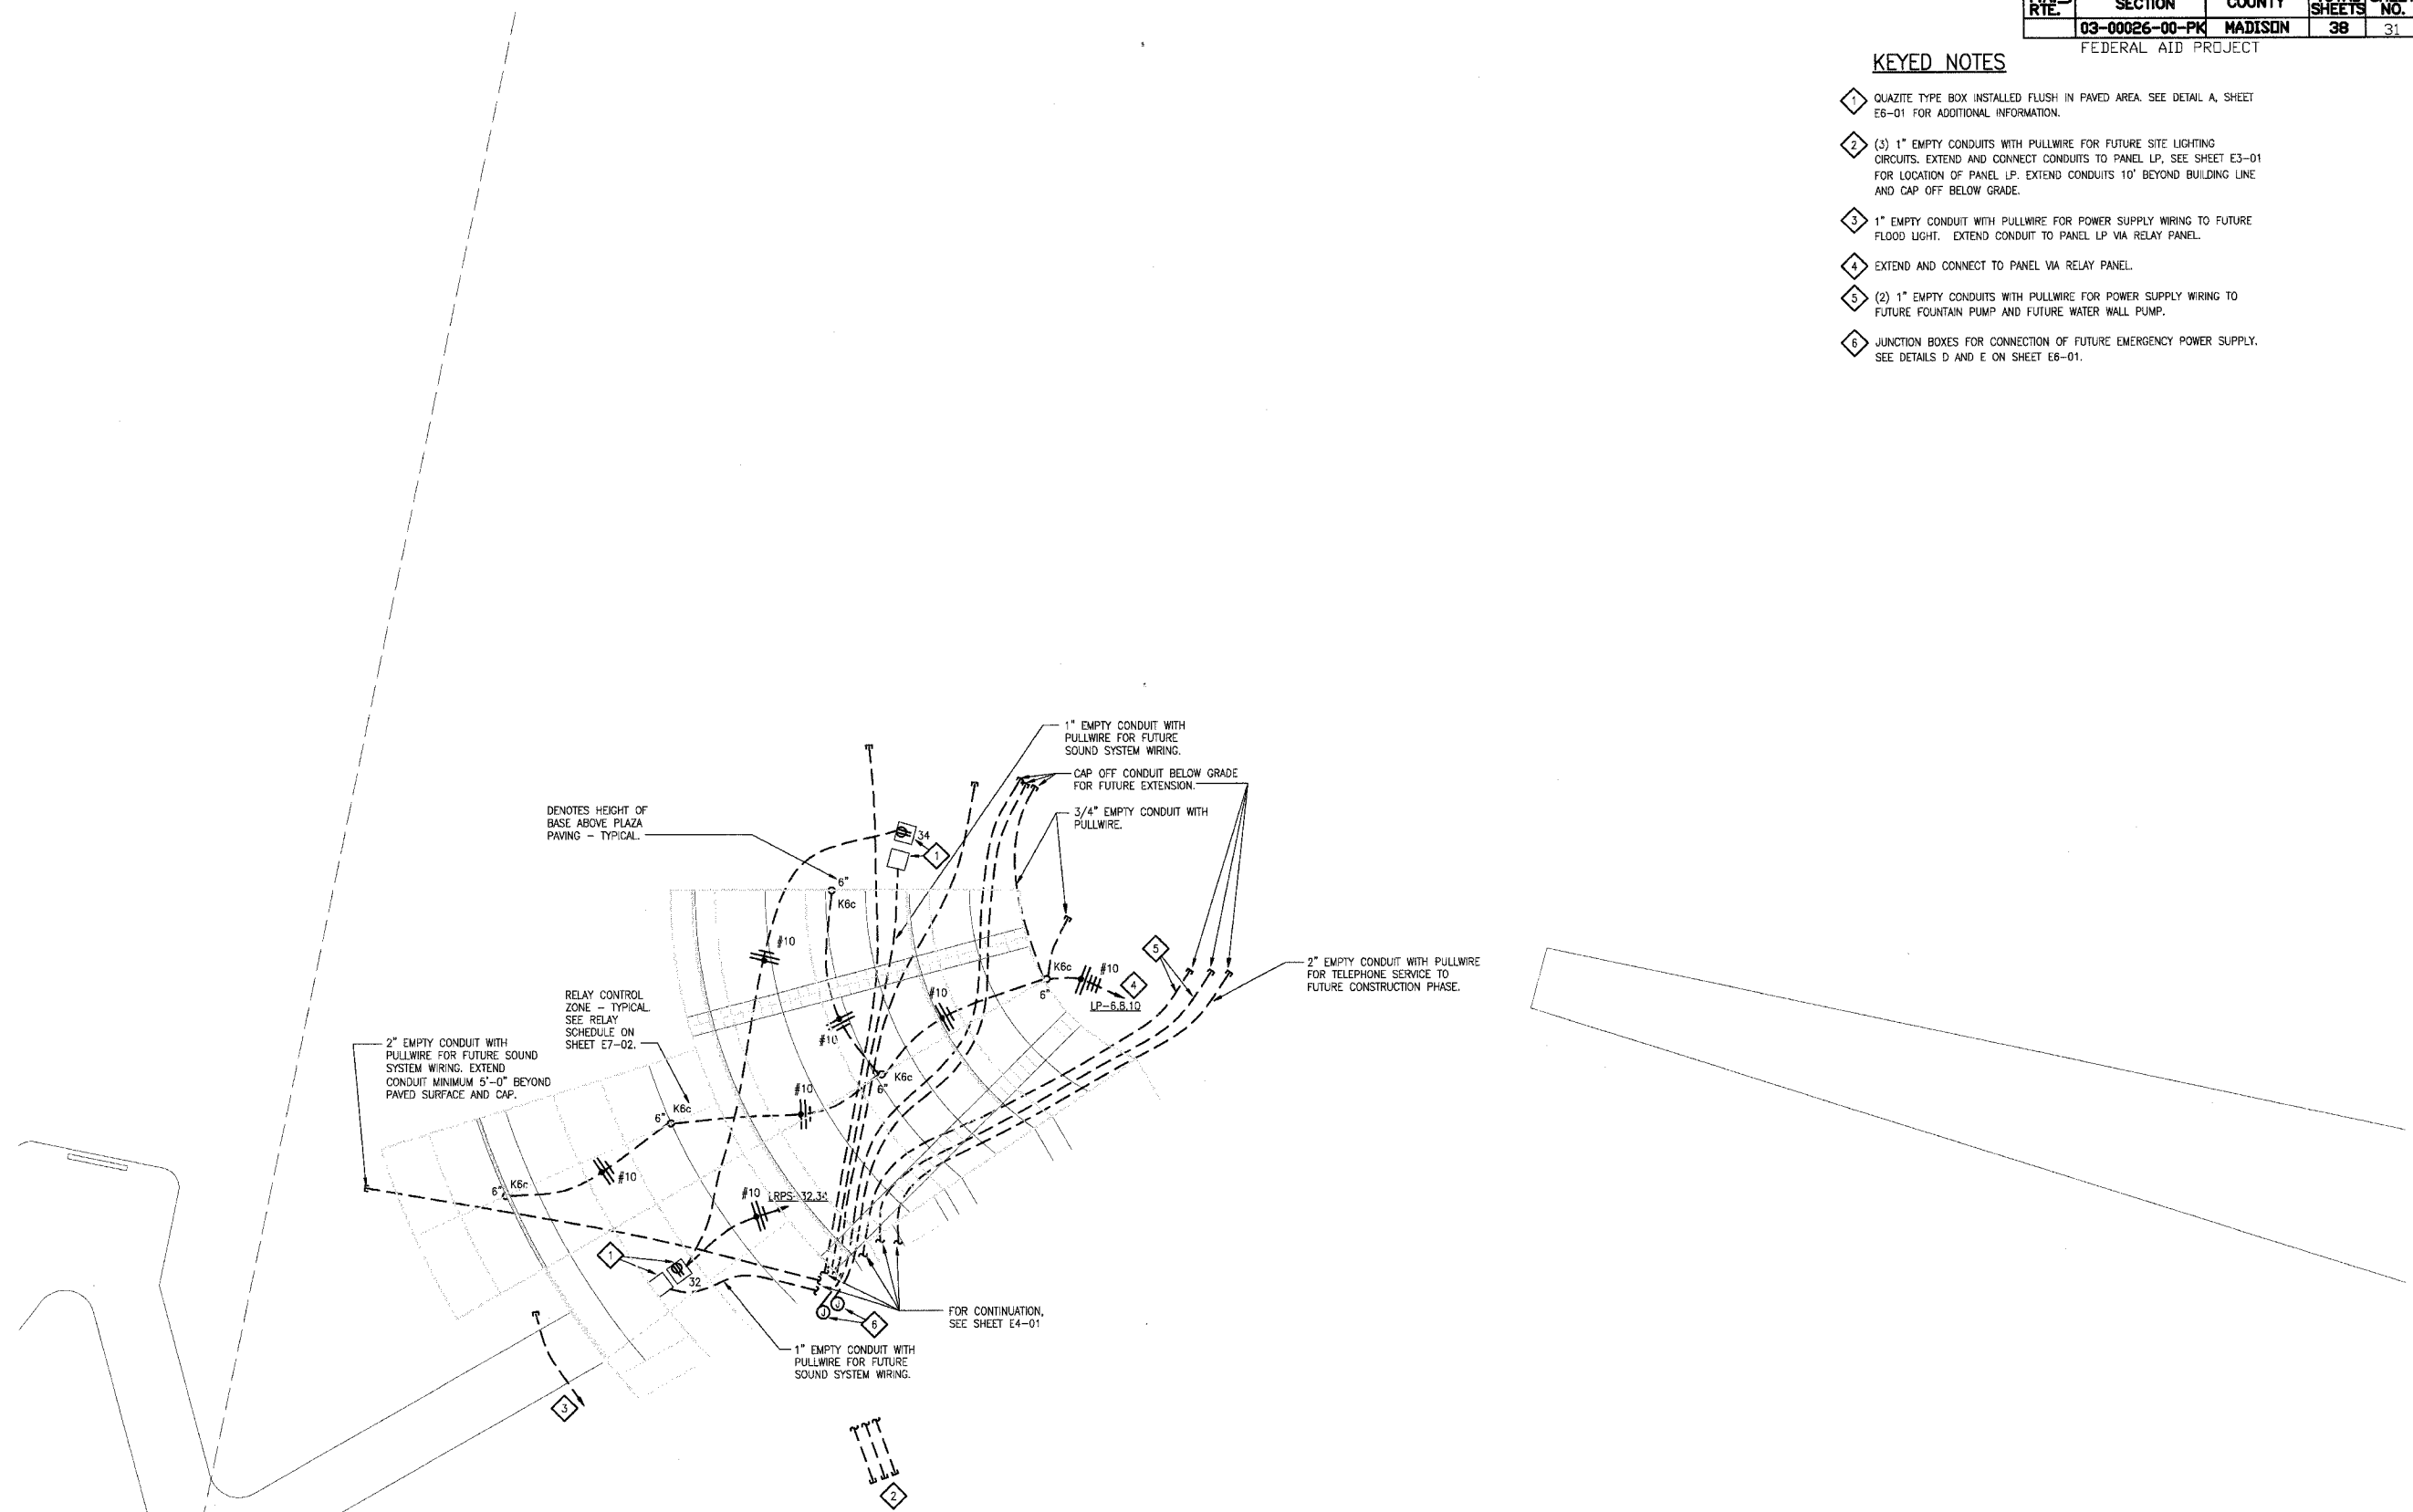

**A PLAZA LIGHTING AND POWER PLAN**  
1/8"=1'-0"  
0 4' 8' 16' 32'

P:\2002\10-02048\600DSC\E202-02.DWG | 12/7/2005 5:10:16 PM | Xref to: T824360DL SITE-IDD B5-PLAN-IDD E2885202 | Images: none