




P10_DRPP_SHT06_HRGREEN.dgn

 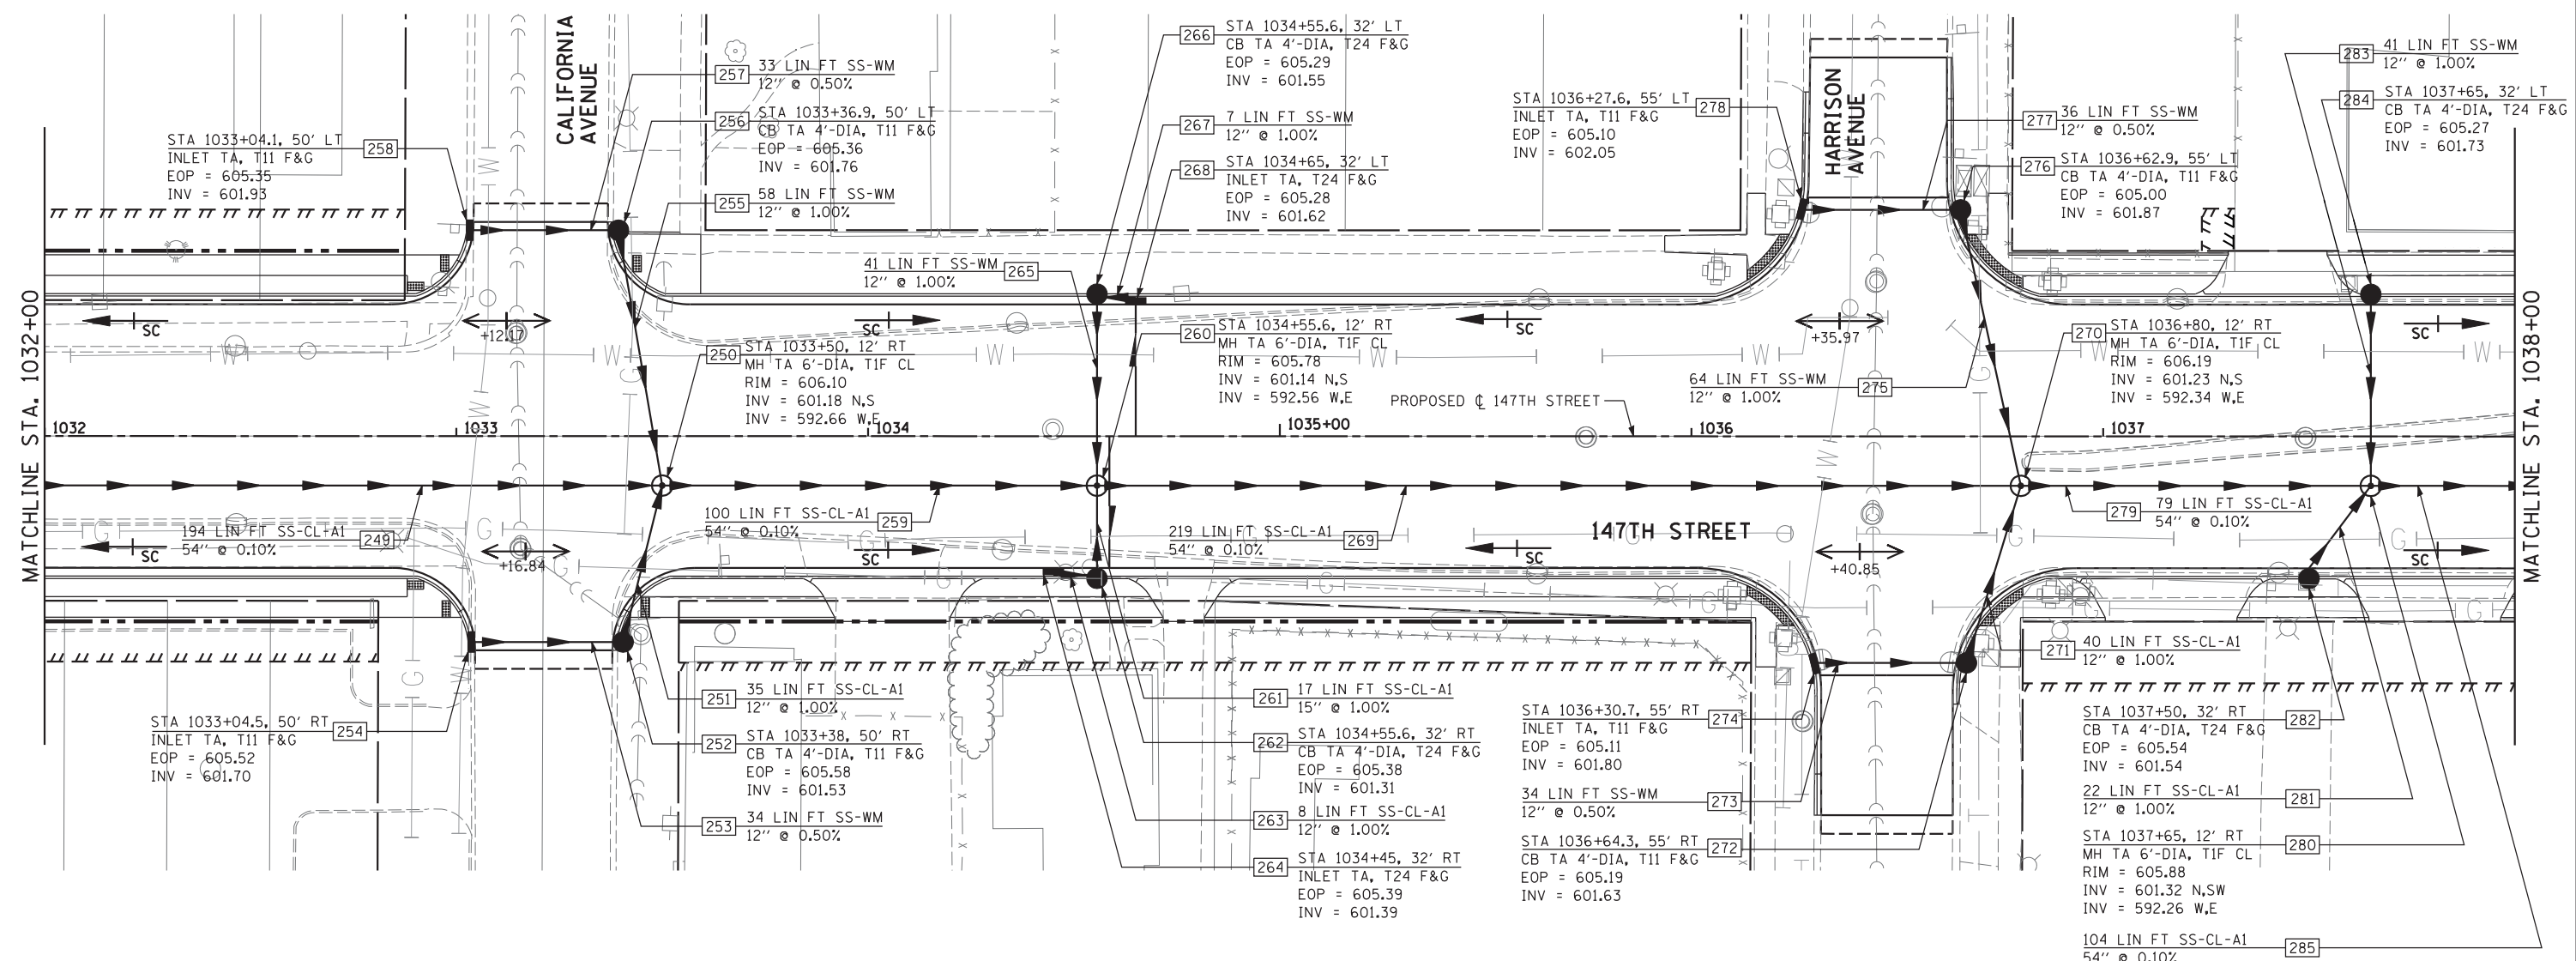


PIPE UNDERDRAINS

STA 1034+55.6 RT	32 LIN FT PIPE UNDERDRAINS 4"
STA 1034+65 LT	32 LIN FT PIPE UNDERDRAINS 4"
STA 1036+28.2 LT	18 LIN FT PIPE UNDERDRAINS 4"
STA 1036+31.2 RT	17 LIN FT PIPE UNDERDRAINS 4"
STA 1036+62.3 LT	17 LIN FT PIPE UNDERDRAINS 4"
STA 1036+63.7 RT	17 LIN FT PIPE UNDERDRAINS 4"

LEGEND

- — — — — EXISTING RIGHT-OF-WAY
- - - - - PROPOSED RIGHT-OF-WAY
- ||||| PROPOSED TEMPORARY EASEMENT



<p>HRGreen.com Illinois Professional Design Firm #184-001322</p>	USER NAME =	DESIGNED - JRS	REVISED - JRS 12/01/2011
	DRAWN - MJF	REVISED - JRS 02/15/2012	
	PLOT SCALE =	CHECKED - APS	REVISED - JRS 05/04/2012
	PLOT DATE	DATE - 7/22/2011	REVISED -

**STATE OF ILLINOIS
DEPARTMENT OF TRANSPORTATION**

147TH STREET PROJECT			
PROPOSED DRAINAGE AND UTILITY PLAN - 147TH STREET			
SCALE: 1"=20'	SHEET NO. 6 OF 23 SHEETS	STA. 1032+00 TO STA. 1038+00	

F.A.I. R.T.E.	SECTION	COUNTY	TOTAL SHEETS	SHEET NO.
57	(0405-1 & 0506-2) R-1	COOK	577	226
FED. ROAD DIST. NO.			CONTRACT NO. 60M57	
ILLINOIS FED. AID PROJECT				