


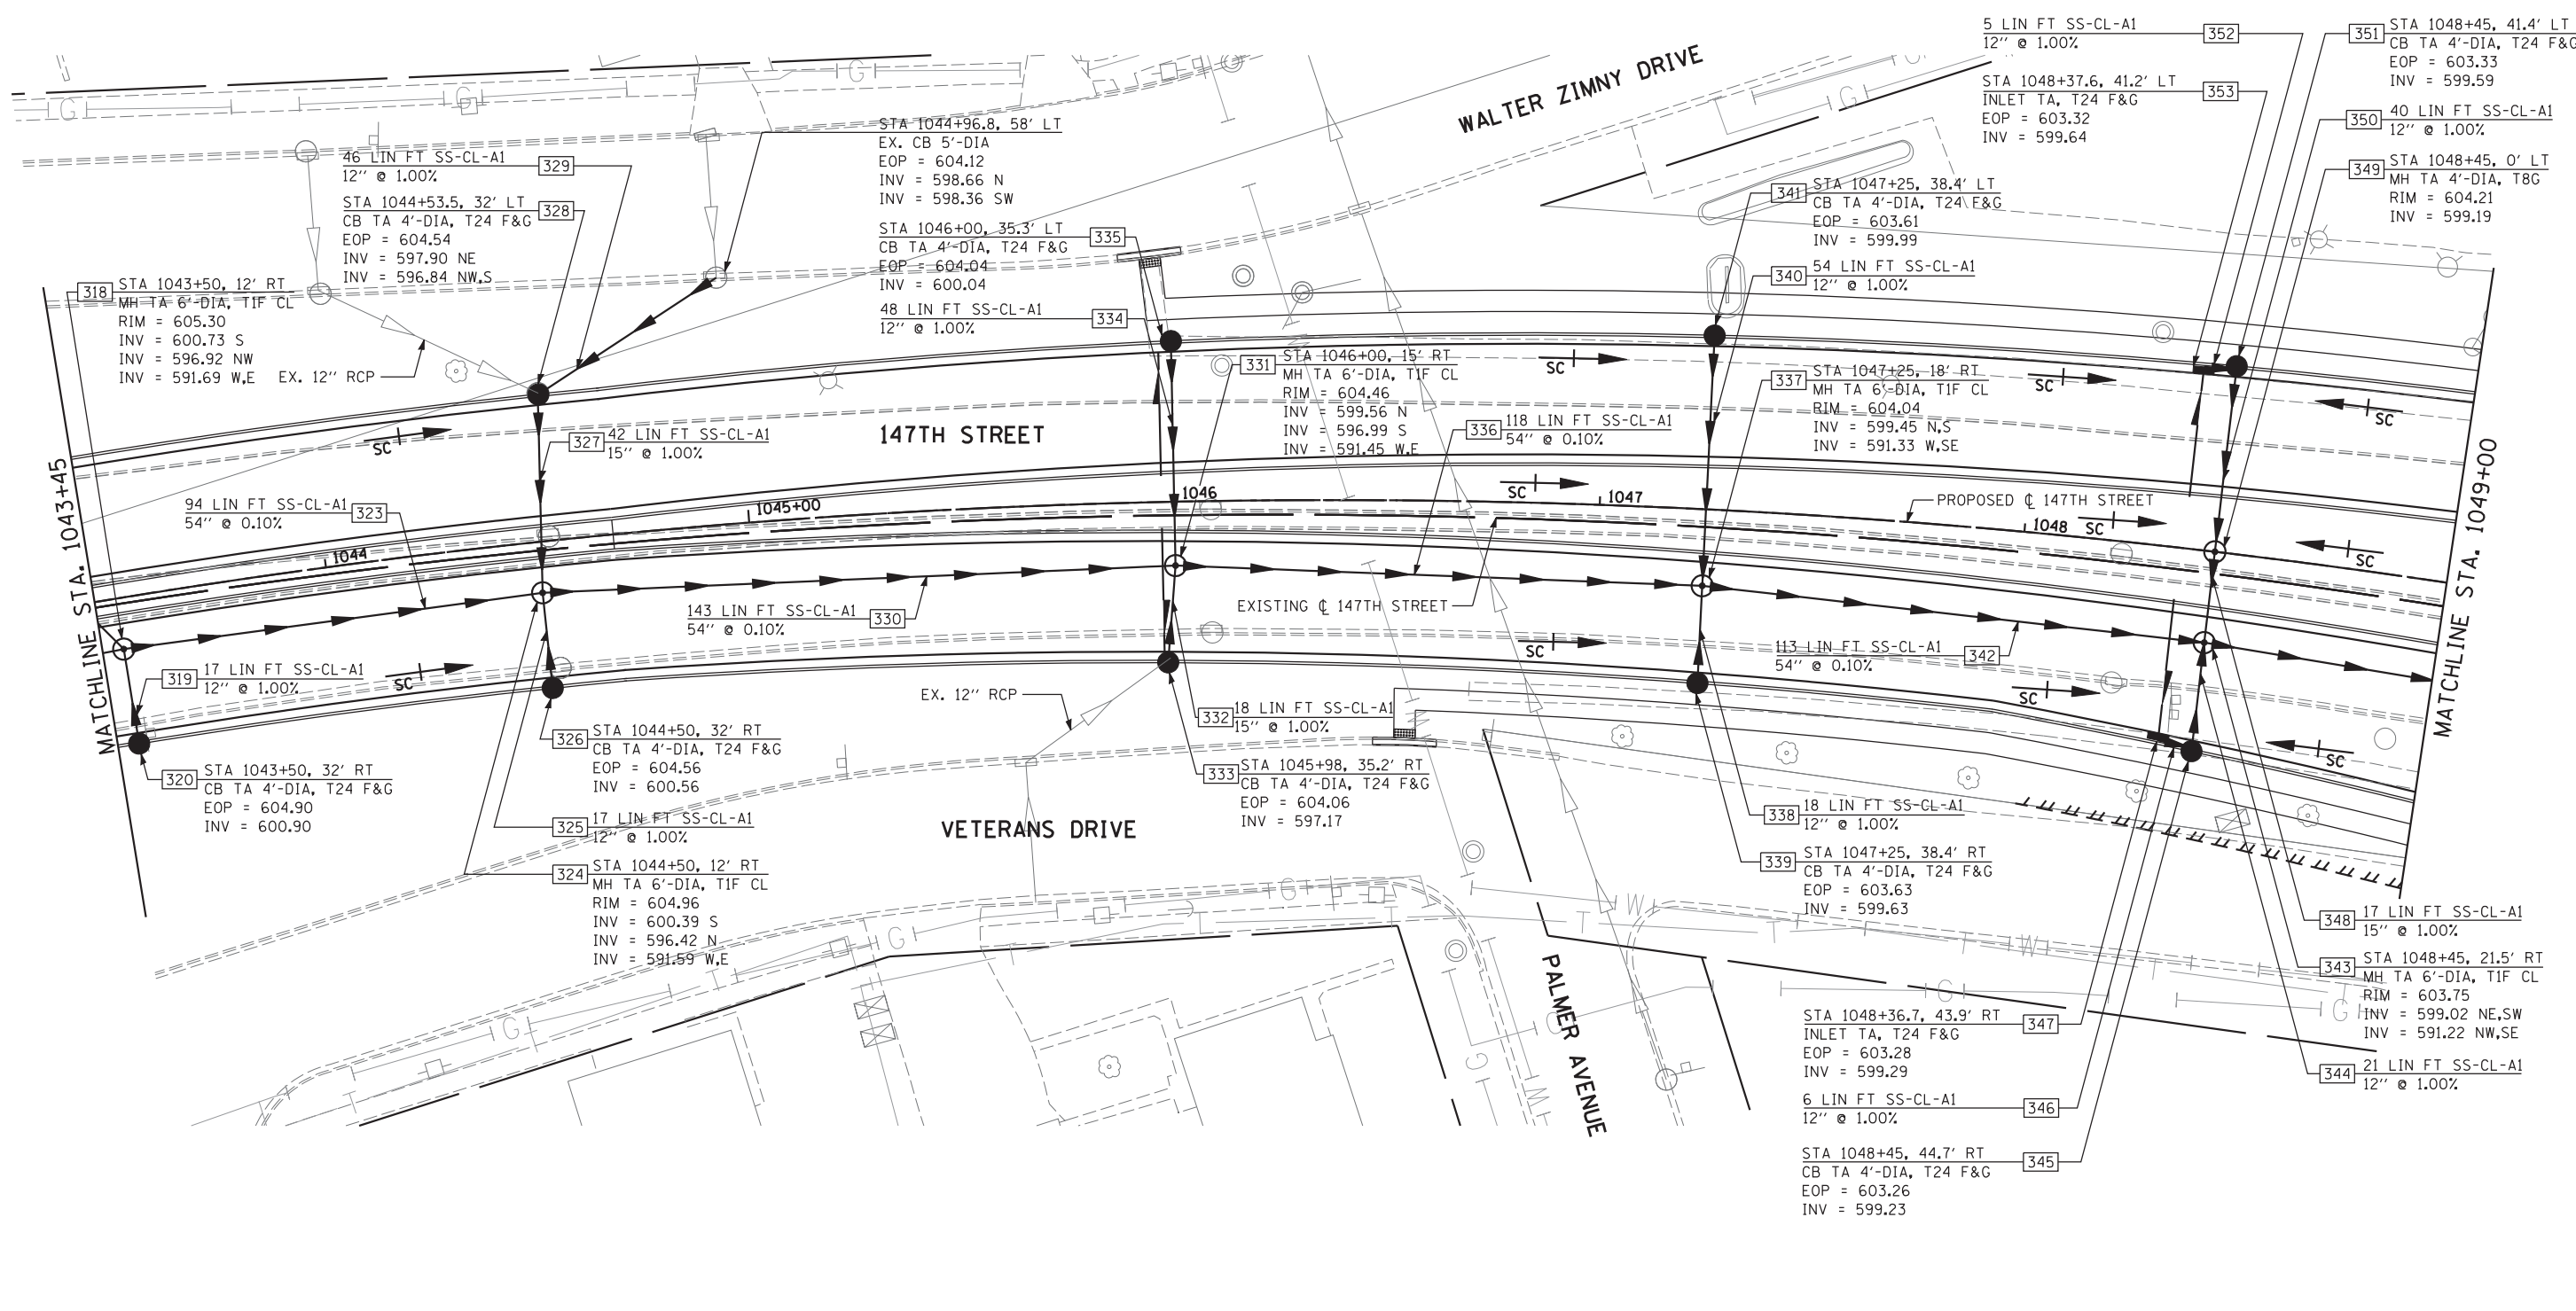

P10_DRPP_SHT08_HRGREEN.dgn


4/26/2012 11:21:56 AM



STA 1045+98 RT	29 LIN FT PIPE UNDERDRAINS 4"
STA 1046+00 LT	29 LIN FT PIPE UNDERDRAINS 4"
STA 1048+36.7 RT	32 LIN FT PIPE UNDERDRAINS 4"
STA 1048+37.6 LT	29 LIN FT PIPE UNDERDRAINS 4"

LEGEND

- — — — — EXISTING RIGHT-OF-WAY
- - - - - PROPOSED RIGHT-OF-WAY
- ||||| PROPOSED TEMPORARY EASEMENT

 

HRGreen.com
 Illinois Professional Design Firm
 #184-001322

USER NAME =	DESIGNED - JRS	REVISED - JRS 12/01/2011
	DRAWN - MJF	REVISED - JRS 02/15/2012
PLOT SCALE =	CHECKED - APS	REVISED - JRS 05/04/2012
PLOT DATE	DATE - 7/22/2011	REVISED -

**STATE OF ILLINOIS
 DEPARTMENT OF TRANSPORTATION**

**147TH STREET PROJECT
 PROPOSED DRAINAGE AND UTILITY PLAN - 147TH STREET**

SCALE: 1"=20' SHEET NO. 8 OF 23 SHEETS STA. 1043+45 TO STA. 1049+00

F.A.I. RTE.	SECTION	COUNTY	TOTAL SHEETS	SHEET NO.
57	(0405-1 & 0506-2) R-1	COOK	577	228
FED. ROAD DIST. NO.			CONTRACT NO. 60M57	
ILLINOIS FED. AID PROJECT				