


P10_DRPP_SHT12_HRGREEN.dgn 4/25/2012 11:22:17 AM

 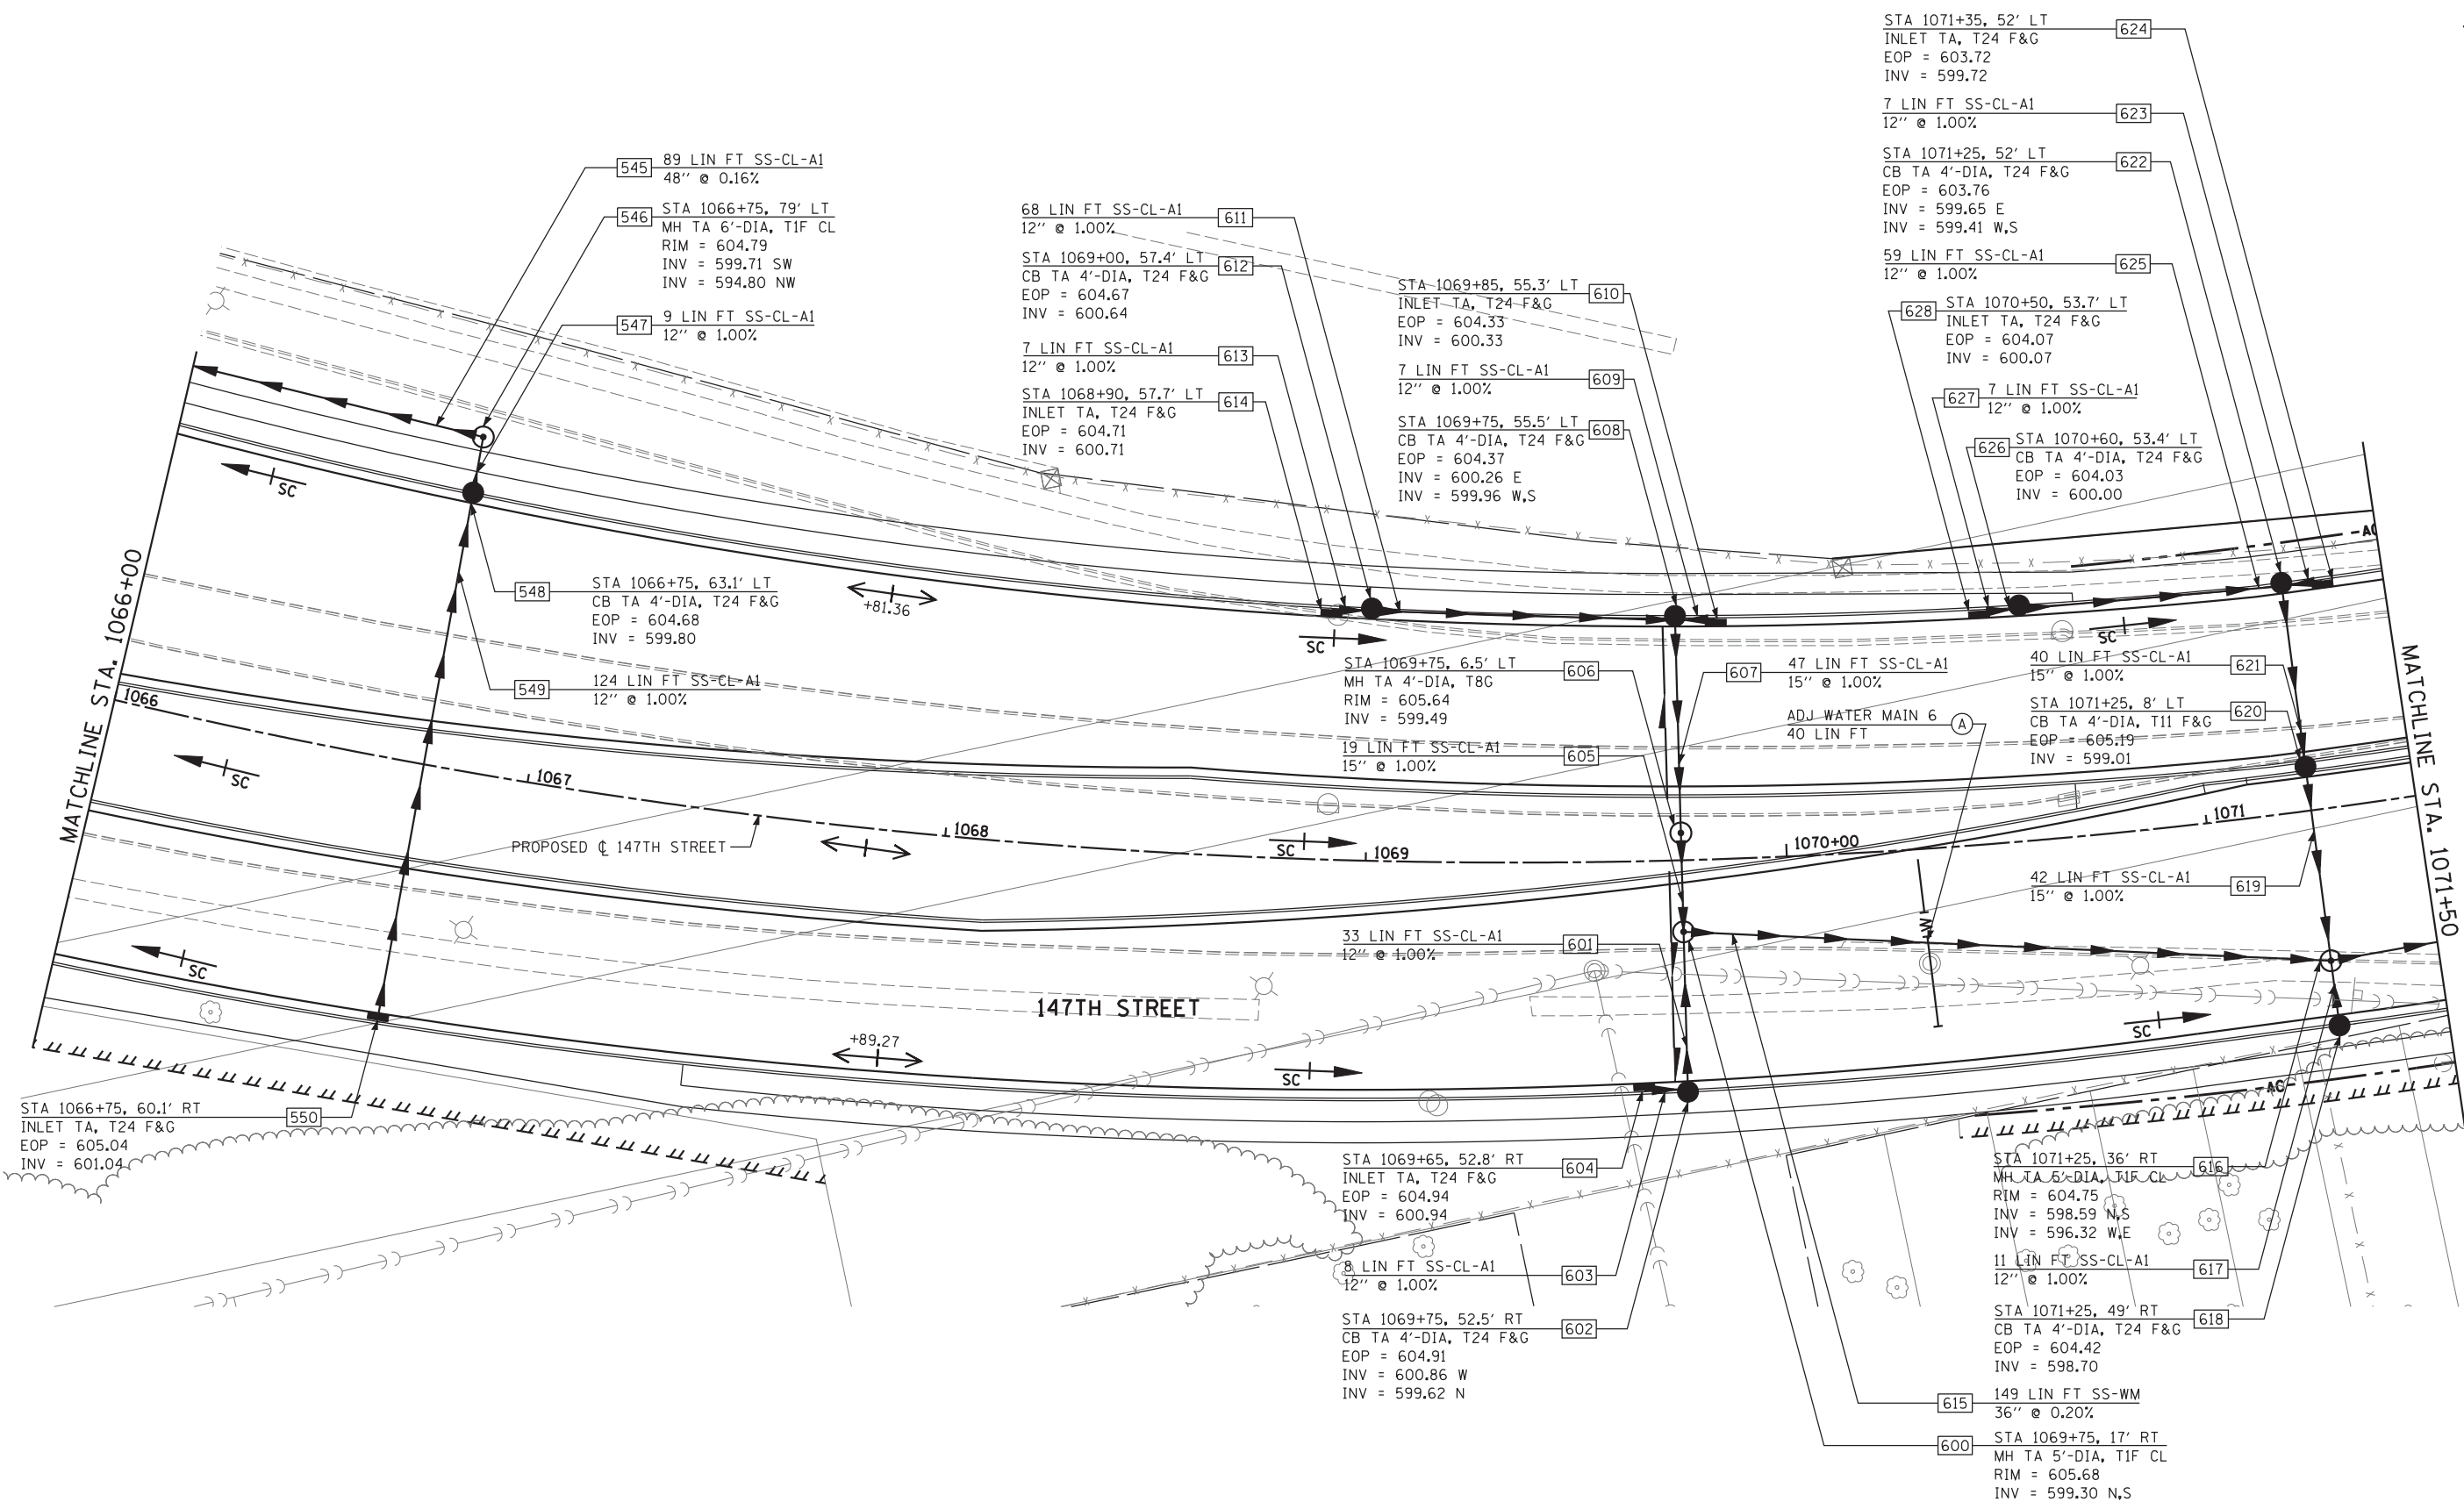


PIPE UNDERDRAINS

STA 1069+75 LT	41 LIN FT PIPE UNDERDRAINS 4"
STA 1069+75 RT	50 LIN FT PIPE UNDERDRAINS 4"

LEGEND

	EXISTING RIGHT-OF-WAY
	PROPOSED RIGHT-OF-WAY
	PROPOSED TEMPORARY EASEMENT



USER NAME =	DESIGNED - JRS	REVISED - JRS 12/01/2011
DRAWN - MJF	REVISED - JRS 02/15/2012	
PLOT SCALE =	CHECKED - APS	REVISED - JRS 05/04/2012
PLOT DATE	DATE - 7/22/2011	REVISED -

**STATE OF ILLINOIS
DEPARTMENT OF TRANSPORTATION**

**147TH STREET PROJECT
PROPOSED DRAINAGE AND UTILITY PLAN - 147TH STREET**

SCALE: 1"=20' SHEET NO. 12 OF 23 SHEETS STA. 1066+00 TO STA. 1071+50

F.A.I. RTE.	SECTION	COUNTY	TOTAL SHEETS	SHEET NO.
57	(0405-1 & 0506-2) R-1	COOK	577	232
FED. ROAD DIST. NO.			ILLINOIS FED. AID PROJECT	
			CONTRACT NO. 60M57	