




P10_DRPP_SHT16_HRGREEN.dgn

 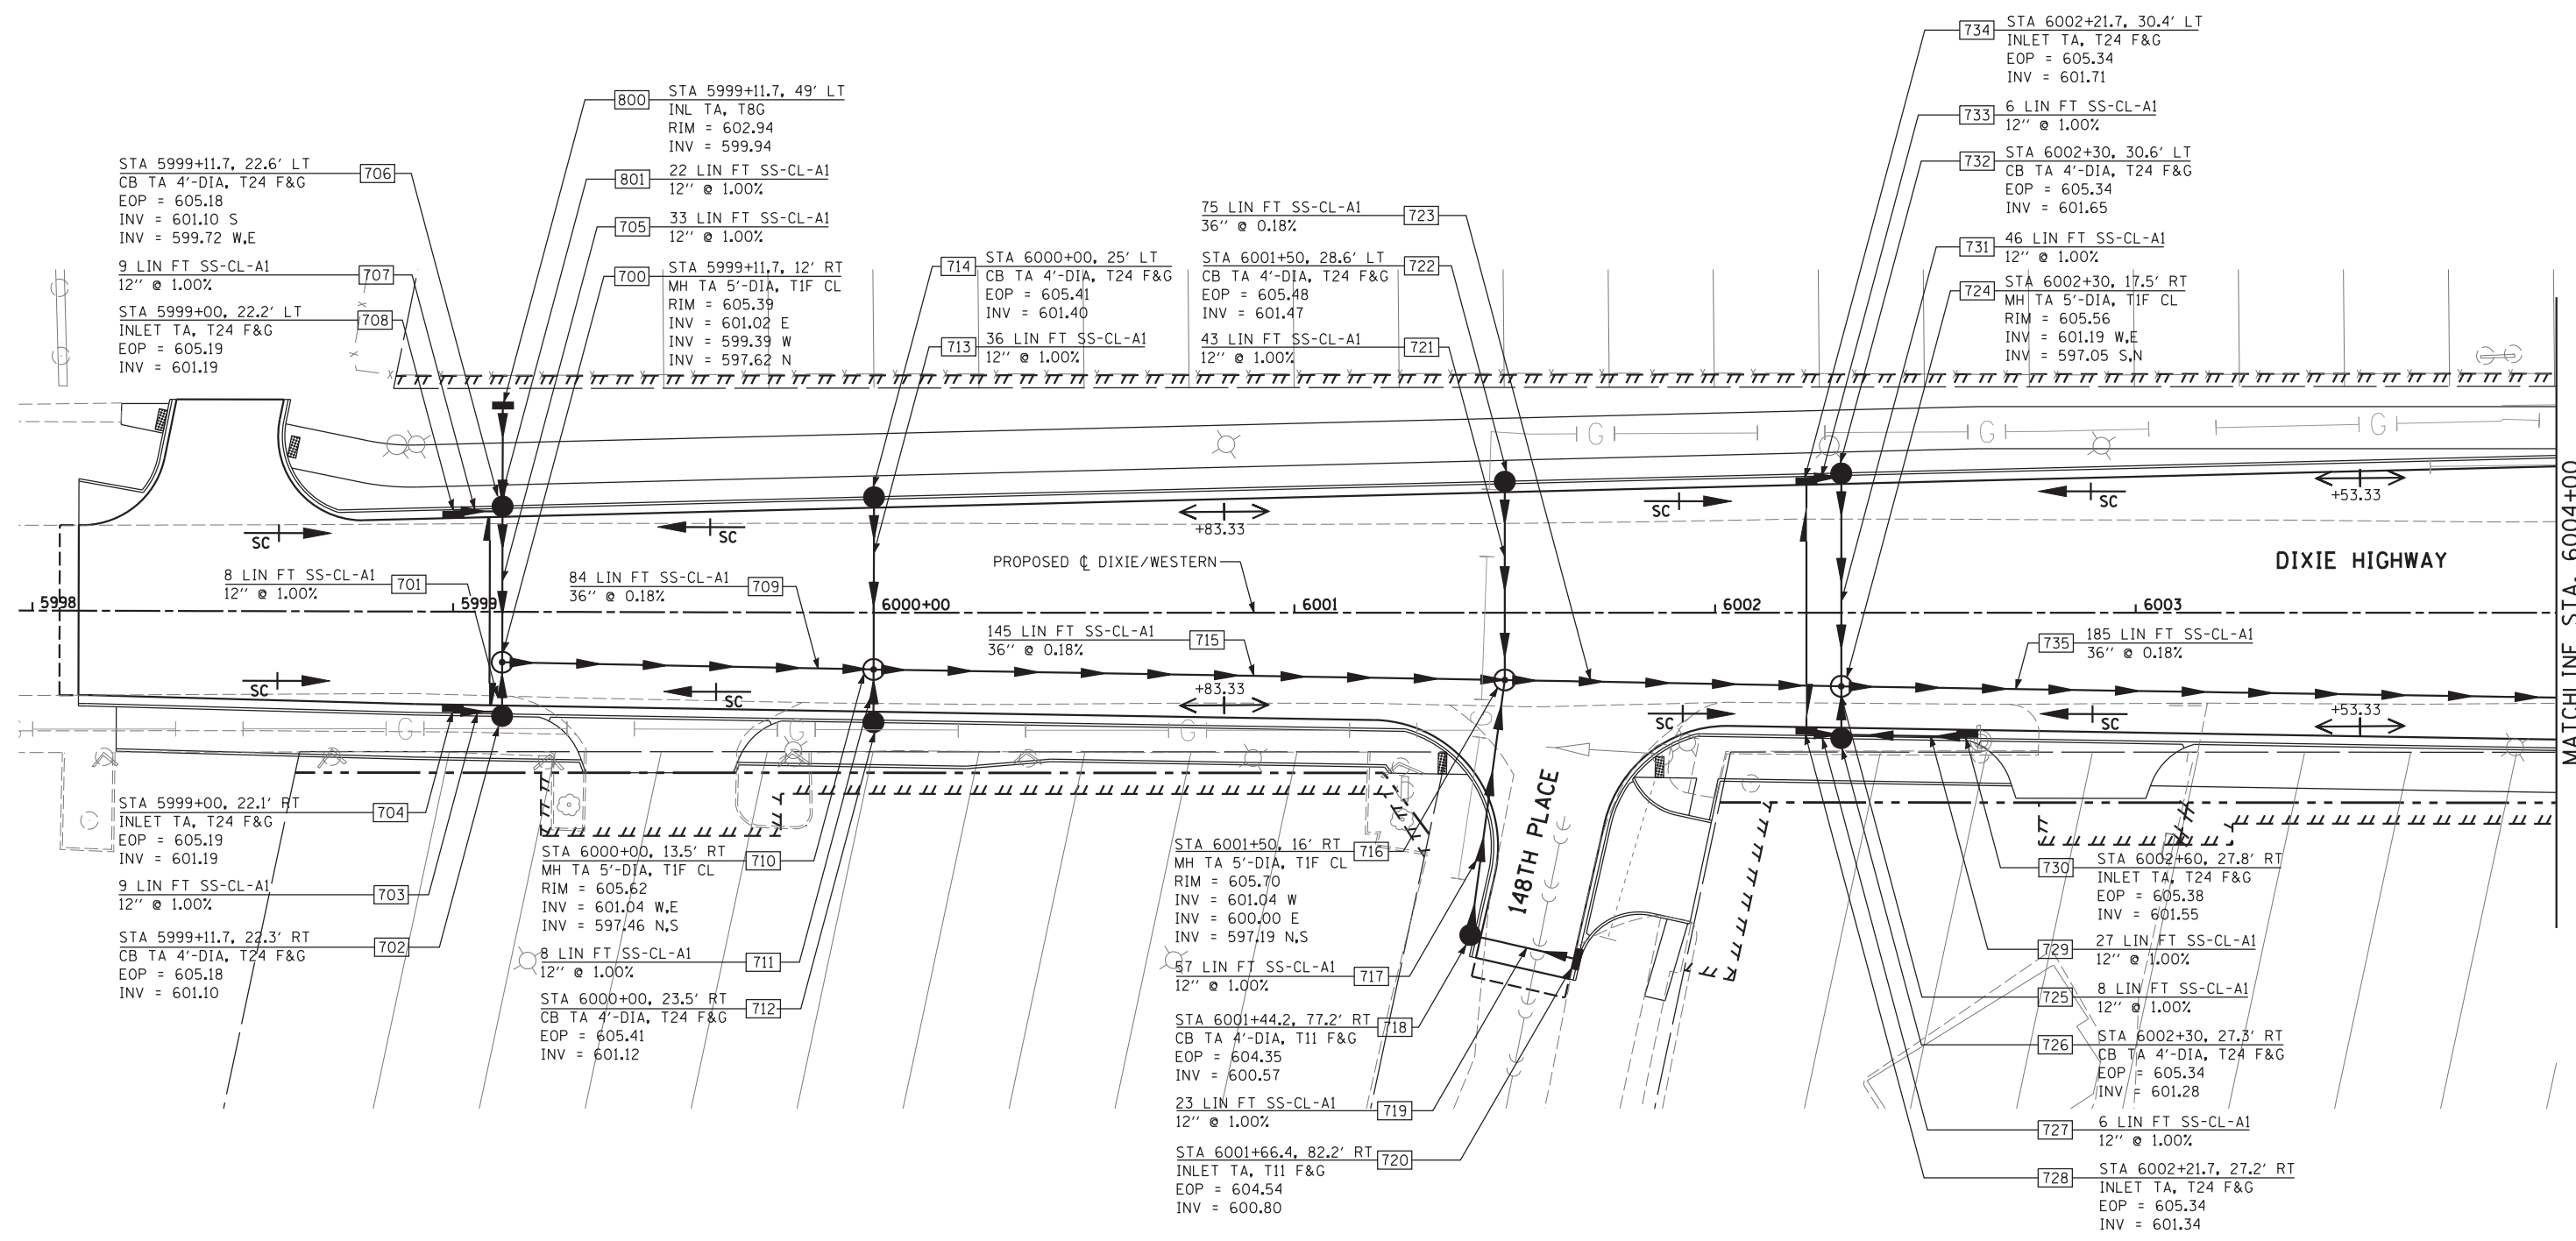


MATCHLINE STA. 6004+00

PIPE UNDERDRAINS

STA 5999+11.7 LT	23 LIN FT PIPE UNDERDRAINS 4"
STA 5999+11.7 RT	23 LIN FT PIPE UNDERDRAINS 4"
STA 6002+21.7 LT	31 LIN FT PIPE UNDERDRAINS 4"
STA 6002+21.7 RT	28 LIN FT PIPE UNDERDRAINS 4"

LEGEND	
	EXISTING RIGHT-OF-WAY
	PROPOSED RIGHT-OF-WAY
	PROPOSED TEMPORARY EASEMENT



	USER NAME =	DESIGNED - JRS	REVISED - JRS 12/01/2011
		DRAWN - MJF	REVISED - JRS 02/15/2012
	PLOT SCALE =	CHECKED - APS	REVISED - JRS 05/04/2012
	PLOT DATE	DATE - 7/22/2011	REVISED -

STATE OF ILLINOIS
DEPARTMENT OF TRANSPORTATION

147TH STREET PROJECT			
PROPOSED DRAINAGE AND UTILITY PLAN - DIXIE HIGHWAY			
SCALE: 1"=20'	SHEET NO. 16 OF 23 SHEETS	STA. 5998+00 TO STA. 6004+00	

F.A.I. RTE.	SECTION	COUNTY	TOTAL SHEETS	SHEET NO.
57	(0405-1 & 0506-2) R-1	COOK	577	236
FED. ROAD DIST. NO. ILLINOIS FED. AID PROJECT			CONTRACT NO. 60M57	