 



...D160M57-sht-light7.dgn

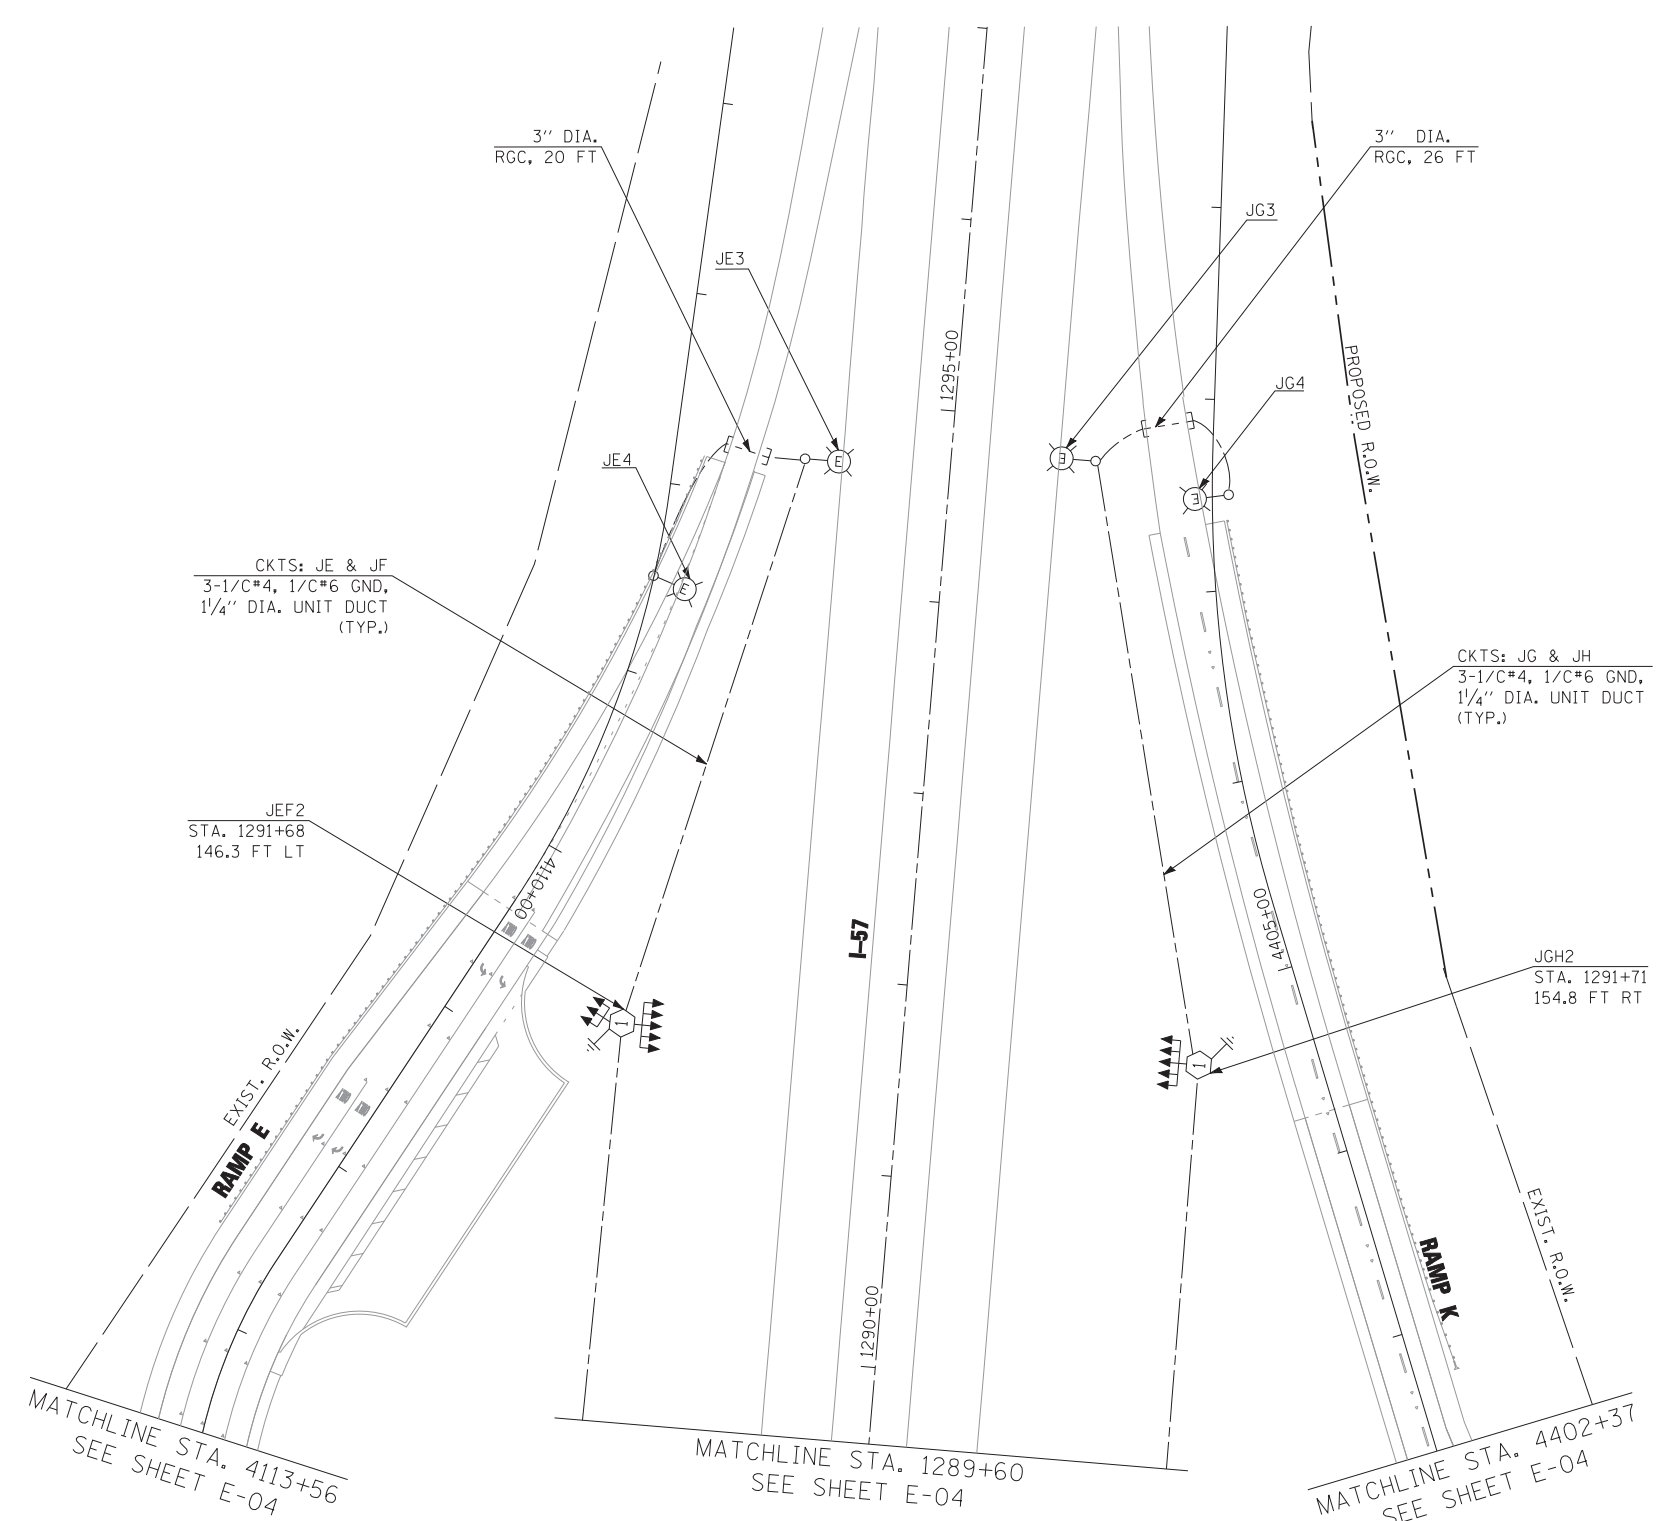

USER NAME = rswanson	DESIGNED - RDP	REVISED -
	DRAWN - PS	REVISED -
PLOT SCALE = 50:1	CHECKED - RAS	REVISED -
PLOT DATE = 4/23/2012	DATE - 04/20/2012	REVISED -

**STATE OF ILLINOIS  
DEPARTMENT OF TRANSPORTATION**

**147TH STREET  
PROPOSED LIGHTING PLAN**

SCALE: 1"=50' SHEET NO. 6 OF 6 SHEETS STA. 1289+60 TO STA. 1297+00

F.A.I. RTE.	SECTION	COUNTY	TOTAL SHEETS	SHEET NO.
	(0405-1 & 0506-2) R-1	COOK	577	423
FED. ROAD DIST. NO.			CONTRACT NO. 60M57	
ILLINOIS FED. AID PROJECT				

...D160M57-sht-light7.dgn

4/23/2012 10:42:29 PM