



DATE	
BY	
PROJECT	
PLANNED	
NOTED	
NO.	

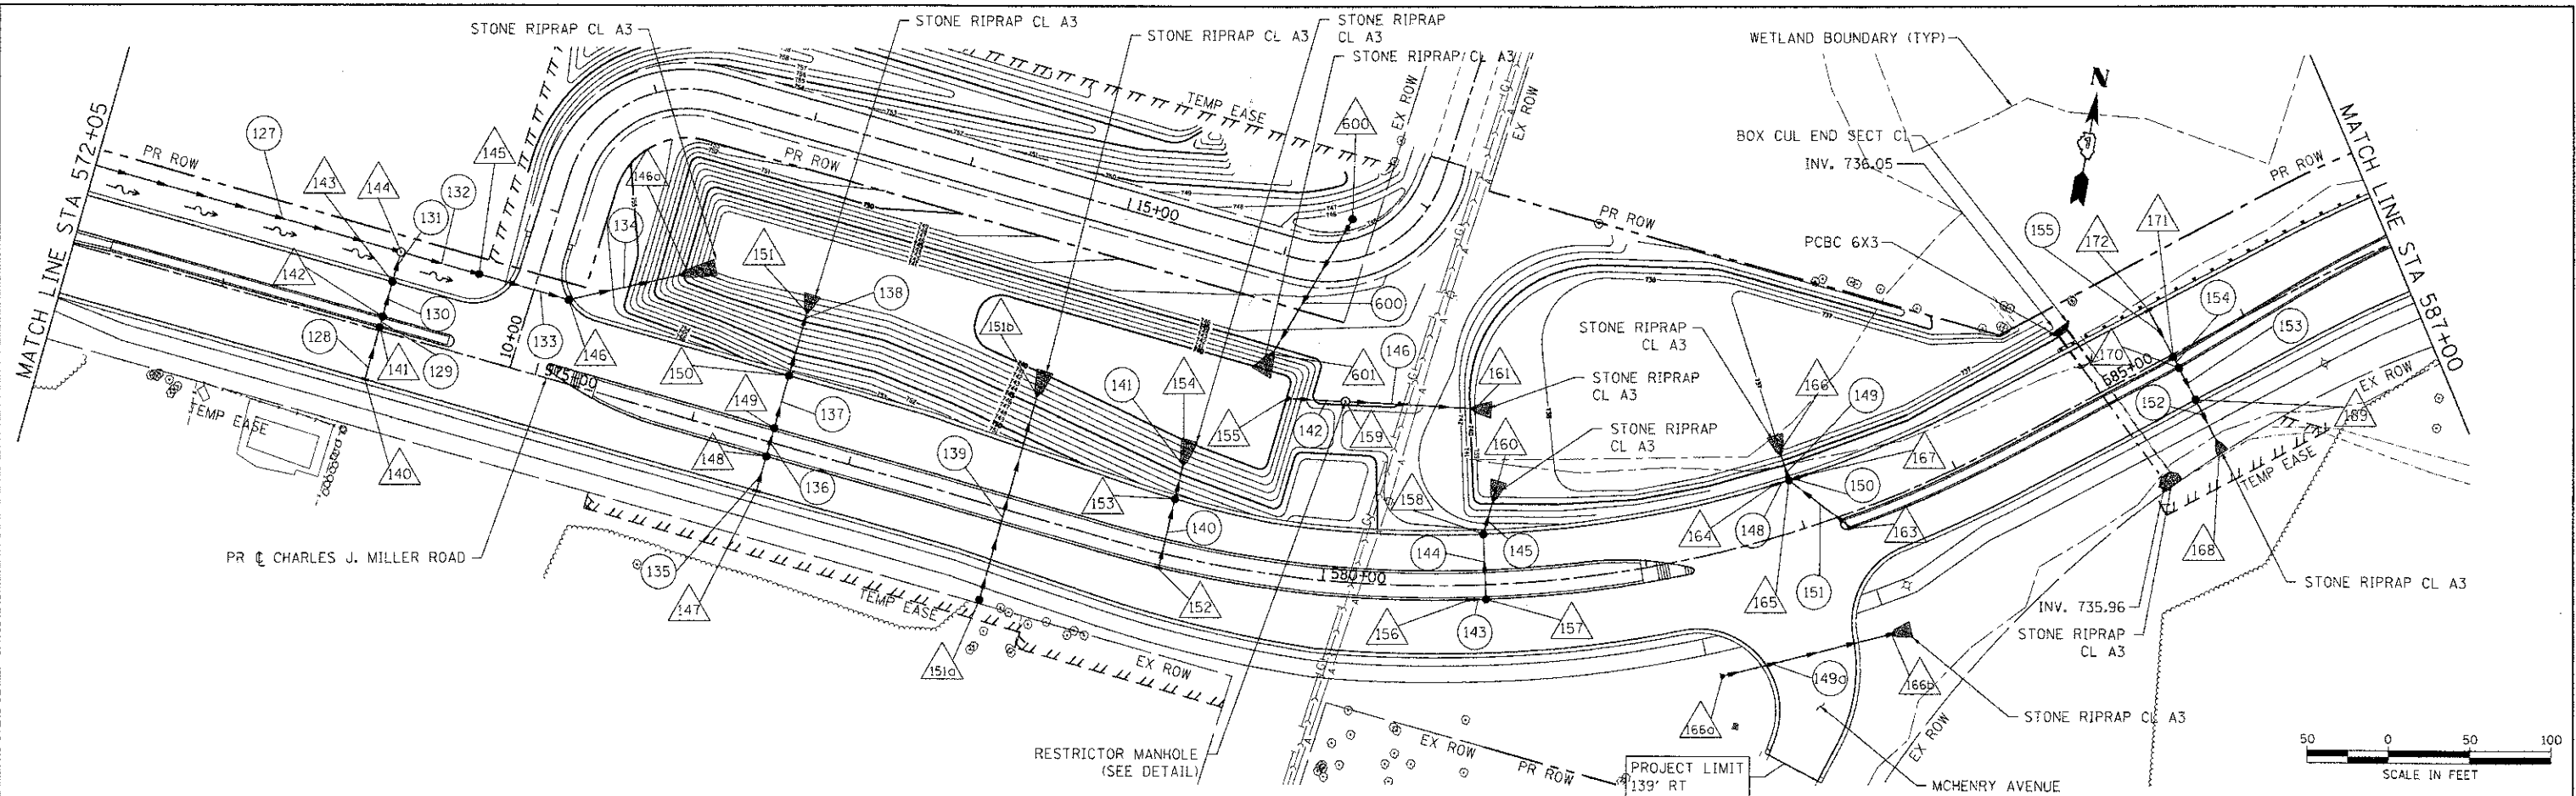

DATE	
BY	
PROJECT	
PLANNED	
NOTED	
NO.	

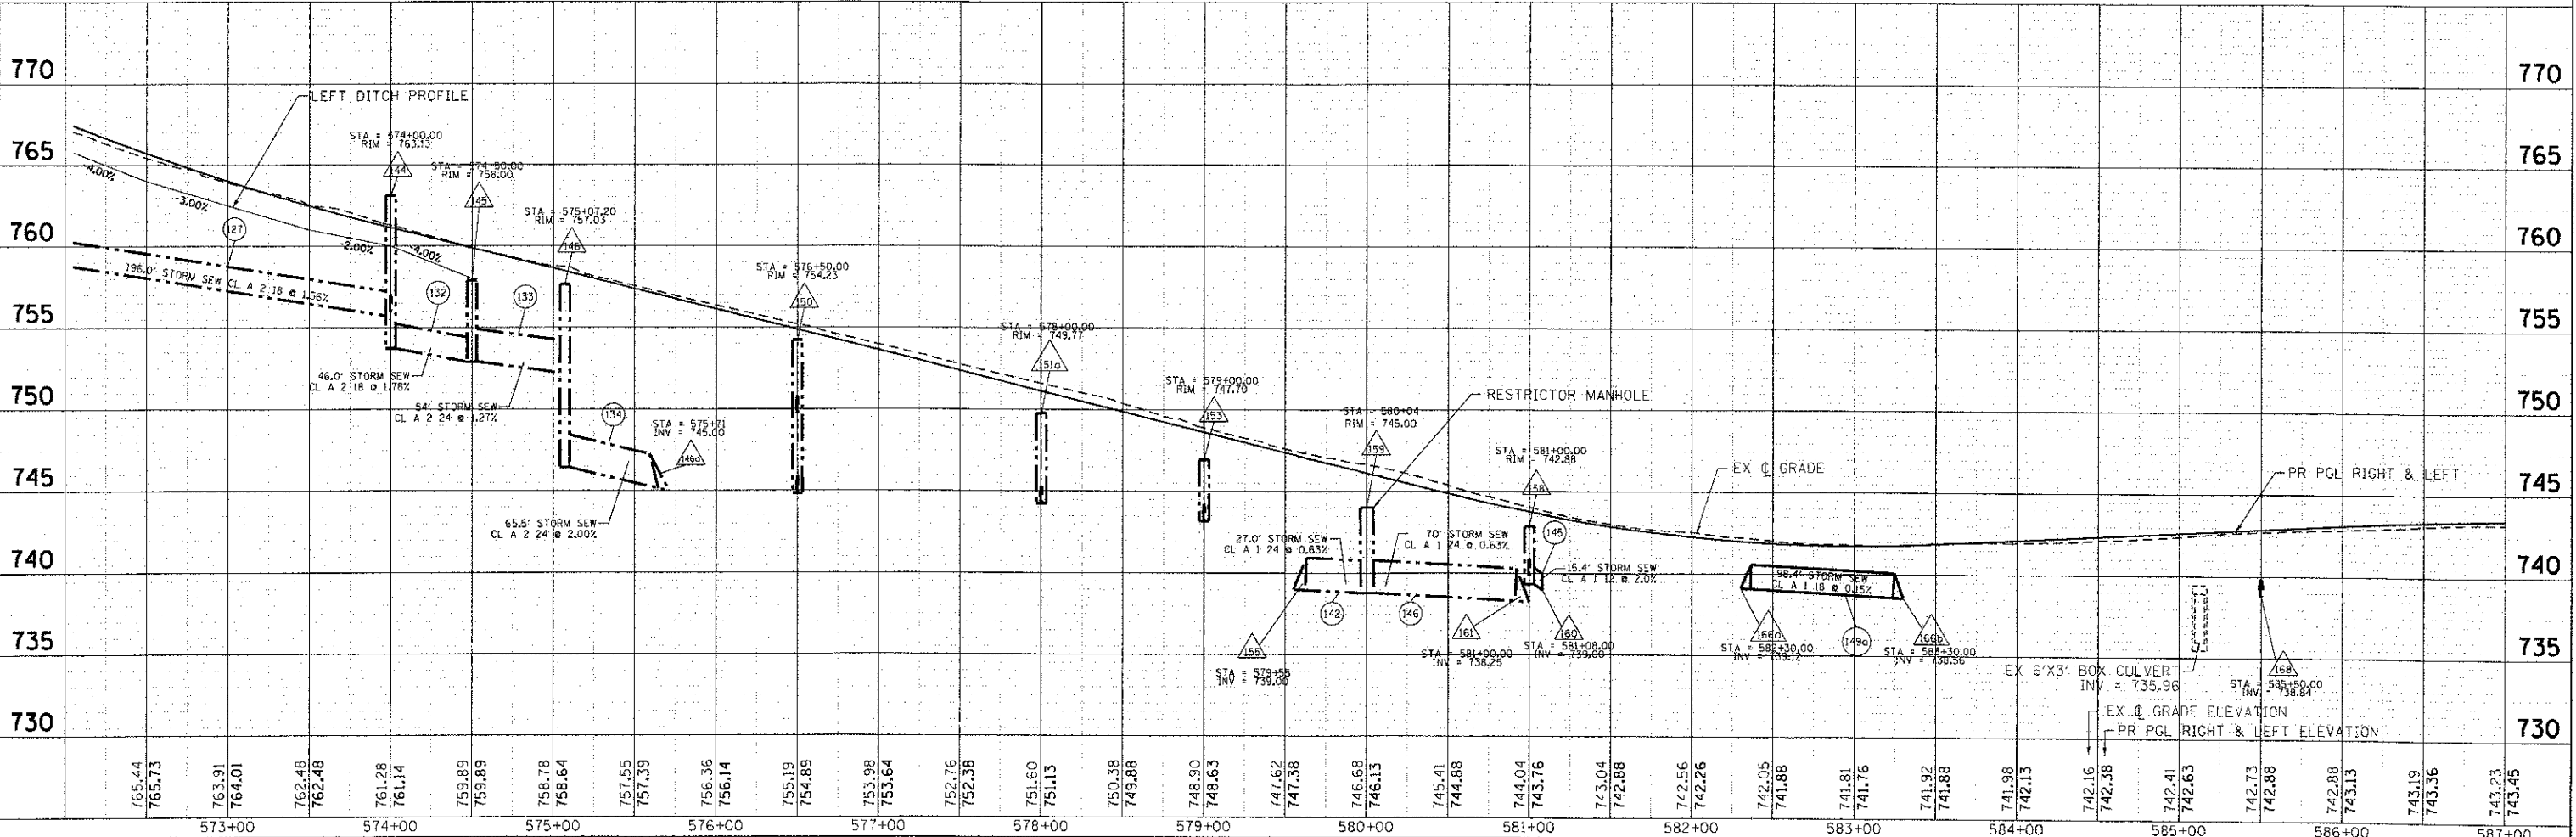

COMPANY NAME: HRGreen.com
 PROJECT CONTACT: J. J. J. J.
 DATE PLOTTED: 7/23/2012 10:20:12 AM
 FILE NAME: 090071-dpa-05.dgn
 PLOT SCALE: 1" = 50'
 PLOT DATE: 7/23/2012

USER NAME	jjj
FILE NAME	090071-dpa-05.dgn
PLOT SCALE	1" = 50'
PLOT DATE	7/23/2012

DESIGNED	JPA
DRAWN	SVJ
CHECKED	JLP
DATE	7/23/12

REVISED	-
REVISED	-
REVISED	-
REVISED	-

STATE OF ILLINOIS
DEPARTMENT OF TRANSPORTATION

DRAINAGE AND UTILITY PLAN AND PROFILE - CHARLES J. MILLER ROAD
CHARLES J. MILLER ROAD ROADWAY IMPROVEMENTS

F.A.U. RTE.	SECTION	COUNTY	TOTAL SHEETS	NO.
3860	09-00372-00-PW	MCHENRY	252	64
CONTRACT NO.			63633	
ILLINOIS FED. AID PROJECT				

SCALE: 1" = 50' SHEET NO. 2 OF 6 SHEETS STA. 572+00 TO STA. 587+00