



DATE	
BY	
REVISION	
NO.	
PLAN	
NO.	
DATE	
BY	
REVISION	
NO.	

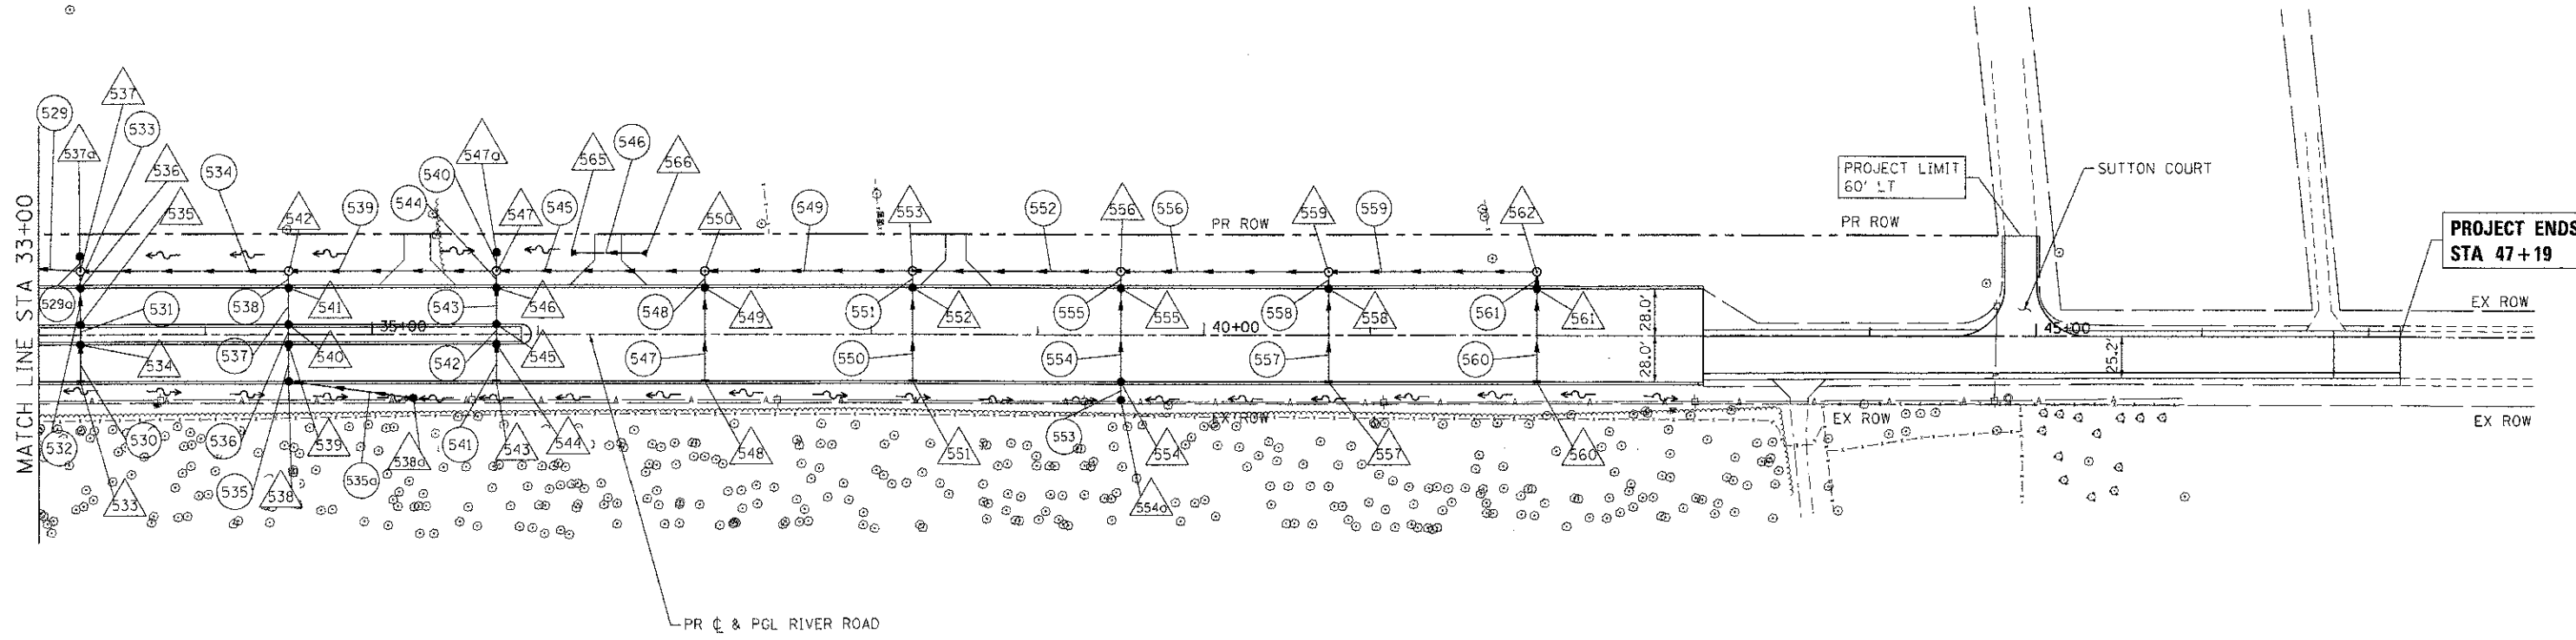

DATE	
BY	
REVISION	
NO.	
PROFILE	
NO.	
DATE	
BY	
REVISION	
NO.	

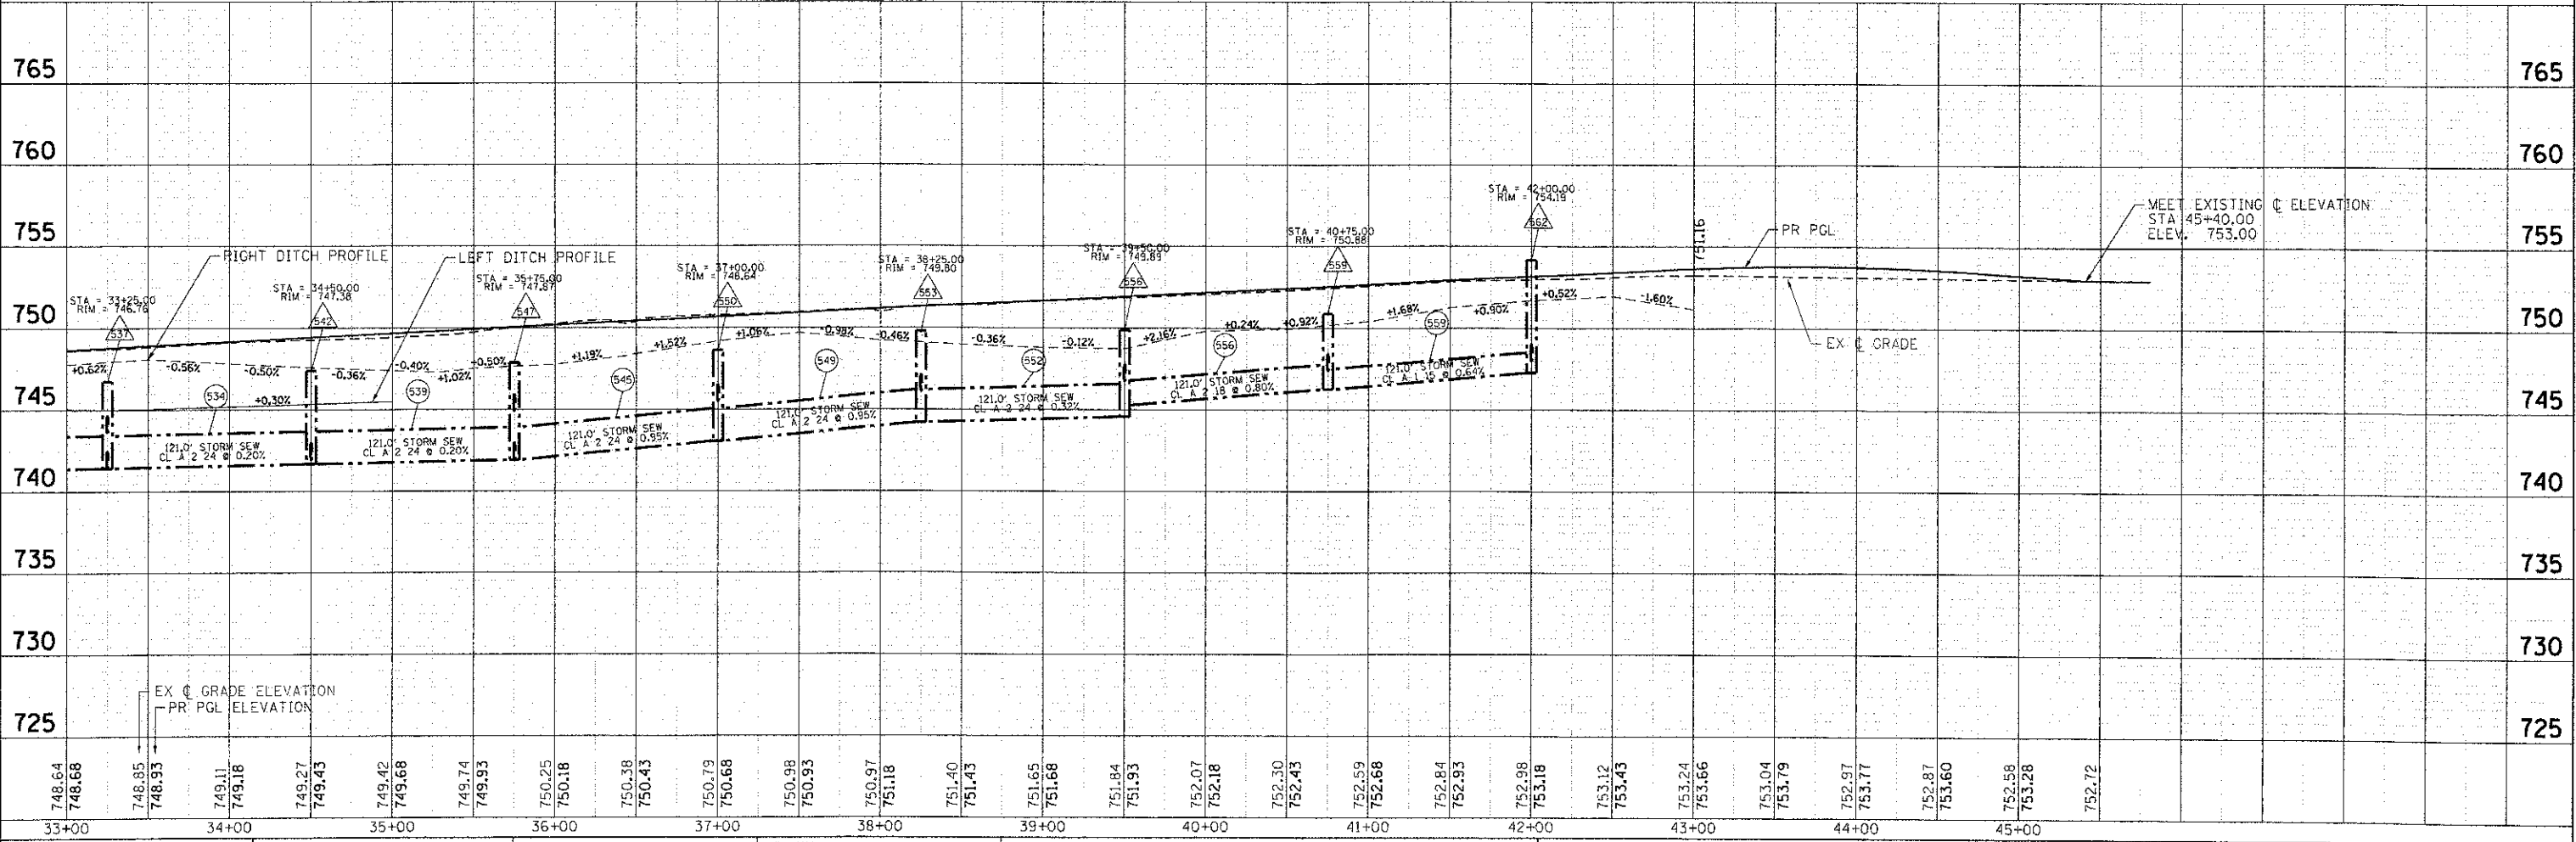

COMPANY NAME: HRGreen.com
 PROJECT CONTACT: J. J. J. J.
 CLIENT: STATE OF ILLINOIS
 DATE PLOTTED: 7/23/2012 10:05:07 AM
 PLOT NUMBER: 09-C0372-00-PW
 PEN TABLE: Standard-Pros.tbl

HRGreen.com
 Illinois Professional Design Firm
 # 184-001322

USER NAME = j. j. j.	DESIGNED - JPA	REVISED -
FILE NAME = 090871-dpp-13.dgn	DRAWN - SVJ	REVISED -
PLOT SCALE = 1" = 50'	CHECKED - JLP	REVISED -
PLOT DATE = 7/23/2012	DATE - 7/23/12	REVISED -

STATE OF ILLINOIS
DEPARTMENT OF TRANSPORTATION

DRAINAGE AND UTILITY PLAN AND PROFILE - RIVER ROAD
CHARLES J. MILLER ROAD ROADWAY IMPROVEMENTS

F.A.U. RTE. 3860	SECTION 09-C0372-00-PW	COUNTY MCHENRY	TOTAL SHEETS 252	SHEET NO. 68
CONTRACT NO. 63633				ILLINOIS FED. AID PROJECT

SCALE: 1" = 50' SHEET NO. 6 OF 6 SHEETS STA. 33+00 TO STA. 45+40