
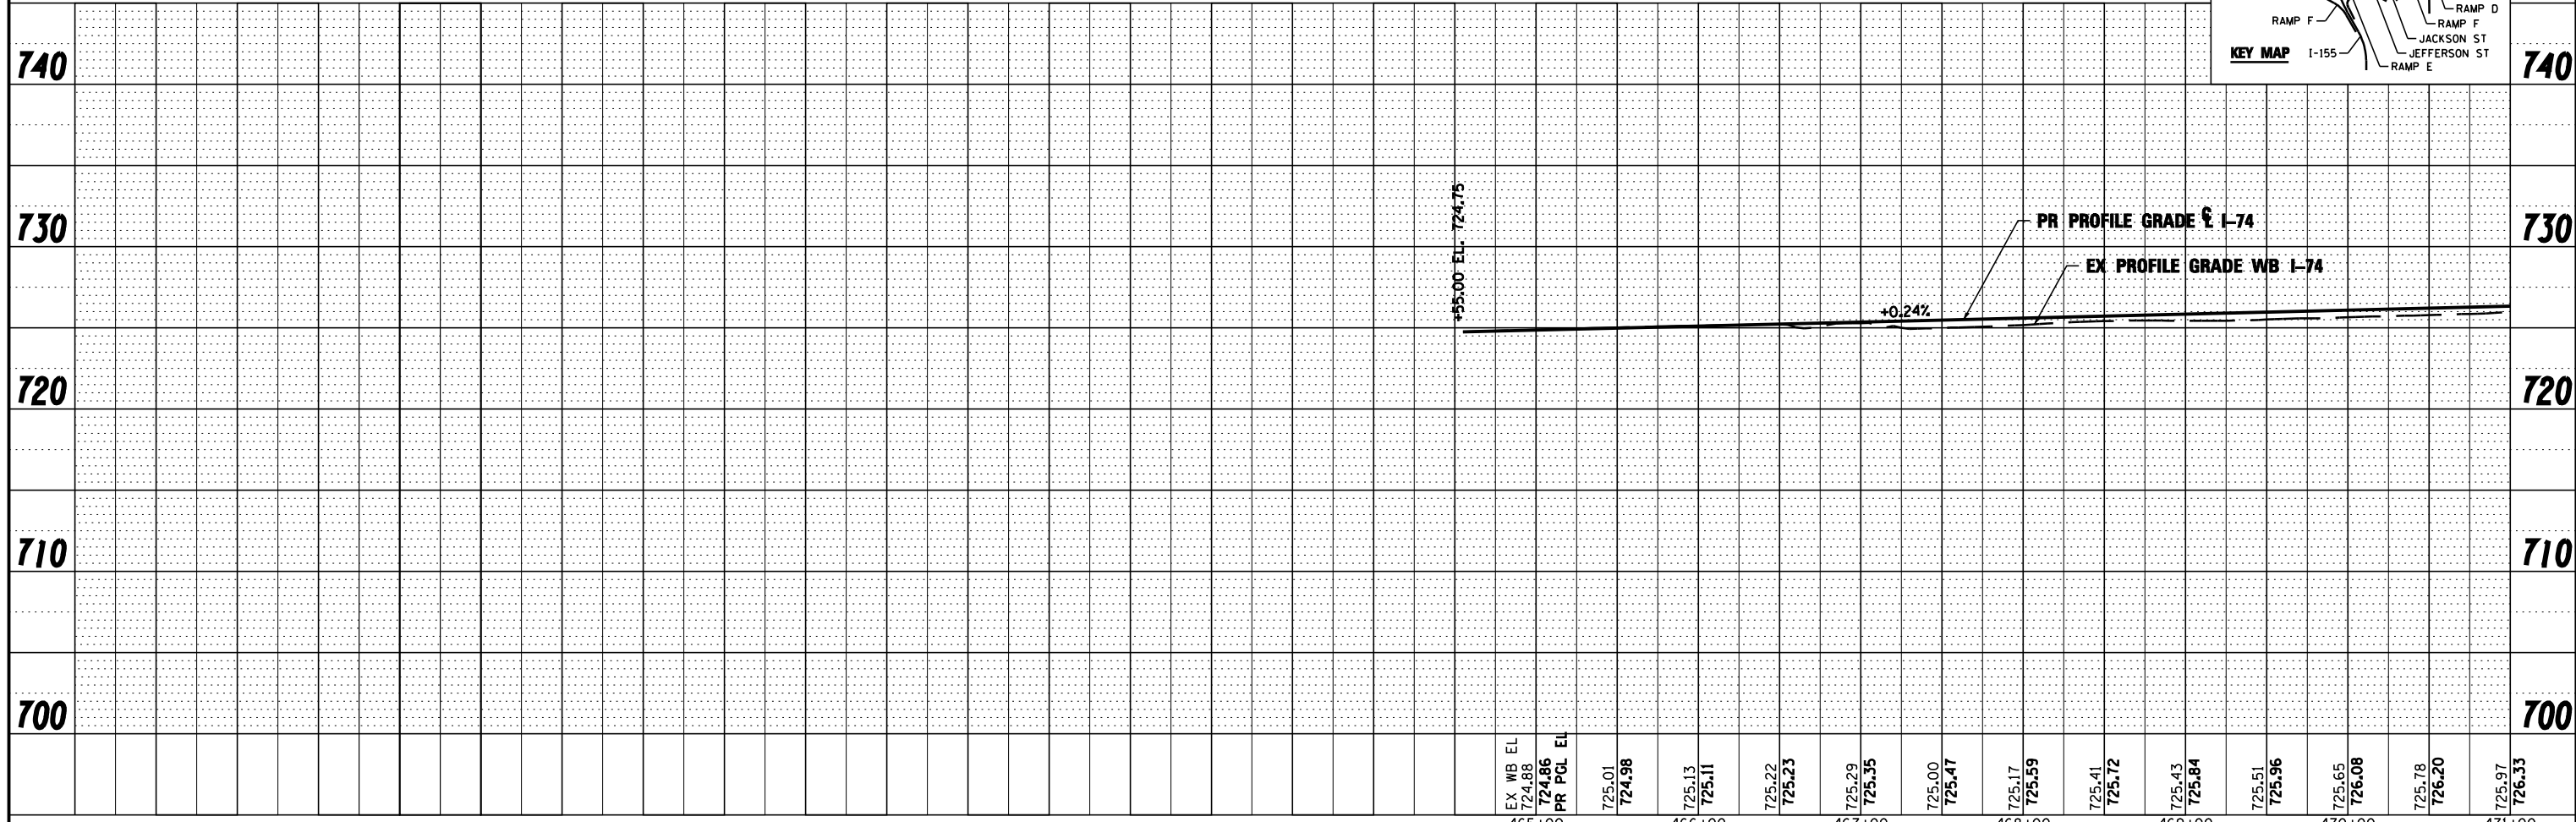


PLAN	SURVEYED	DATE
	PLOTTED	BY
	CHECKED	
	AT	
	FILE NAME	
	NO.	

PROFILE	SURVEYED	DATE
	PLOTTED	BY
	CHECKED	
	AT	
	NOT AT THIS OFFICE	
	NO.	

LUG SYSTEM COMPLETE 36'		
STATION	LUG	WIDTH
WB 466+01.59	W	36'
WB 465+81.59	X	36'
WB 465+61.59	Y	36'

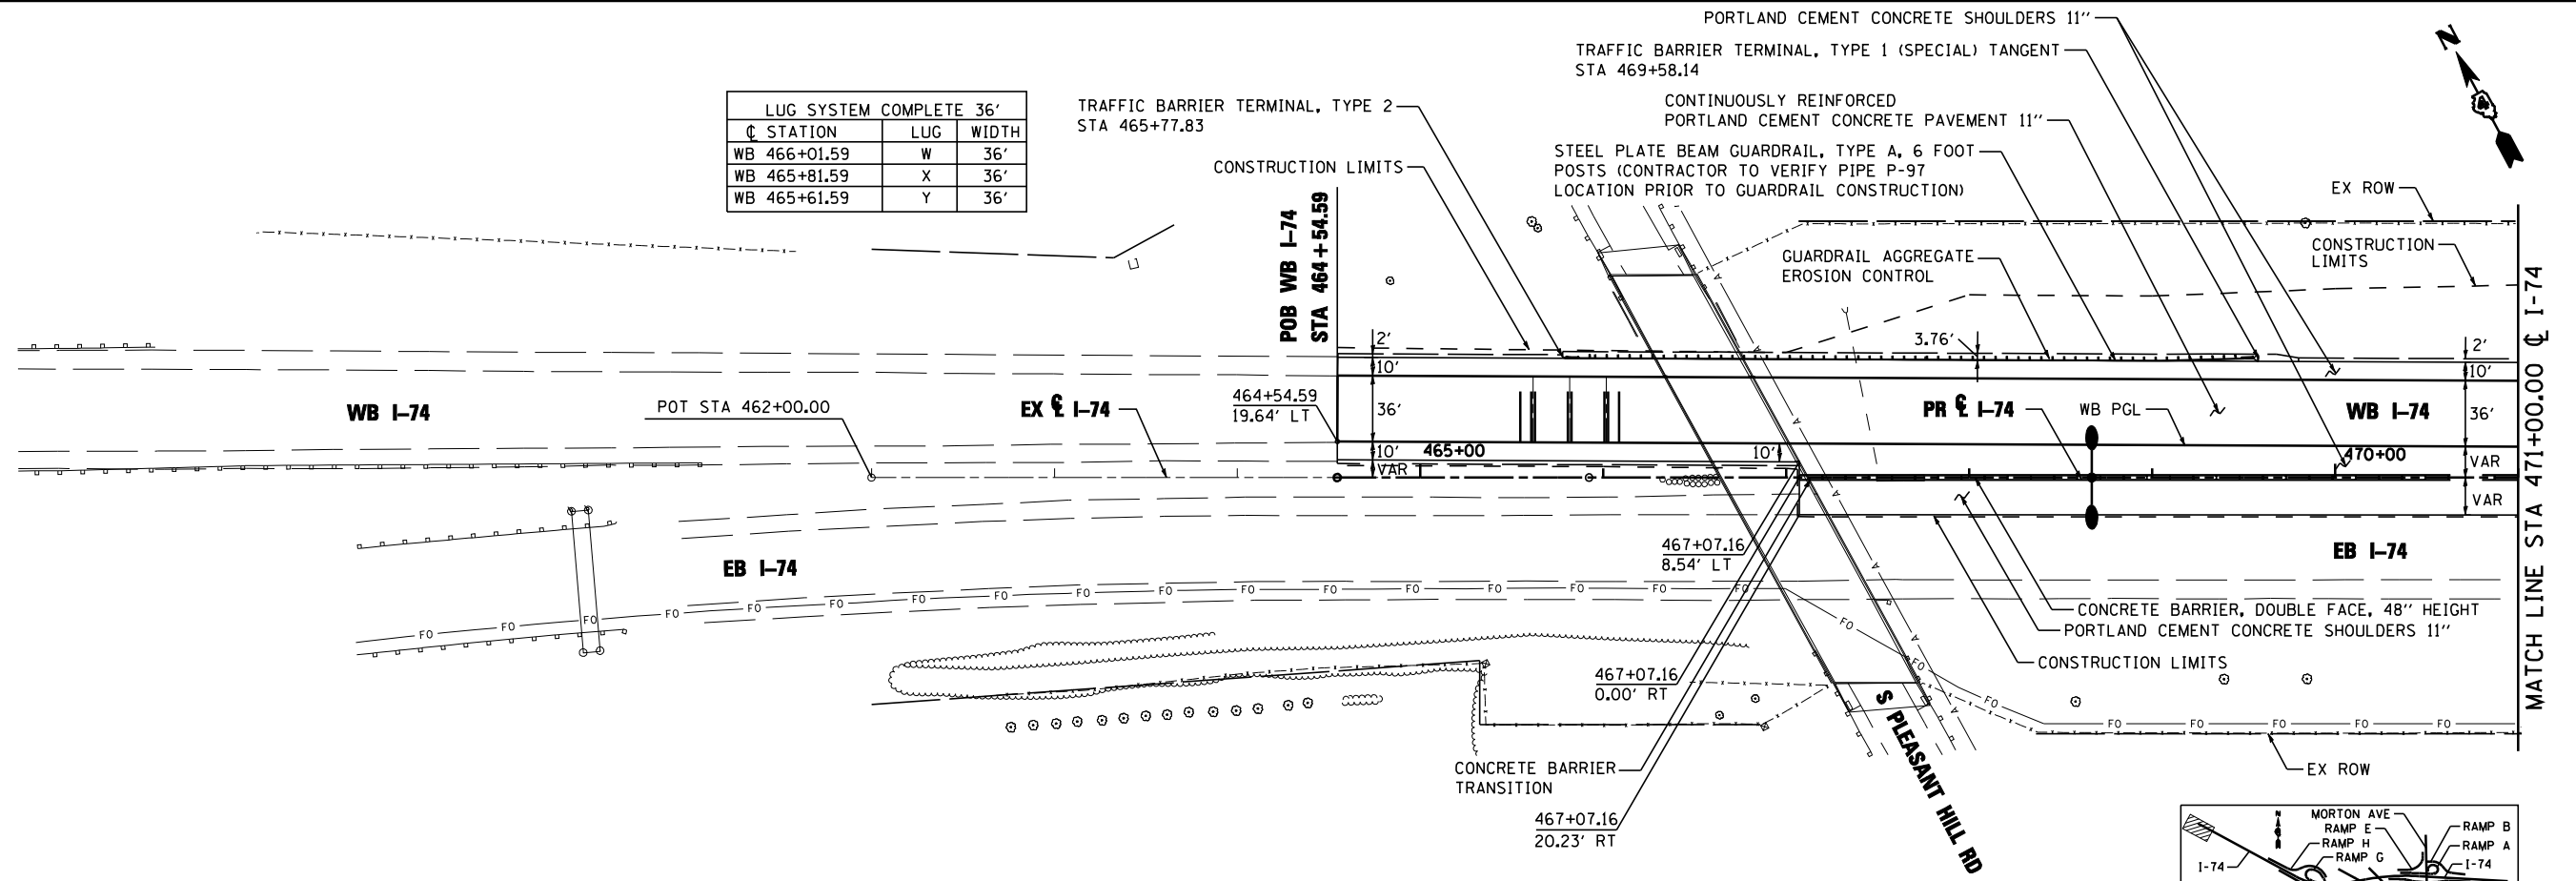

FILE NAME =	DESIGNED - EJA	REVISED -
...D468620-sht-1-74-plnpr-f01.dgn	DRAWN - TMB	REVISED -
USER NAME = jreambillo	CHECKED - JNR	REVISED -
PLOT DATE = 7/26/2012	DATE - JULY 20, 2012	REVISED -



STATE OF ILLINOIS
DEPARTMENT OF TRANSPORTATION

PLAN AND PROFILE	
I-74	
SCALE: 1"=50'	SHEET NO. 1 OF 11 SHEETS
STA. BOP	TO STA. 471+00.00

F.A.I. RTE.	SECTION	COUNTY	TOTAL SHEETS	SHEET NO.
90-114R(14HB-4,14,14HVB)BR	TAZEWELL	2433	208	
CONTRACT NO. 68620			ILLINOIS FED. AID PROJECT	